


NOTICE OF AMENDMENT

RE: DSYA 2020-0004- Invitation to Tender for Construction of a Traditional Block and Concrete Single Storey Structure to the Goodwood Pavilion

The Division of Sport and Youth Affairs wishes to notify all proponents that the drawings for the above mentioned tender was not included in the previously posted Tender document. However, detailed Drawings are outlined below:

1/15/2004

GROUND FLOOR PLAN

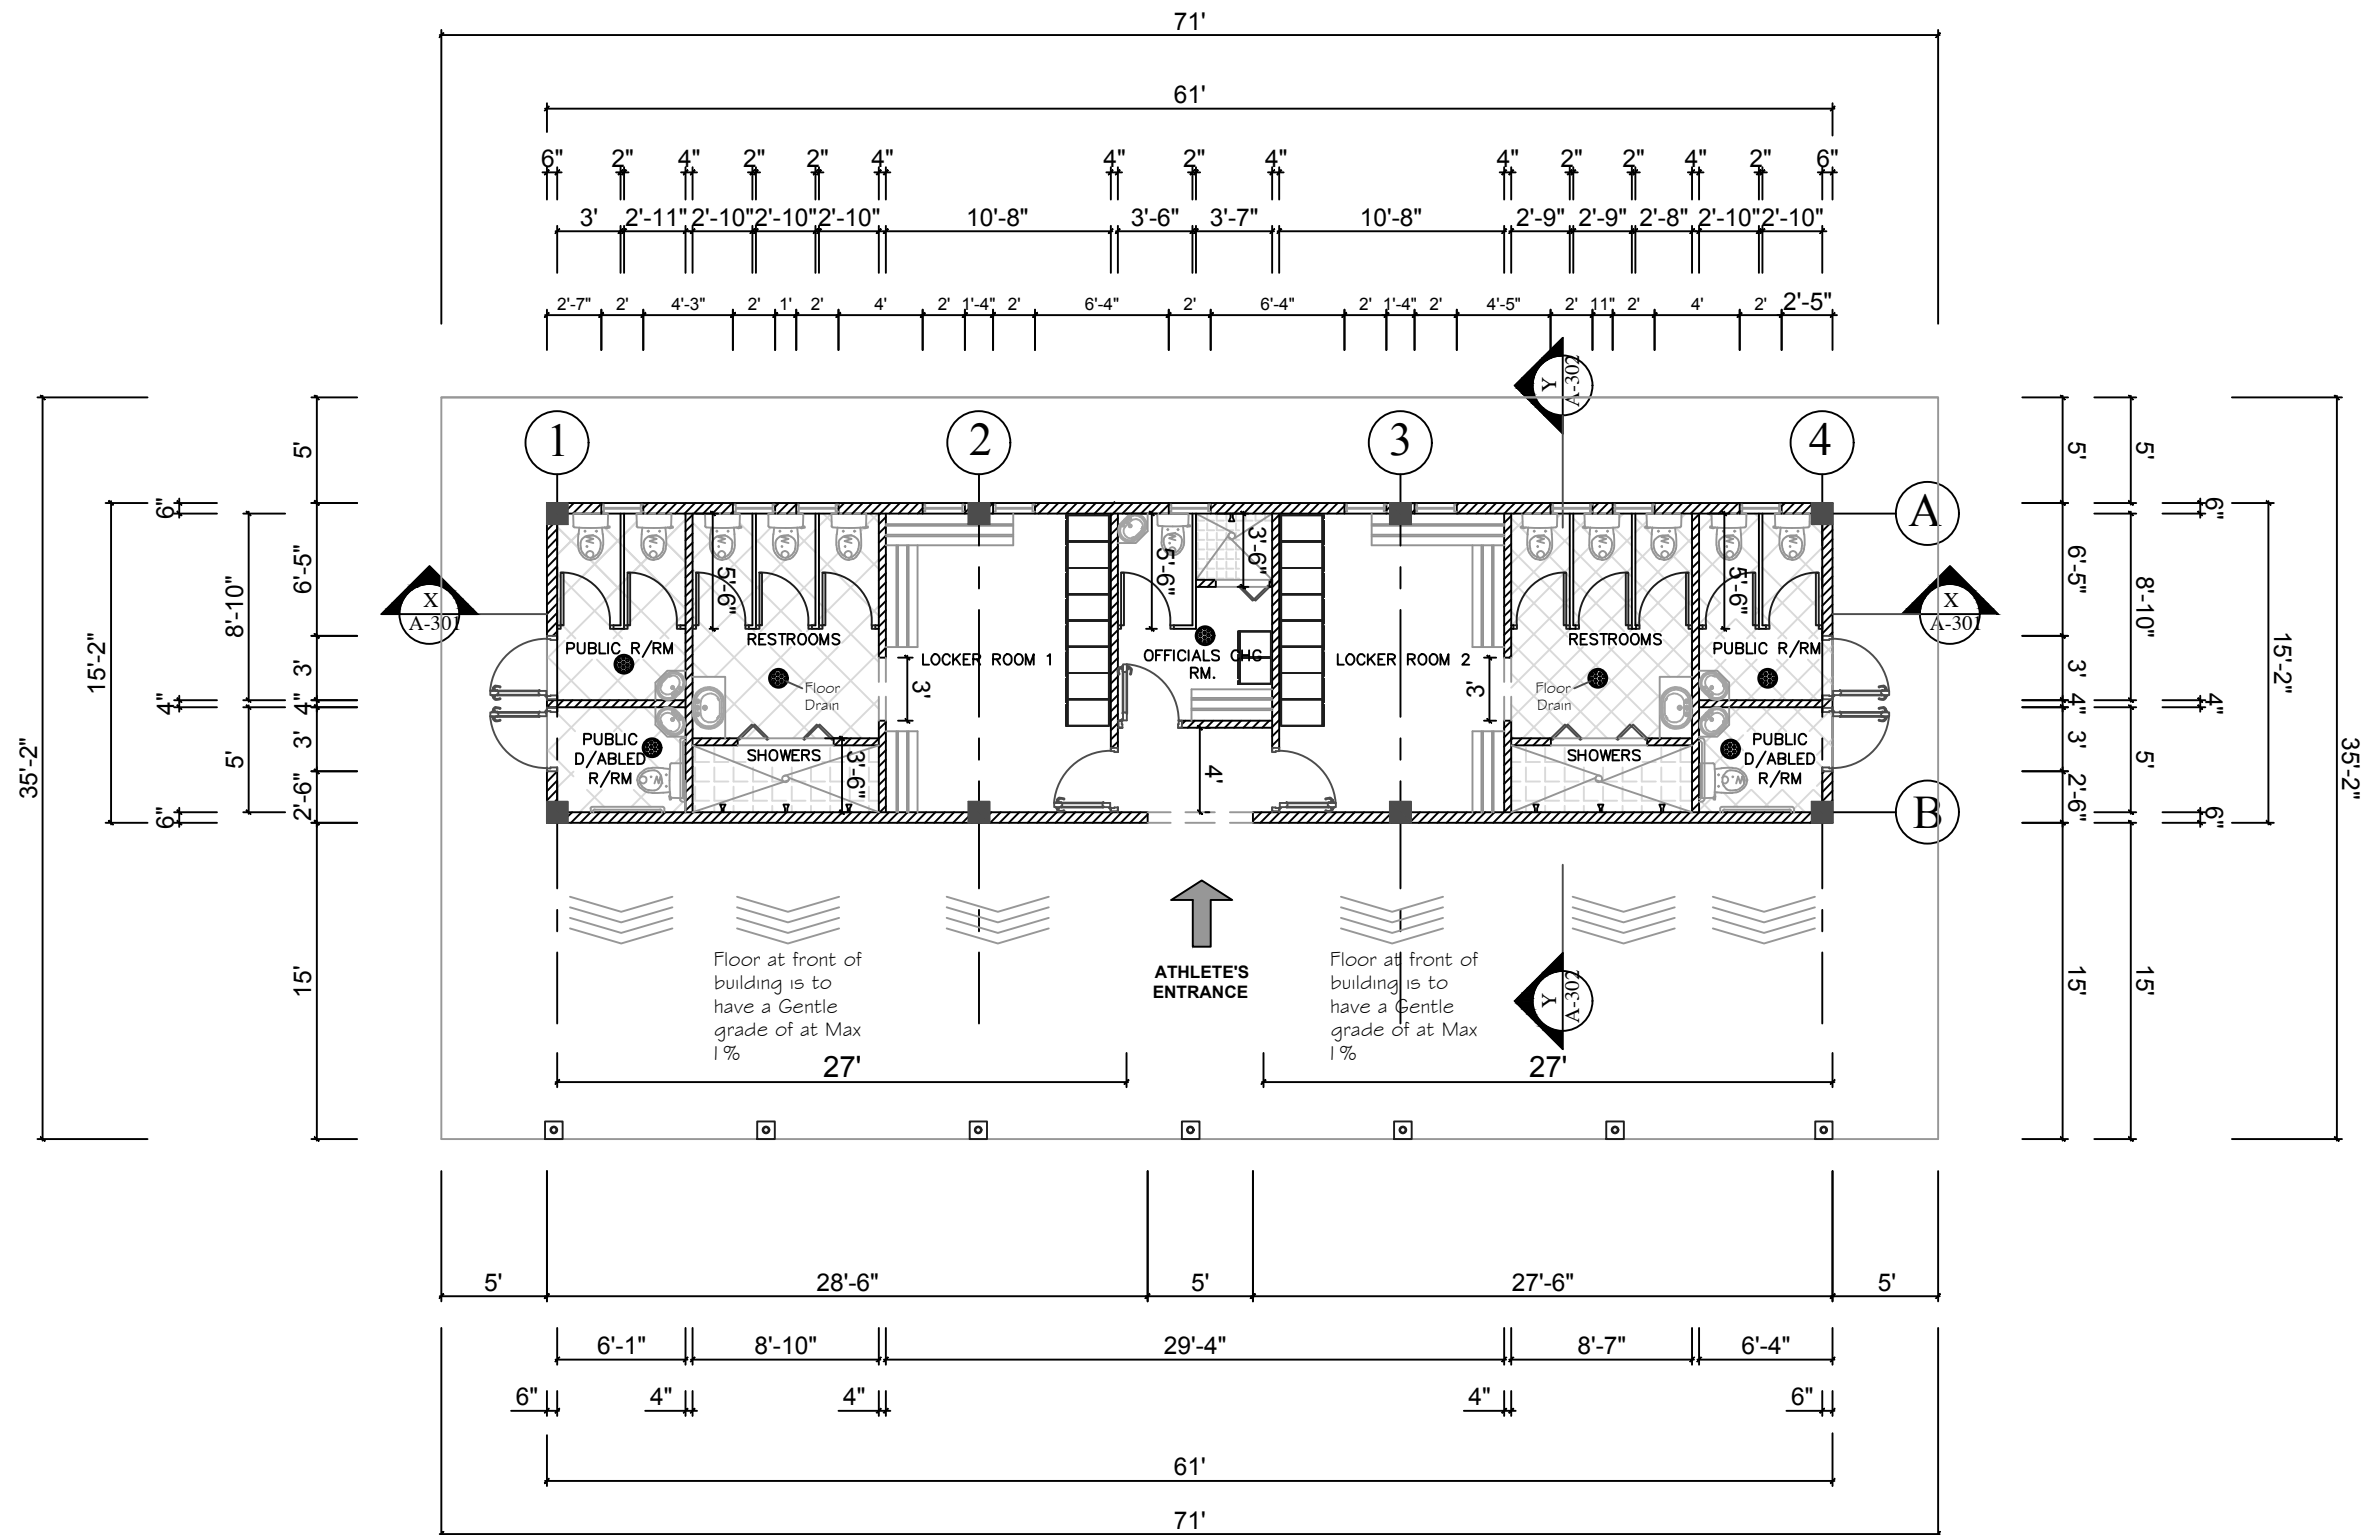

General Notes

- FLOORING OF RESTROOMS AND SHOWERS OF THE FACILITY ARE TILED THROUGHOUT W/ 12"x12" NON-SKID CERAMIC TILES (SEE NOTES ON SECTION DRAWINGS FOR WALL TILE SIZES AND HEIGHTS).

-INTERIOR AND EXTERIOR WALLS ARE TO BE PAINTED WITH SHERWIN WILLIAMS PAINTS - COLOUR TO BE ISSUED BY PROJECT SUPPORT OFFICER.

-SEE PAGES A-501 AND A-502 FOR LOCKER AND BENCH DETAILS.

No.	Revision/Issue	Date

Firm Name and Address

DIVISION OF SPORT & YOUTH AFFAIRS
JANIS SOLOMON BLDG
28 ORANGE HILL RD
SCARBOROUGH, TOBAGO

DRAWN BY:
CHECKED BY:

Project Name and Address

CHANGE ROOM & TOILET FACILITY

Drawing:
GROUND FLOOR PL.


Date:
12/20/2019

Scale:
1/4" = 1' 0"

Sheet

A-101

1/15/2004

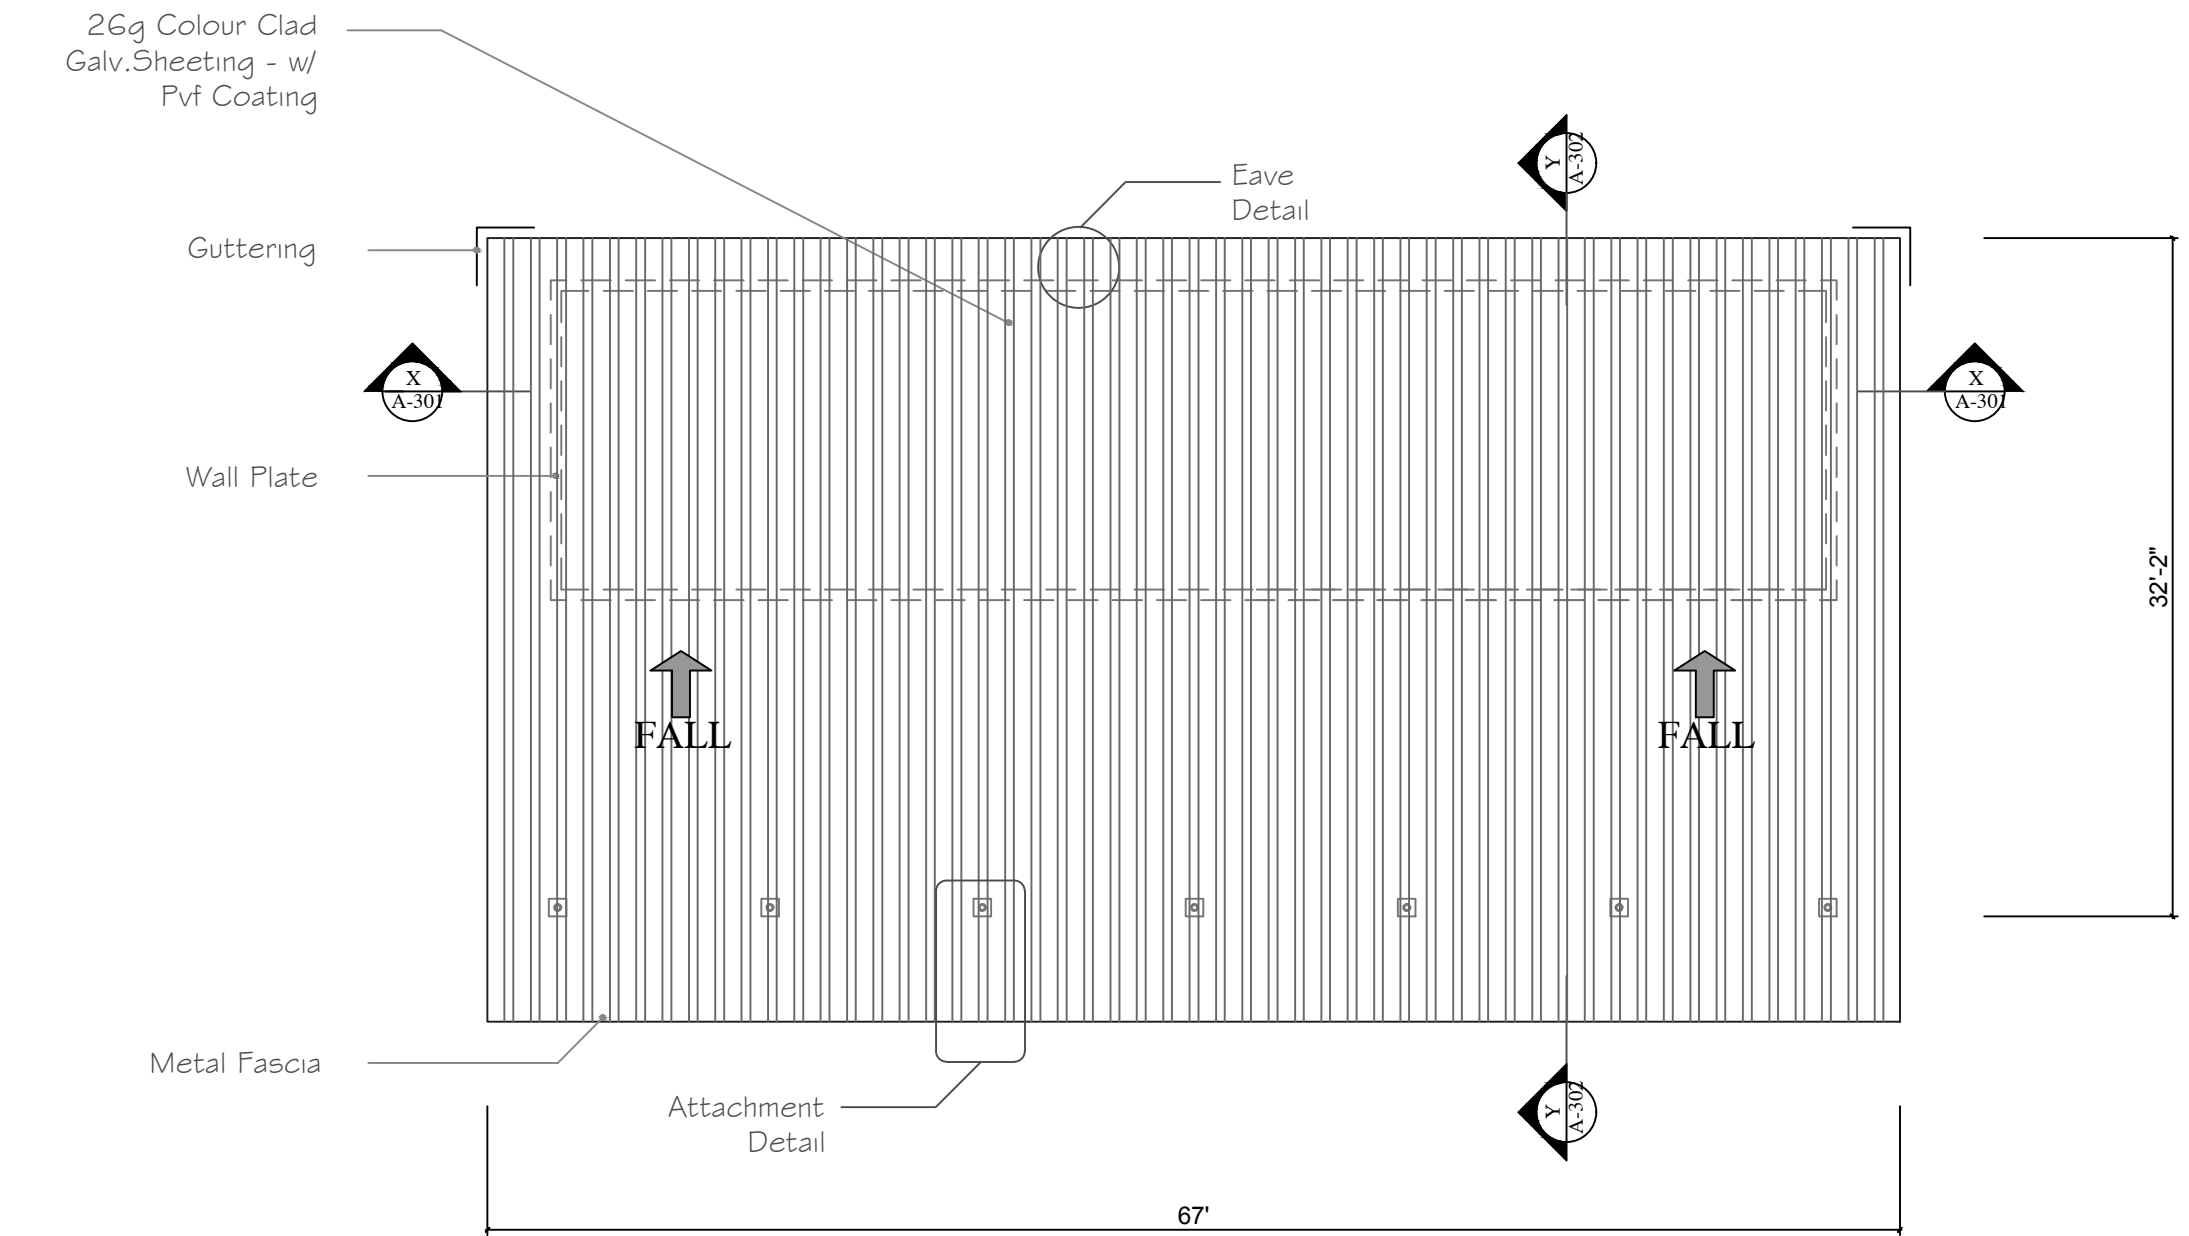

ROOF PLAN

General Notes

- EAVE OVERHANG AT BACK AND SIDES OF BUILDING ARE 2' OFF OF EXTERIOR FACADE

No.	Revision/Issue	Date

Firm Name and Address

DIVISION OF SPORT & YOUTH AFFAIRS
JANIS SOLOMON BLDG
28 ORANGE HILL RD
SCARBOROUGH, TOBAGO

DRAWN BY:
CHECKED BY:

Project Name and Address

CHANGE ROOM & TOILET FACILITY



Drawing:	Sheet
ROOF PLAN	A-102
Date	
Scale	

1/7/2020


1/4" = 1' 0"

Page 4 of 22

1/15/2004

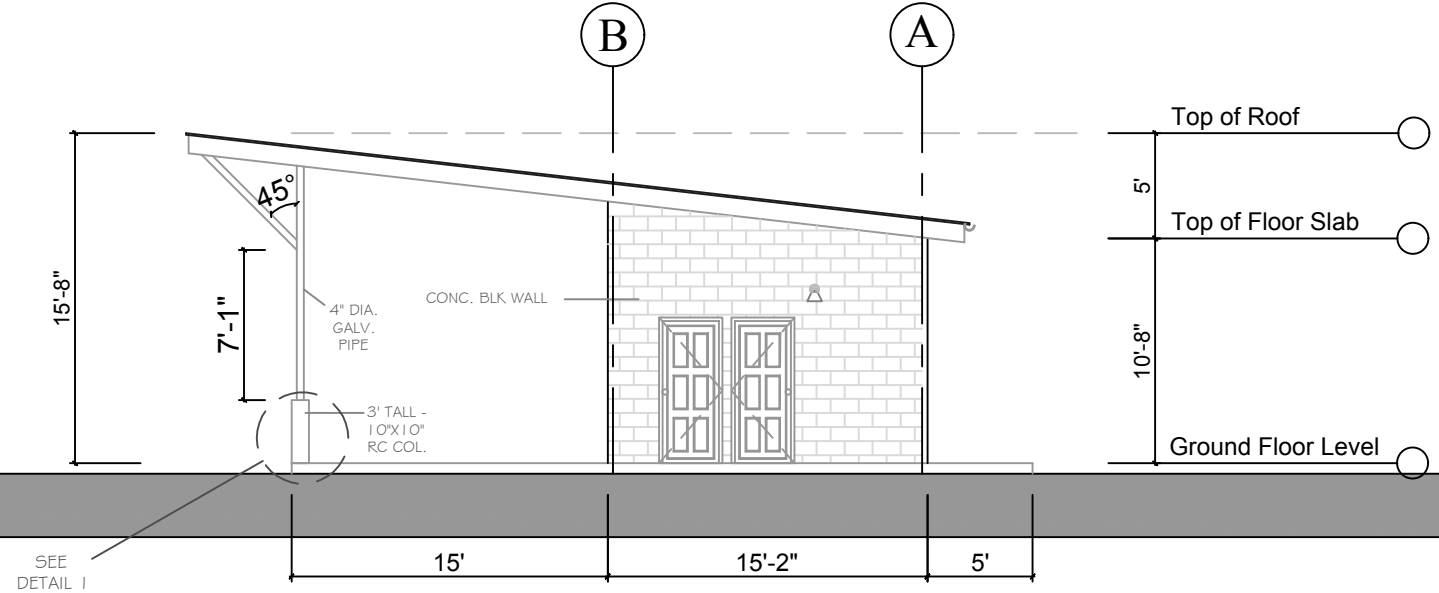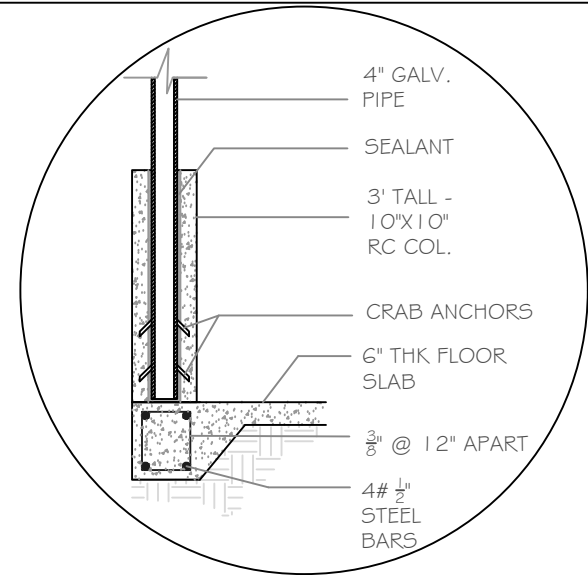

RIGHT ELEVATION

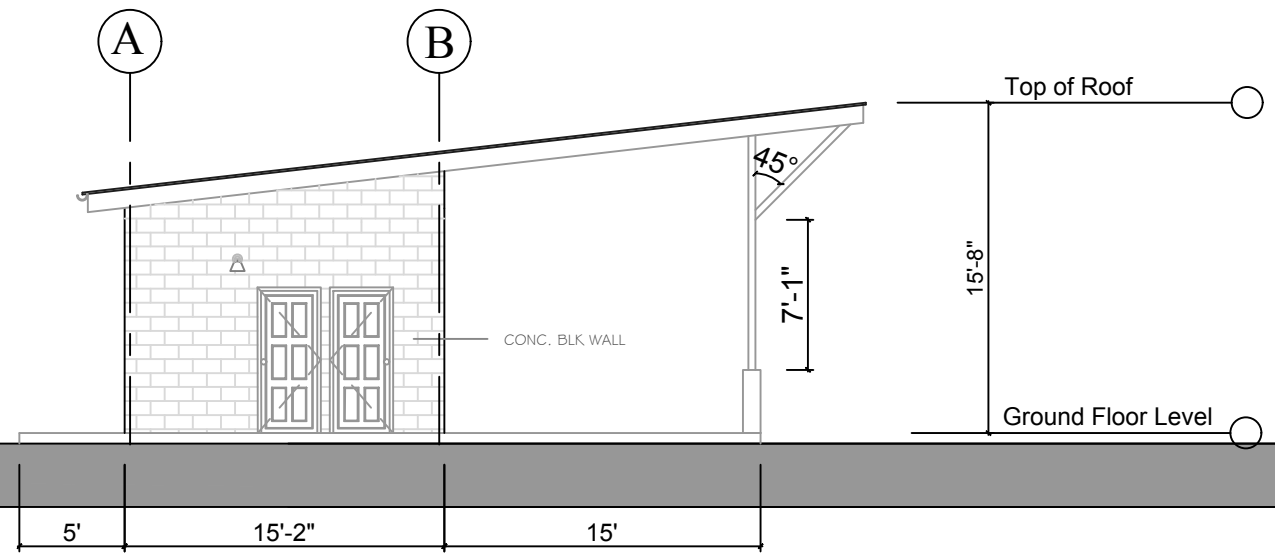

LEFT ELEVATION

General Notes

MATERIALS:

- CONC. BLOCK
- EARTH


No.	Revision/Issue	Date

Firm Name and Address
DIVISION OF SPORT & YOUTH AFFAIRS
JANIS SOLOMON BLDG
28 ORANGE HILL RD
SCARBOROUGH, TOBAGO
DRAWN BY:
CHECKED BY:

Project Name and Address
CHANGE ROOM & TOILET FACILITY

Drawing: RIGHT/LEFT ELEV.	Sheet A-202
Date 1/7/2020	
Scale 1/4" = 1' 0"	

1/15/2004

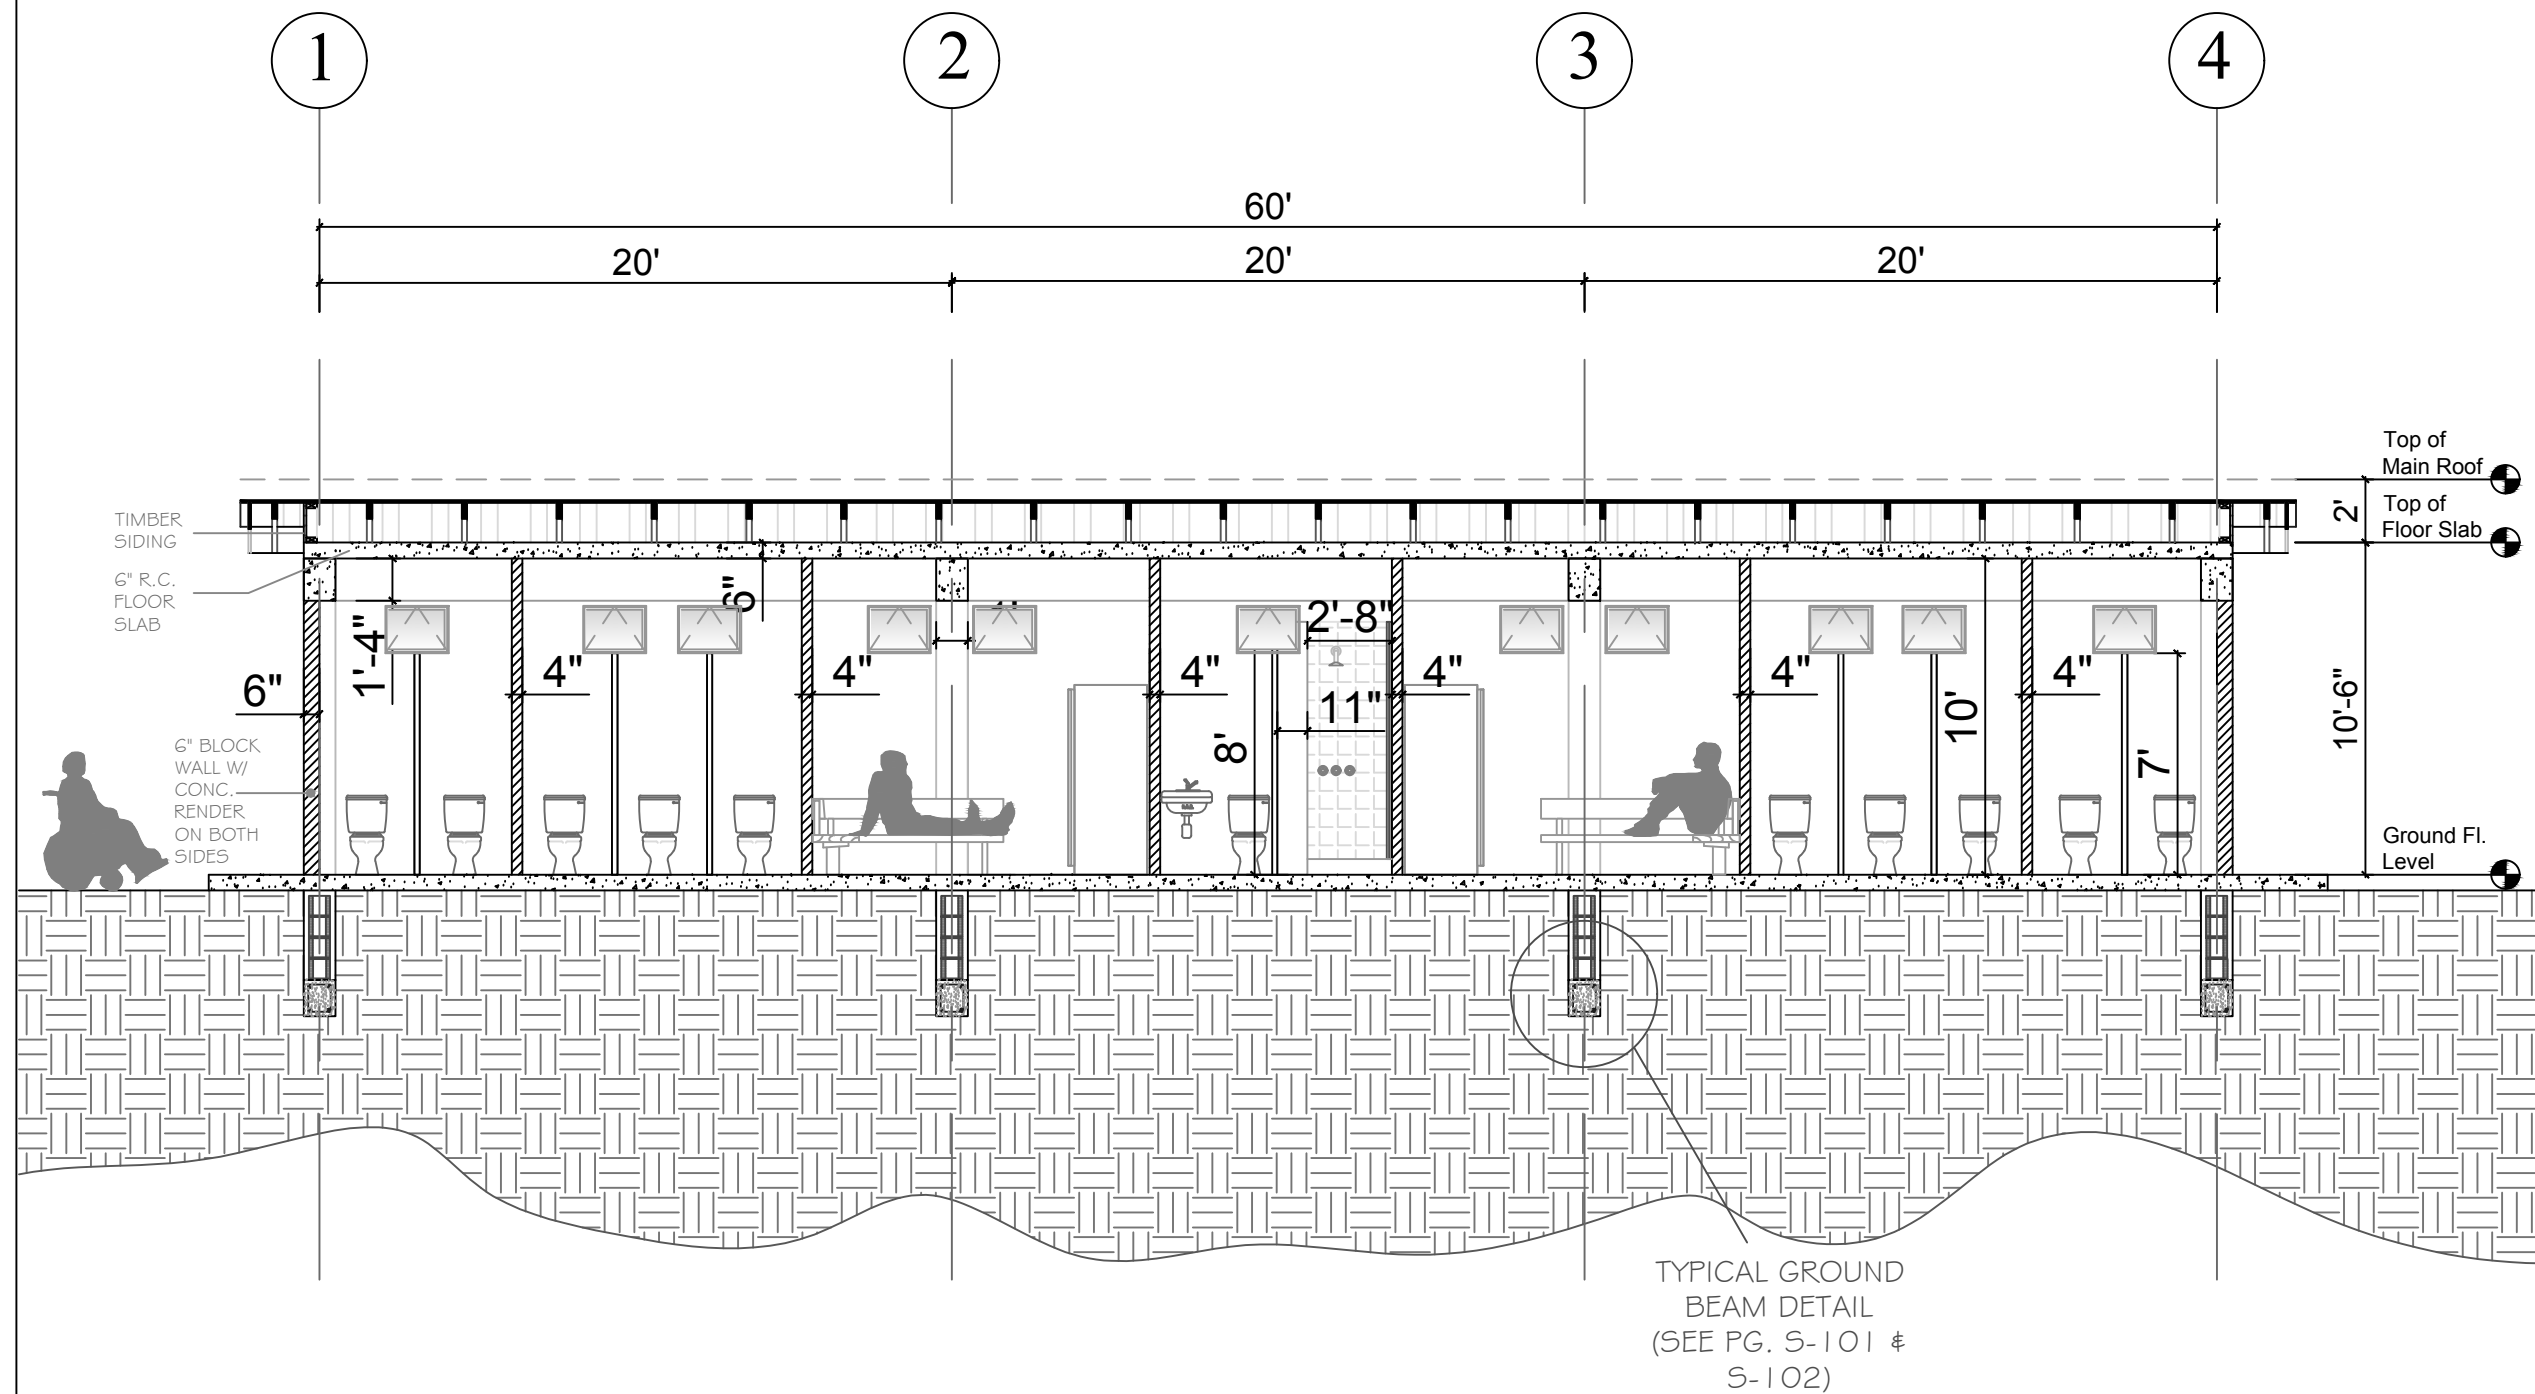

SECTION X-X

General Notes

- WALLS OF SHOWER STALLS ARE TILED 8' HIGH; WHILE TOILET STALLS ARE TILED 4' HIGH - USING 12"X12" CERAMIC WALL TILES.

MATERIALS:

	CON. BLOCK WALL
	TIMBER
	CONCRETE
	EARTH

No.	Revision/Issue	Date

Firm Name and Address

DIVISION OF SPORT & YOUTH AFFAIRS
JANIS SOLOMON BLDG
28 ORANGE HILL RD
SCARBOROUGH, TOBAGO


DRAWN BY:
CHECKED BY:

Project Name and Address

CHANGE ROOM & TOILET FACILITY

Drawing:	Sheet:
SECTION X-X	A-301
Date: 12/20/2019	
Scale: 3/8" = 1' 0"	

1/15/2004

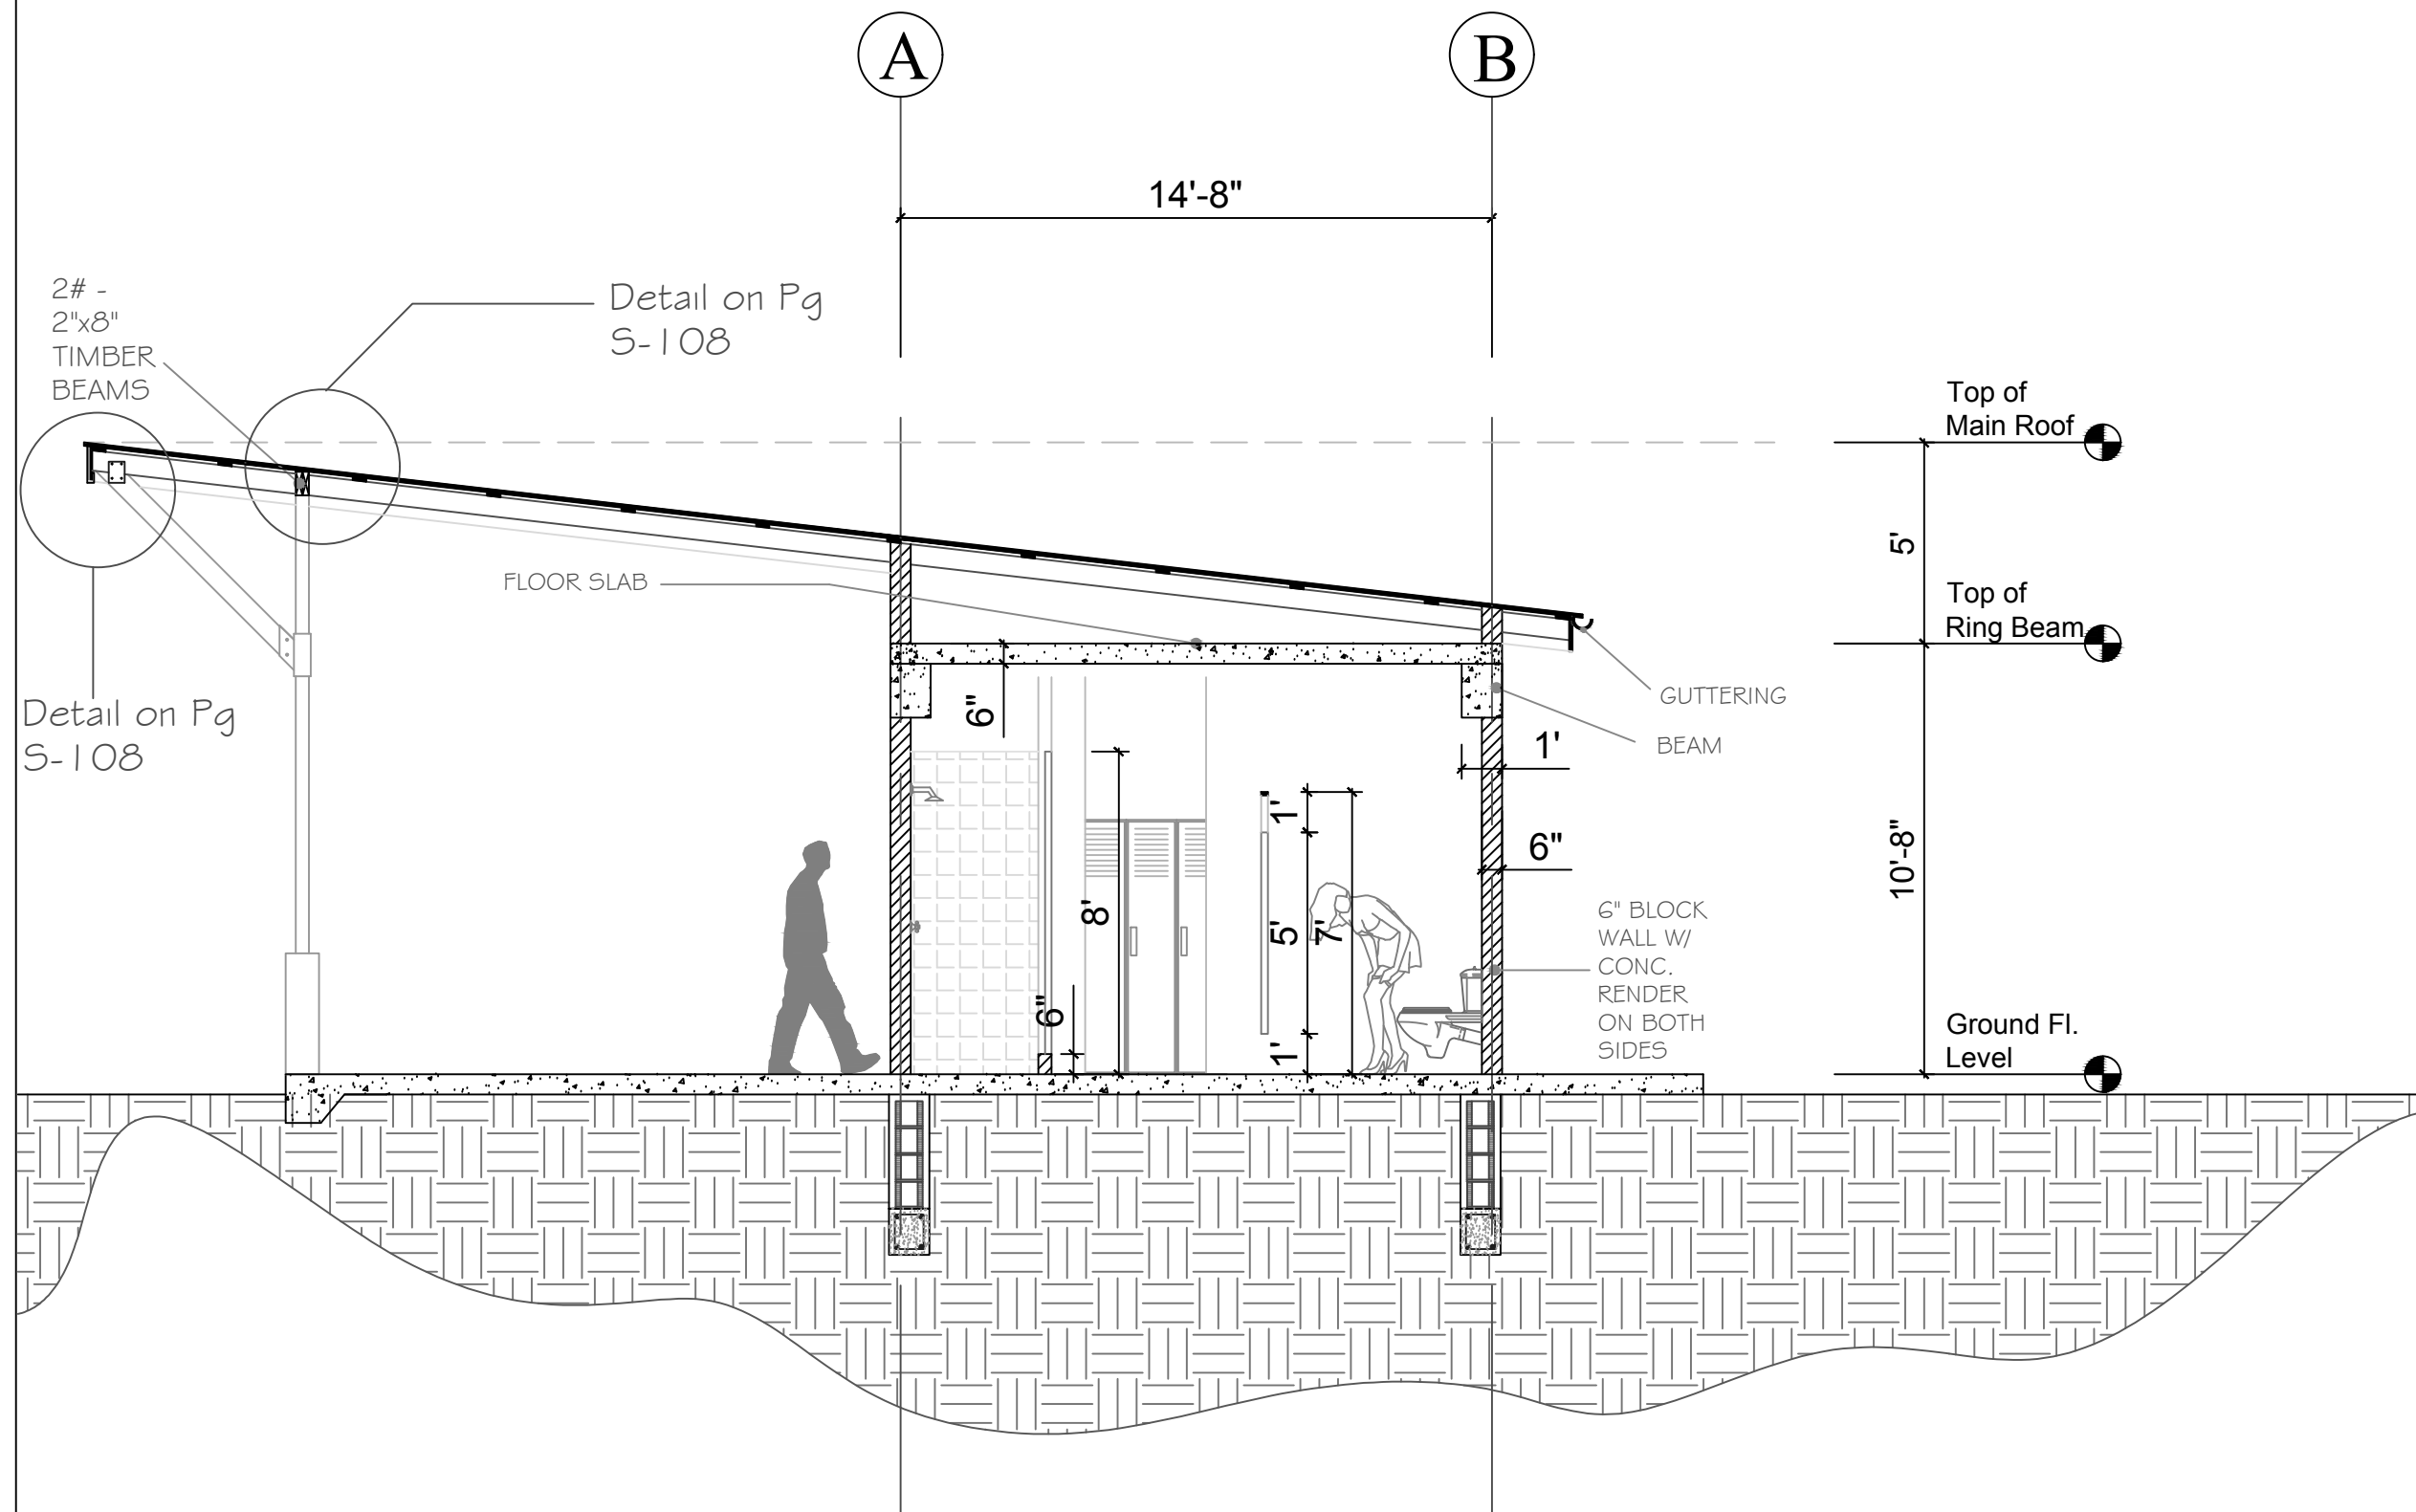

SECTION Y-Y

General Notes

- WALLS OF SHOWER STALLS ARE TILED 8' HIGH; WHILE TOILET STALLS ARE TILED 4' HIGH - USING 12"x12" CERAMIC WALL TILES.

MATERIALS:

	CON. BLOCK WALL
	CONCRETE
	EARTH

No.	Revision/Issue	Date

Firm Name and Address


DIVISION OF SPORT & YOUTH AFFAIRS
JANIS SOLOMON BLDG
28 ORANGE HILL RD
SCARBOROUGH, TOBAGO

DRAWN BY:
CHECKED BY:


Project Name and Address

CHANGE ROOM & TOILET FACILITY


Drawing: SECTION Y-Y	Sheet
Date 1/7/2020	A-302
Scale 1/2" = 1' 0"	

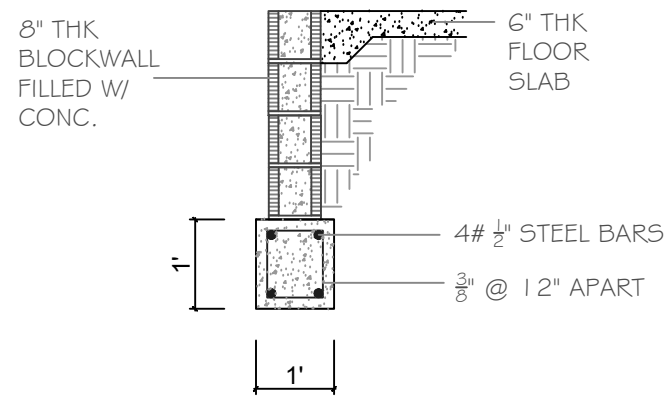


GROUND BEAM DETAIL (SECTION A-A)

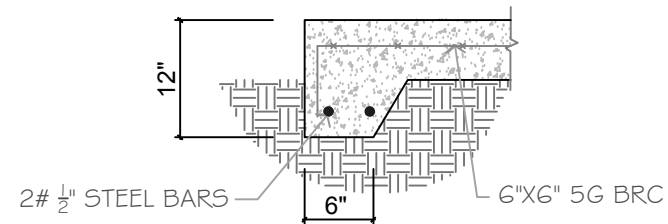

THICKENED EDGE DETAIL (SECTION B-B)
SCALE: NTS

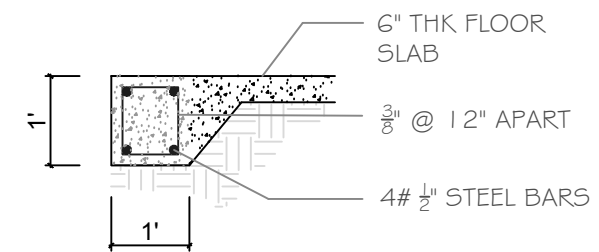

ADDITIONAL GROUND BEAM DETAIL (SECTION C-C)
SCALE: NTS

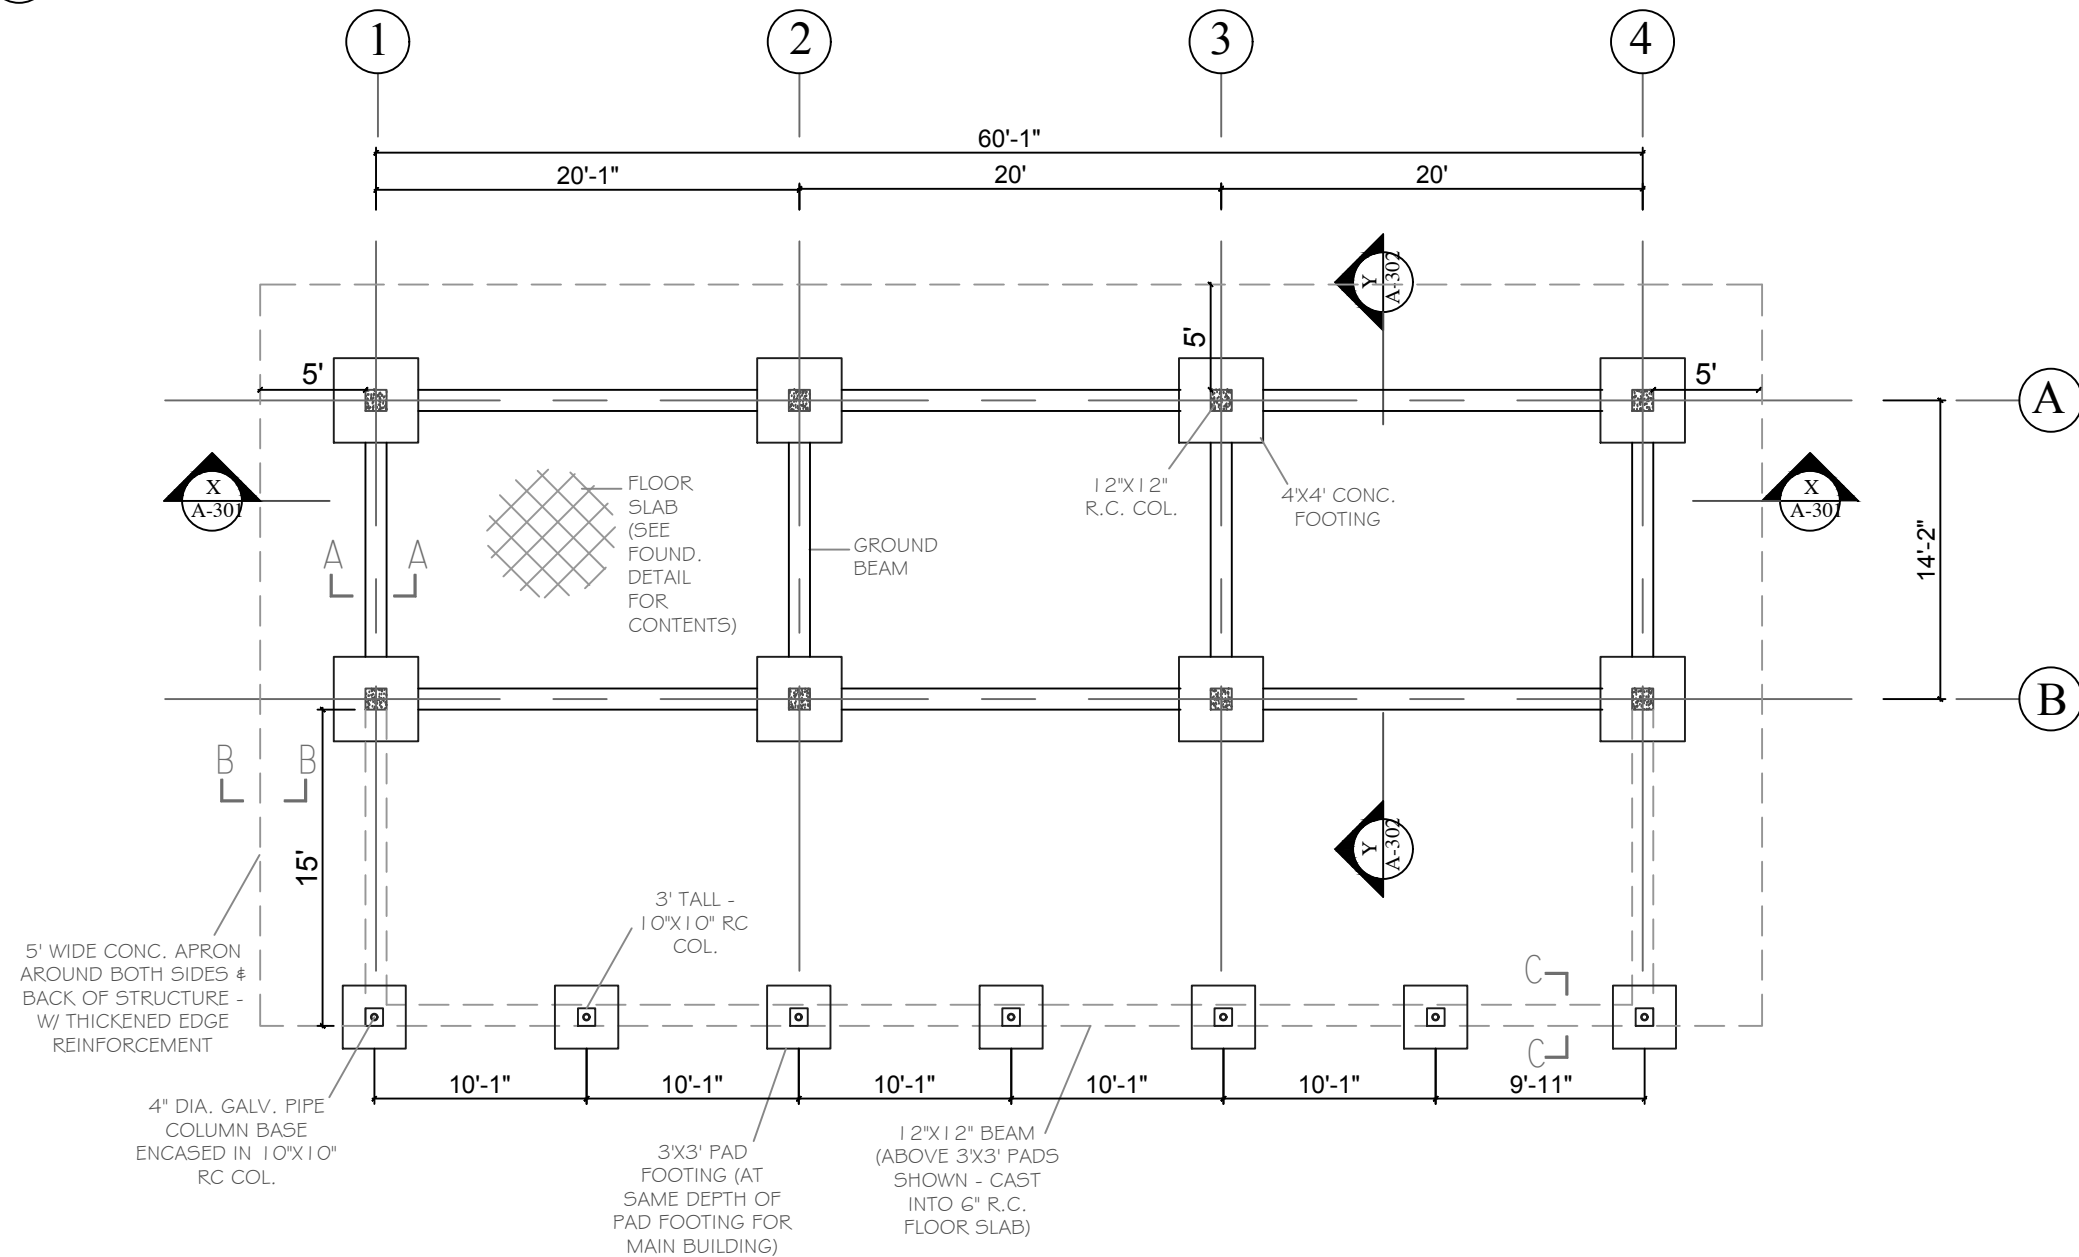

FOUNDATION PLAN

General Notes

- ALL MAIN COLUMNS MEASURE 12"x12"
- ALL MAIN PAD FOOTINGS ARE 4'x4', WHILE SECONDARY ONES AT THE FRONT ARE 3'X3' AS ILLUSTRATED.
- ALL GROUND BEAMS ARE 12"x12"

No.	Revision/Issue	Date

Firm Name and Address

DIVISION OF SPORT & YOUTH AFFAIRS
JANIS SOLOMON BLDG
28 ORANGE HILL RD
SCARBOROUGH, TOBAGO

DRAWN BY:
CHECKED BY:

Project Name and Address

CHANGE ROOM & TOILET FACILITY

Drawing


FOUNDATION LAYOUT

Date 12/20/2019


Scale 1/4" = 1' 0"

Sheet


S-101

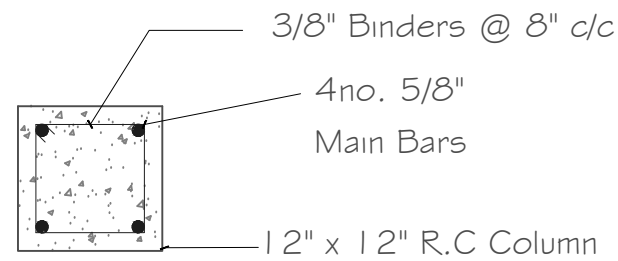


SECTION K-K

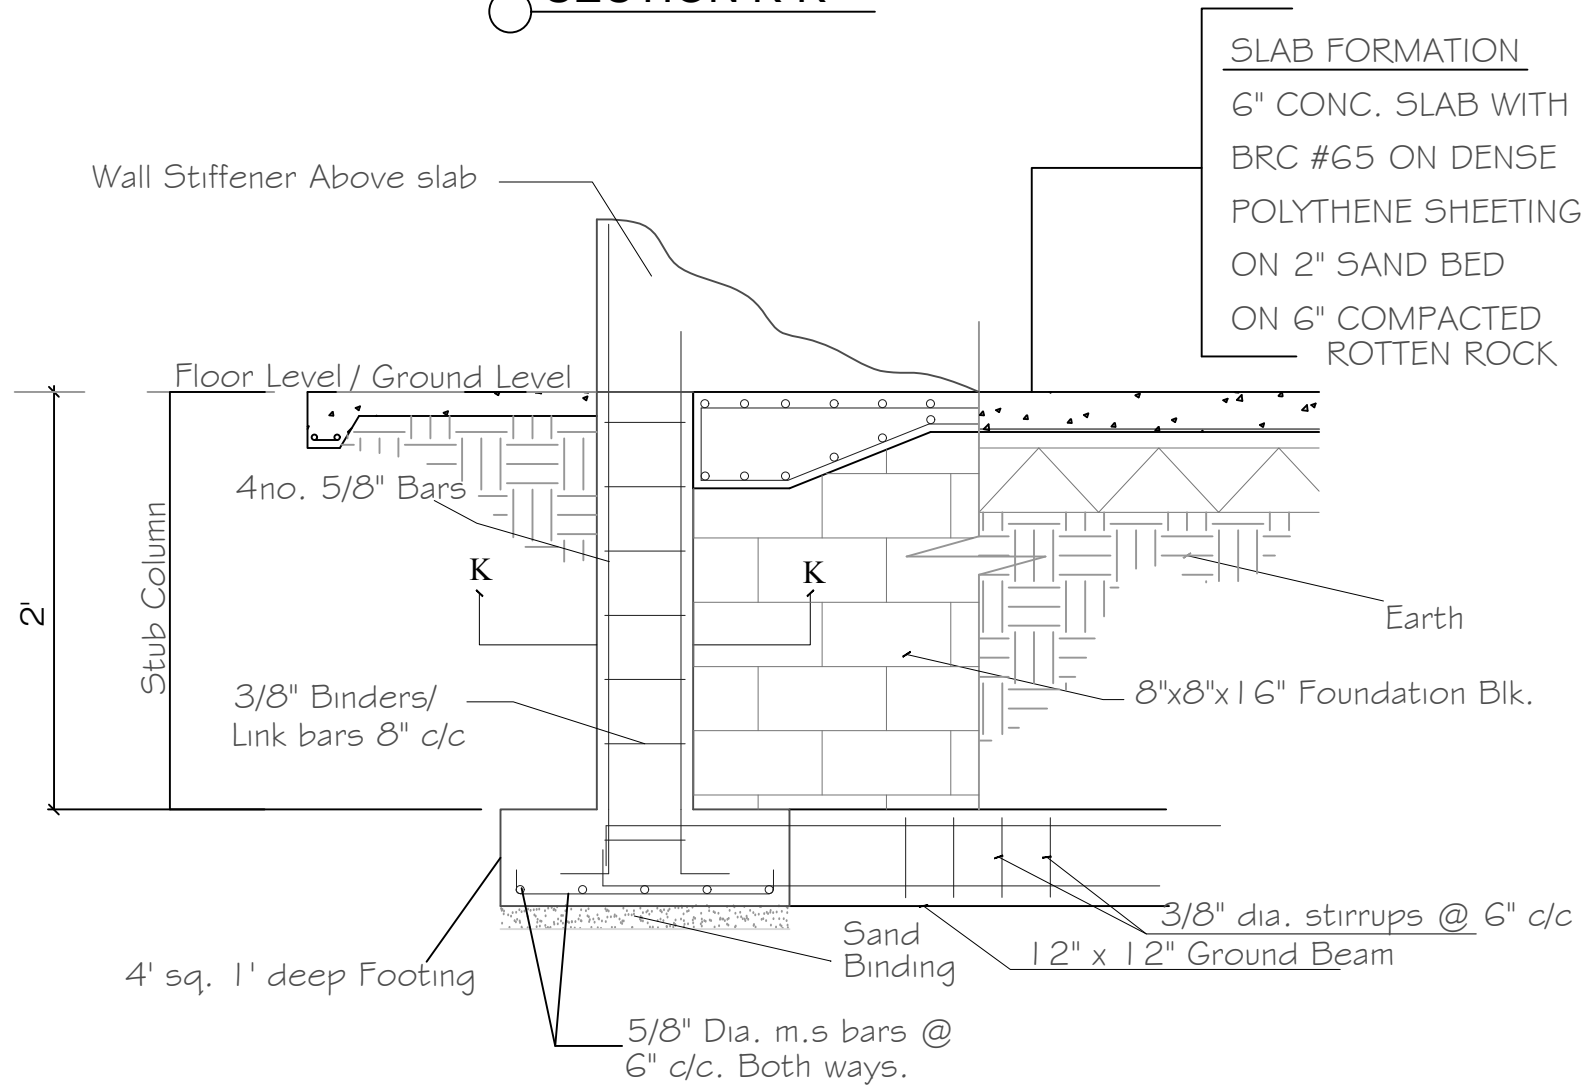

COLUMN & PAD FOOTING DETAIL

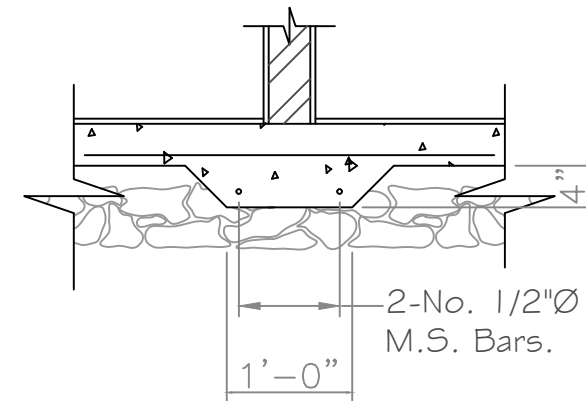

INTERNAL WALL FOUNDATION

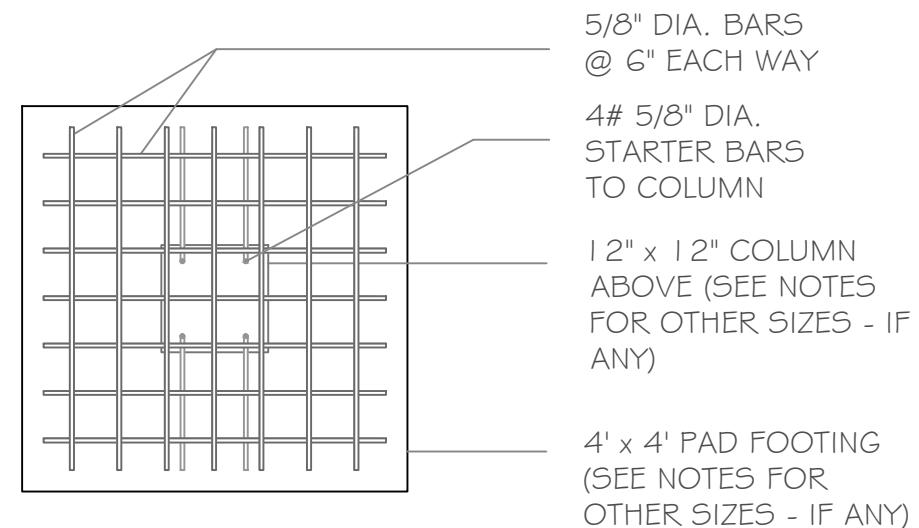

General Notes


No.	Revision/Issue	Date

Firm Name and Address
DIVISION OF SPORT & YOUTH AFFAIRS
JANIS SOLOMON BLDG
28 ORANGE HILL RD
SCARBOROUGH, TOBAGO
DRAWN BY:
CHECKED BY:

Project Name and Address
CHANGE ROOM & TOILET FACILITY

Drawing:	Sheet
FOUNDATION DETAILS	S-102
Date	12/20/2019
Scale	N/A

1/15/2004

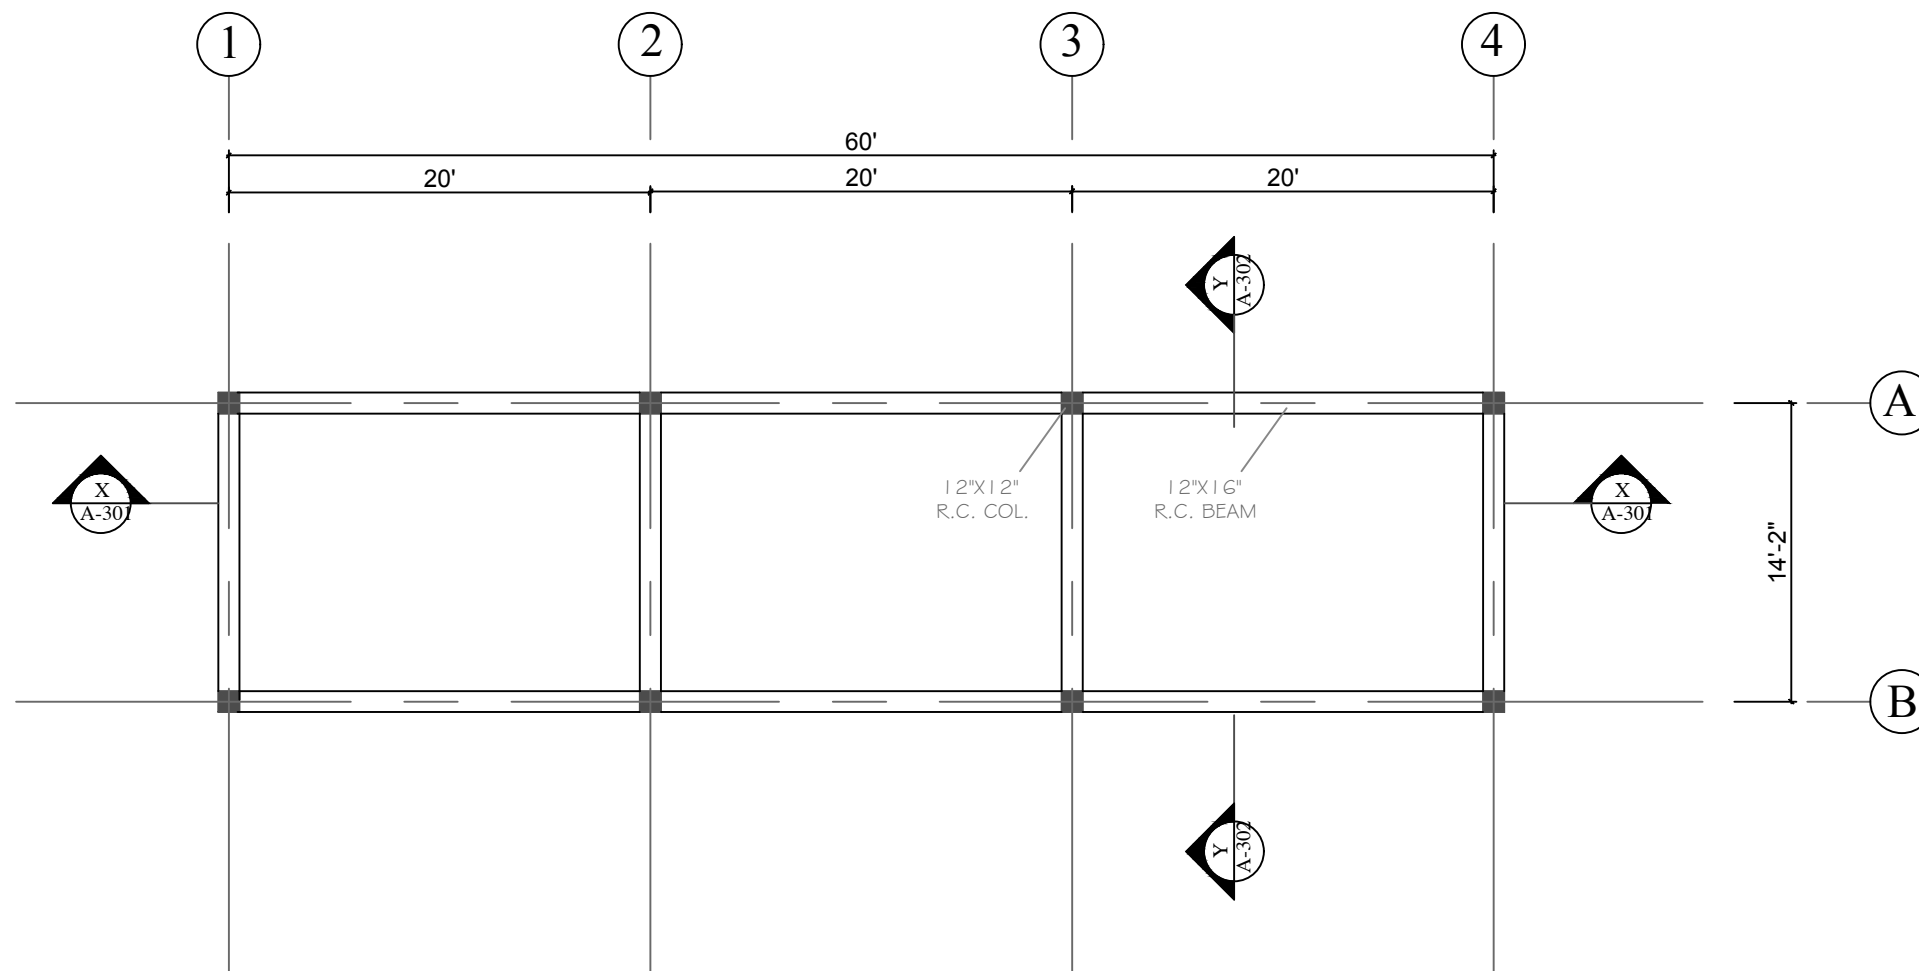

 **BEAM LAYOUT**

General Notes

- ALL BEAMS (INCLUDING RING BEAM) MEASURE 12"x16"

No.	Revision/Issue	Date

Firm Name and Address


DIVISION OF SPORT & YOUTH AFFAIRS
JANIS SOLOMON BLDG
28 ORANGE HILL RD
SCARBOROUGH, TOBAGO
DRAWN BY:
CHECKED BY:

Project Name and Address

CHANGE ROOM & TOILET FACILITY

Drawing: BEAM LAYOUT	Sheet
Date 12/20/2019	S-104
Scale 1/4" = 1' 0"	

1/15/2004

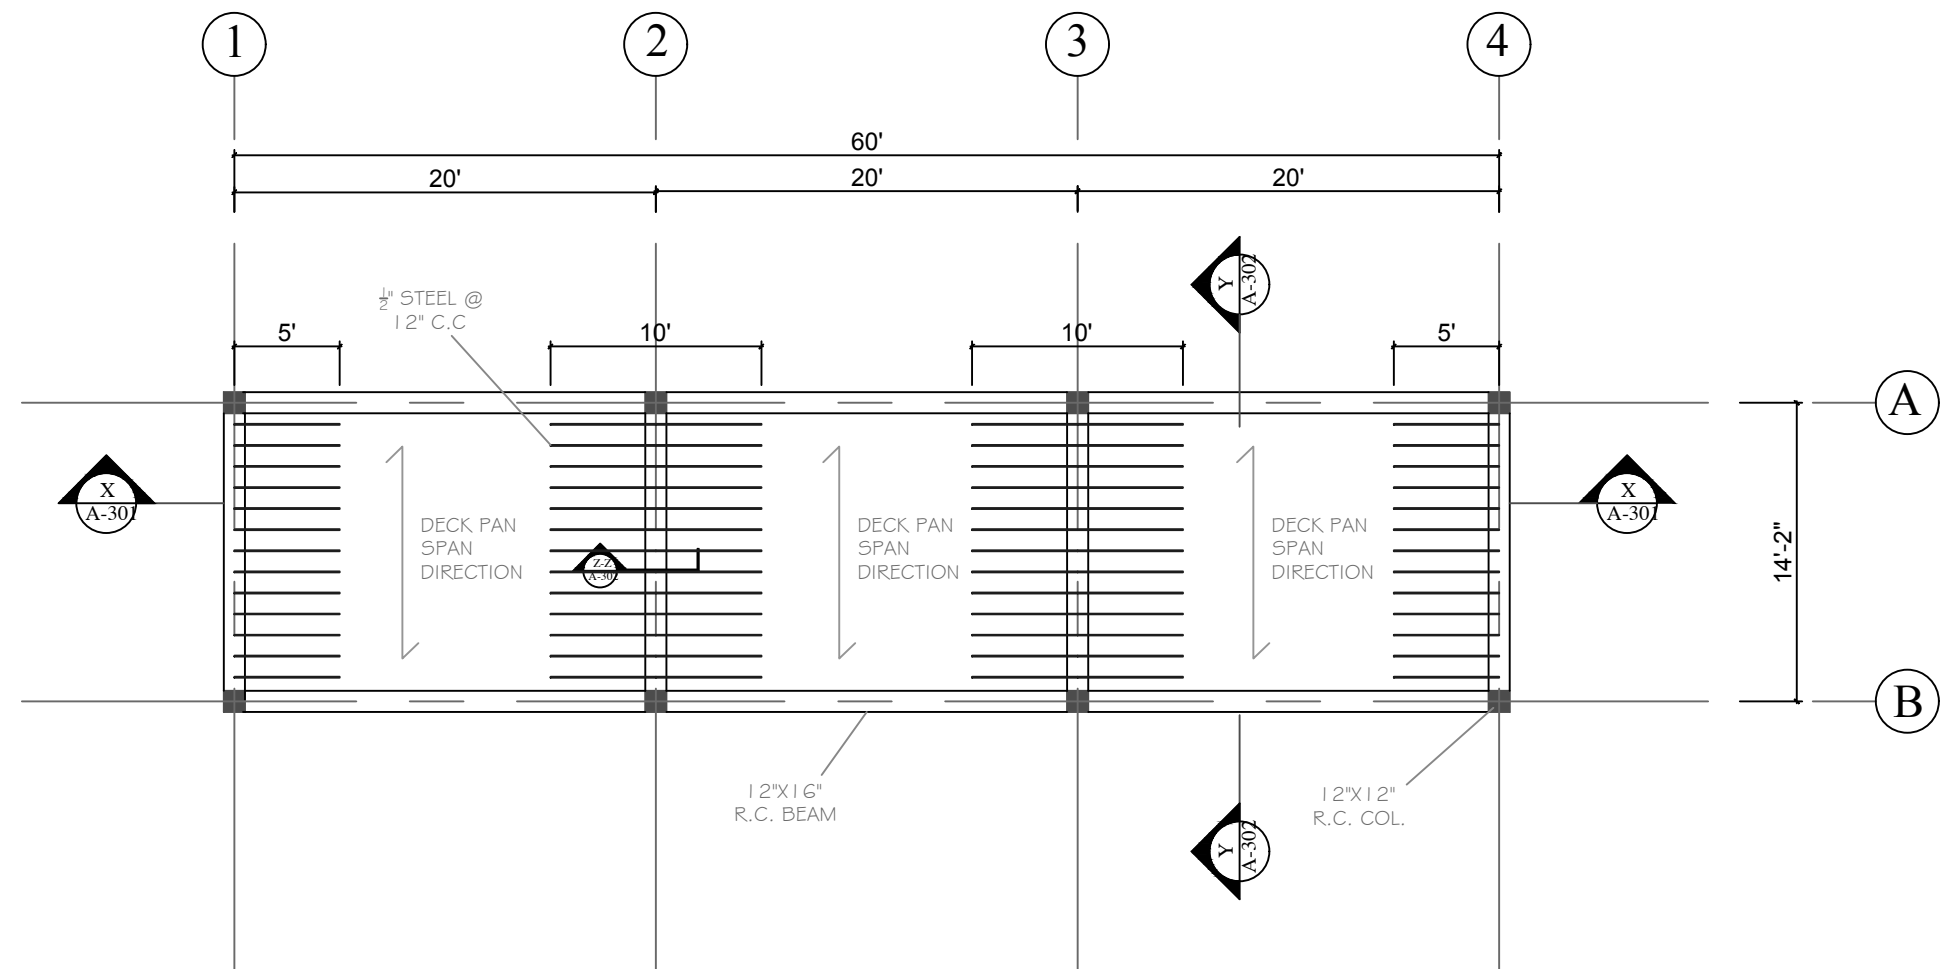

DECK REINFORCEMENT LAYOUT - A

General Notes

- ALL BEAMS (INCLUDING RING BEAM) MEASURE 12"x16"

No.	Revision/Issue	Date


Firm Name and Address
DIVISION OF SPORT & YOUTH AFFAIRS
JANIS SOLOMON BLDG
28 ORANGE HILL RD
SCARBOROUGH, TOBAGO
DRAWN BY:
CHECKED BY:

Project Name and Address
CHANGE ROOM & TOILET FACILITY

Drawing:	Sheet
DECK REINF.	S-105
Date	
Scale	

12/20/2019
1/4" = 1' 0"

1/15/2004

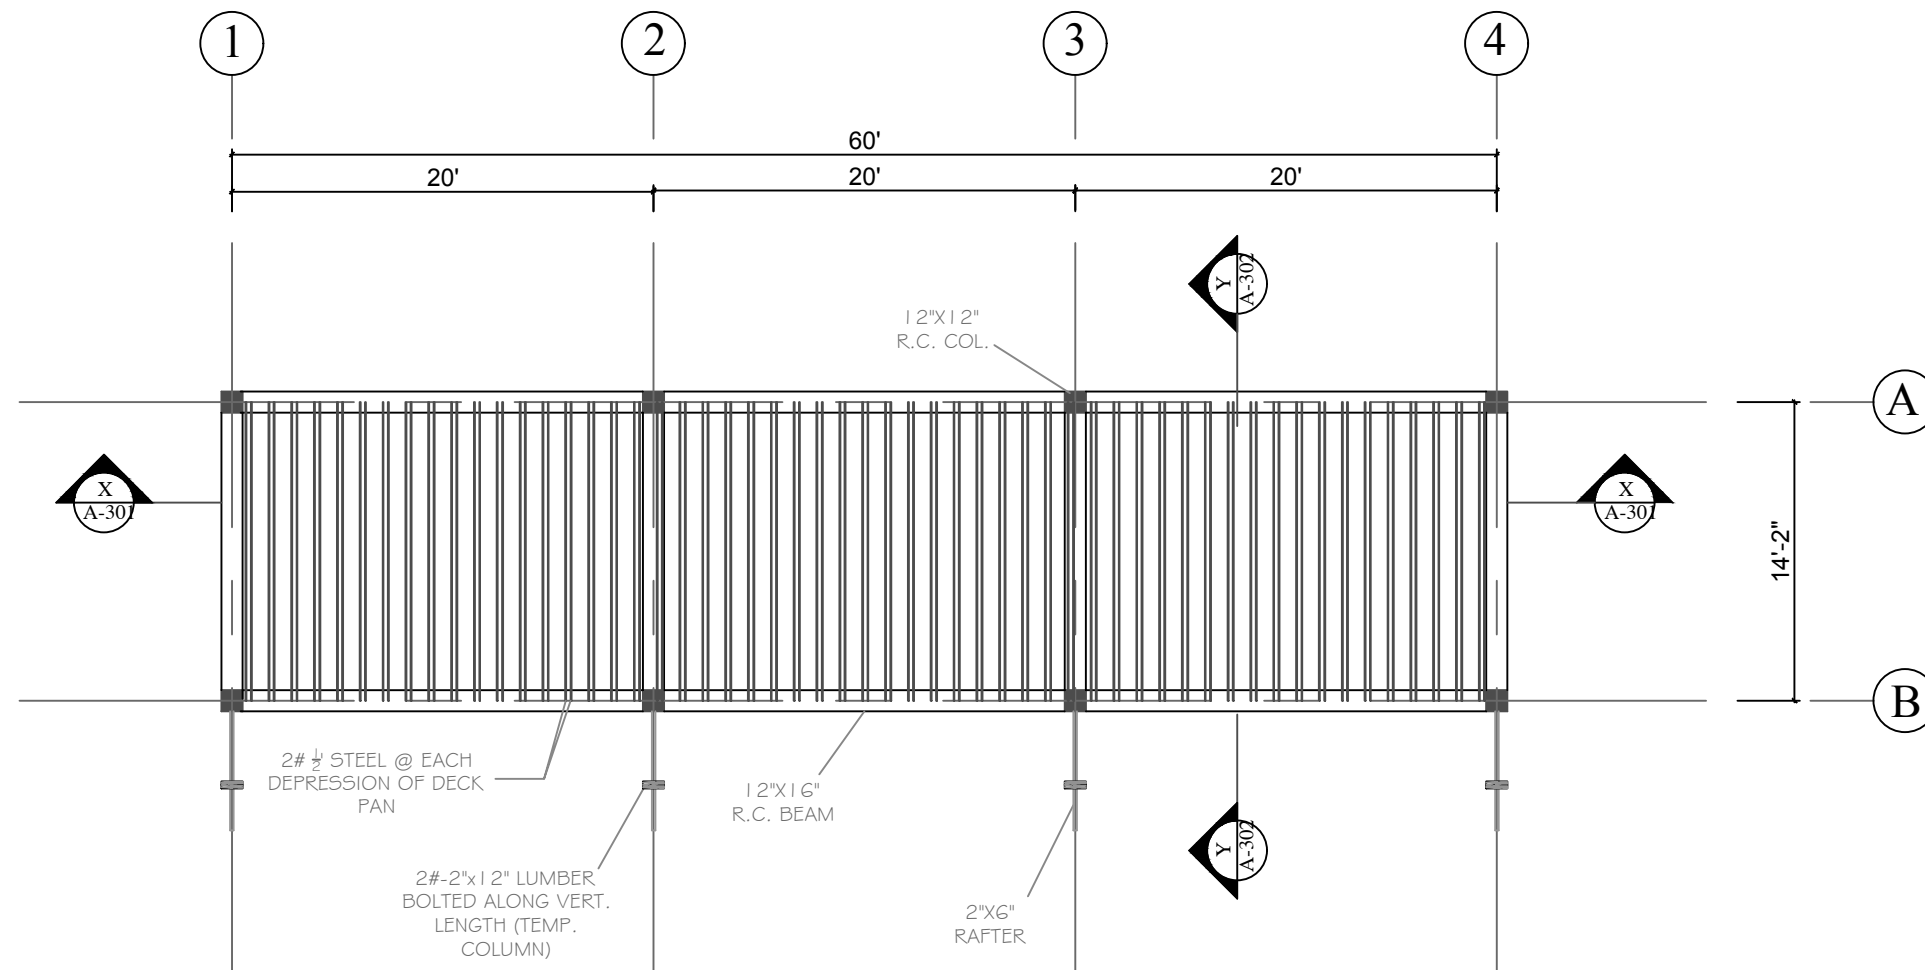

DECK REINFORCEMENT LAYOUT - B

General Notes

- ALL BEAMS (INCLUDING RING BEAM) MEASURE 12"x16"

No.	Revision/Issue	Date


Firm Name and Address
DIVISION OF SPORT & YOUTH AFFAIRS
JANIS SOLOMON BLDG
28 ORANGE HILL RD
SCARBOROUGH, TOBAGO
DRAWN BY:
CHECKED BY:

Project Name and Address
CHANGE ROOM & TOILET FACILITY

Drawing:	Sheet
DECK REINF.	S-106
Date	12/20/2019
Scale	1/4" = 1' 0"

1/15/2004

ROOF FRAMING PLAN

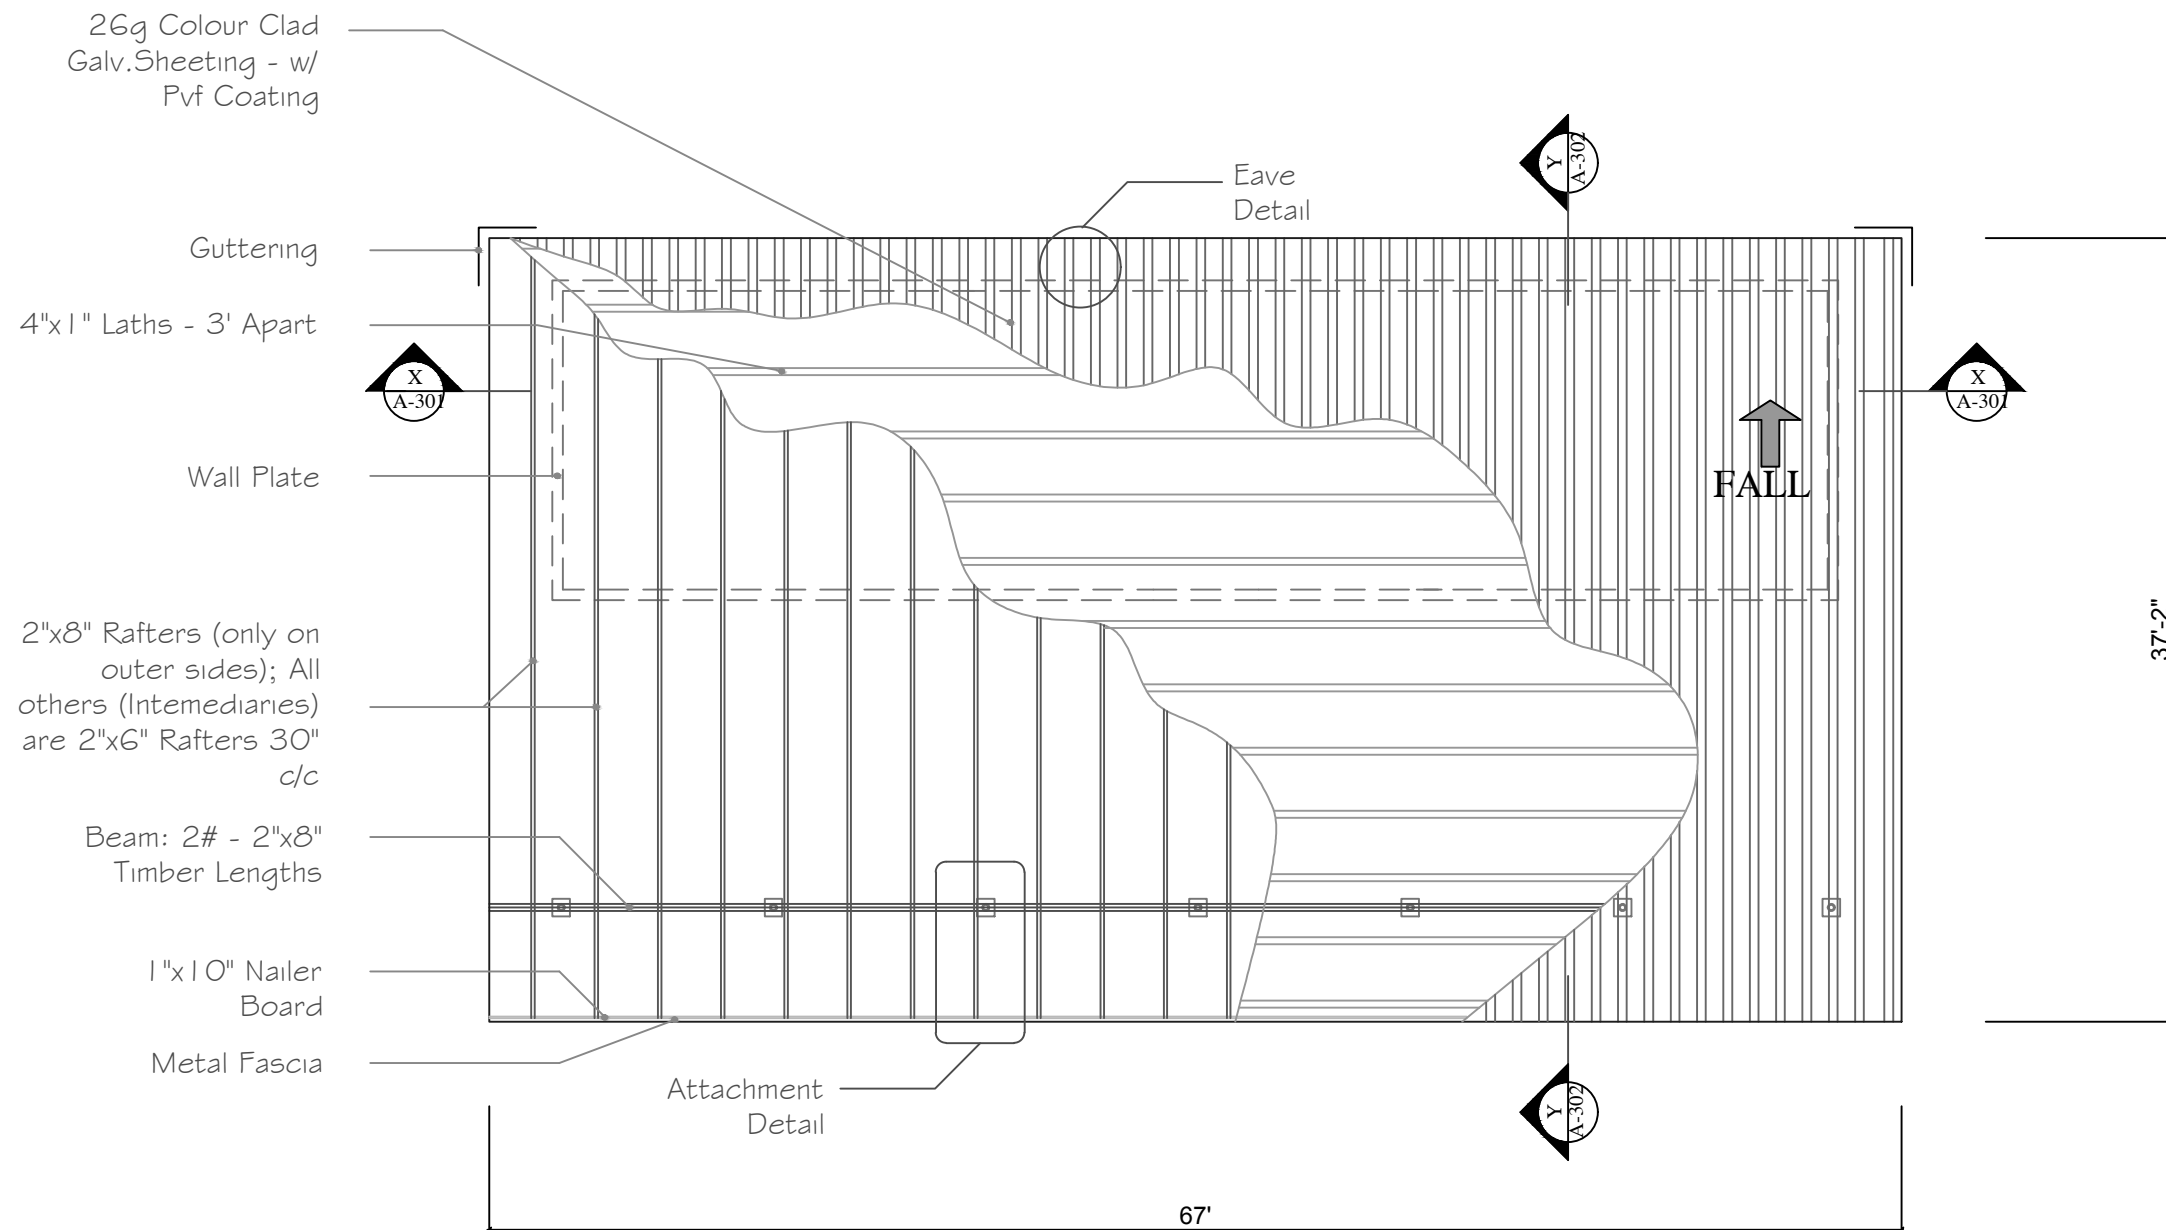

General Notes

- EAVES ARE 2' OFF OF EXTERIOR FACADE AT BACK AND SIDES OF BUILDING.

No.	Revision/Issue	Date

Firm Name and Address

DIVISION OF SPORT & YOUTH AFFAIRS
JANIS SOLOMON BLDG
28 ORANGE HILL RD
SCARBOROUGH, TOBAGO

DRAWN BY:
CHECKED BY:

Project Name and Address

CHANGE ROOM & TOILET FACILITY

Drawing: ROOF FRAMING PLAN


Date: 1/7/2020

Scale: 1/4" = 1' 0"


Sheet

S-107

1/15/2004

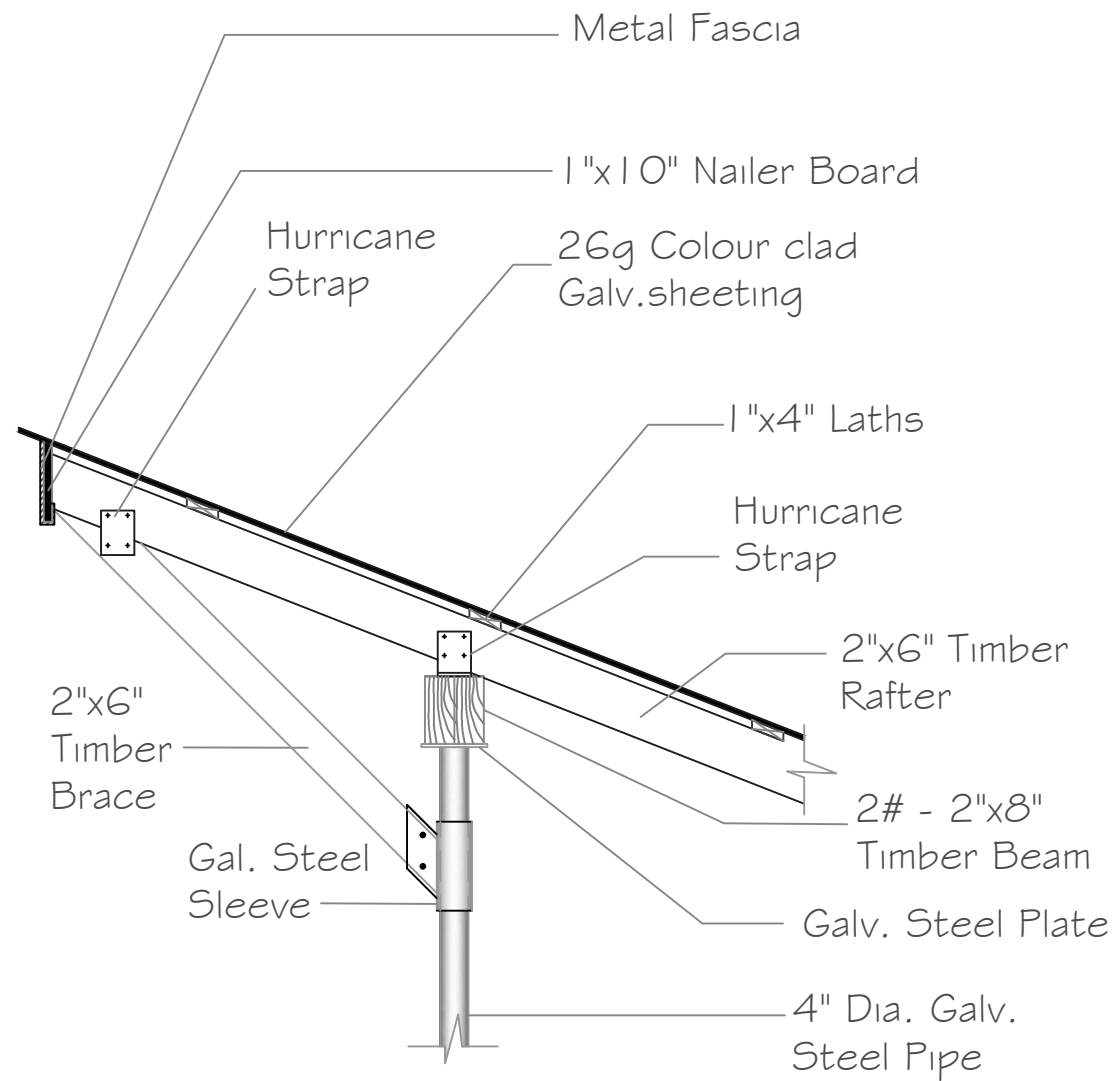

○ **ATTACHMENT DETAIL
(FRONT OF PAVILION)**

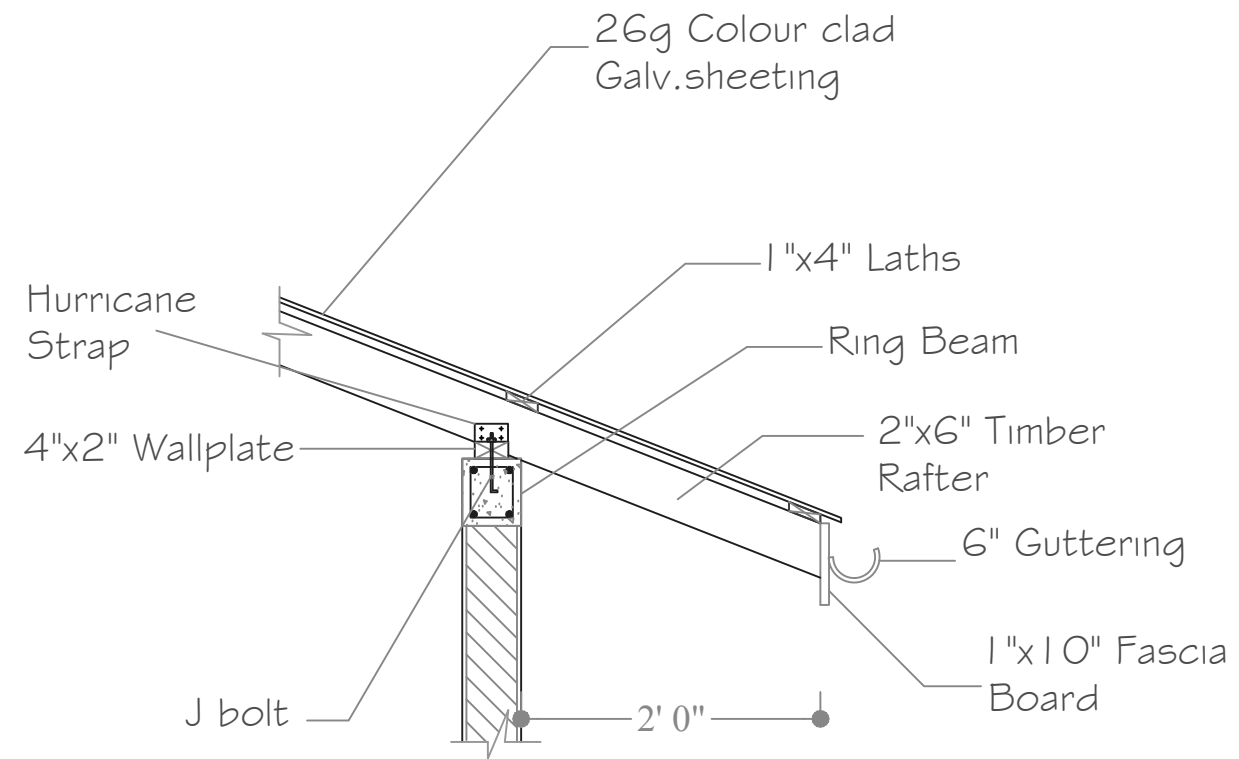

○ **EAVE DETAIL
(BACK OF PAVILION)**

○ **ROOF DETAILS**

General Notes


No.	Revision/Issue	Date

Firm Name and Address
DIVISION OF SPORT & YOUTH AFFAIRS
JANIS SOLOMON BLDG
28 ORANGE HILL RD
SCARBOROUGH, TOBAGO
DRAWN BY:
CHECKED BY:

Project Name and Address
CHANGE ROOM & TOILET FACILITY

Drawing: ROOF DETAILS	Sheet
Date 1/7/2020	S-108
Scale 1" = 1' 0"	

1/15/2004

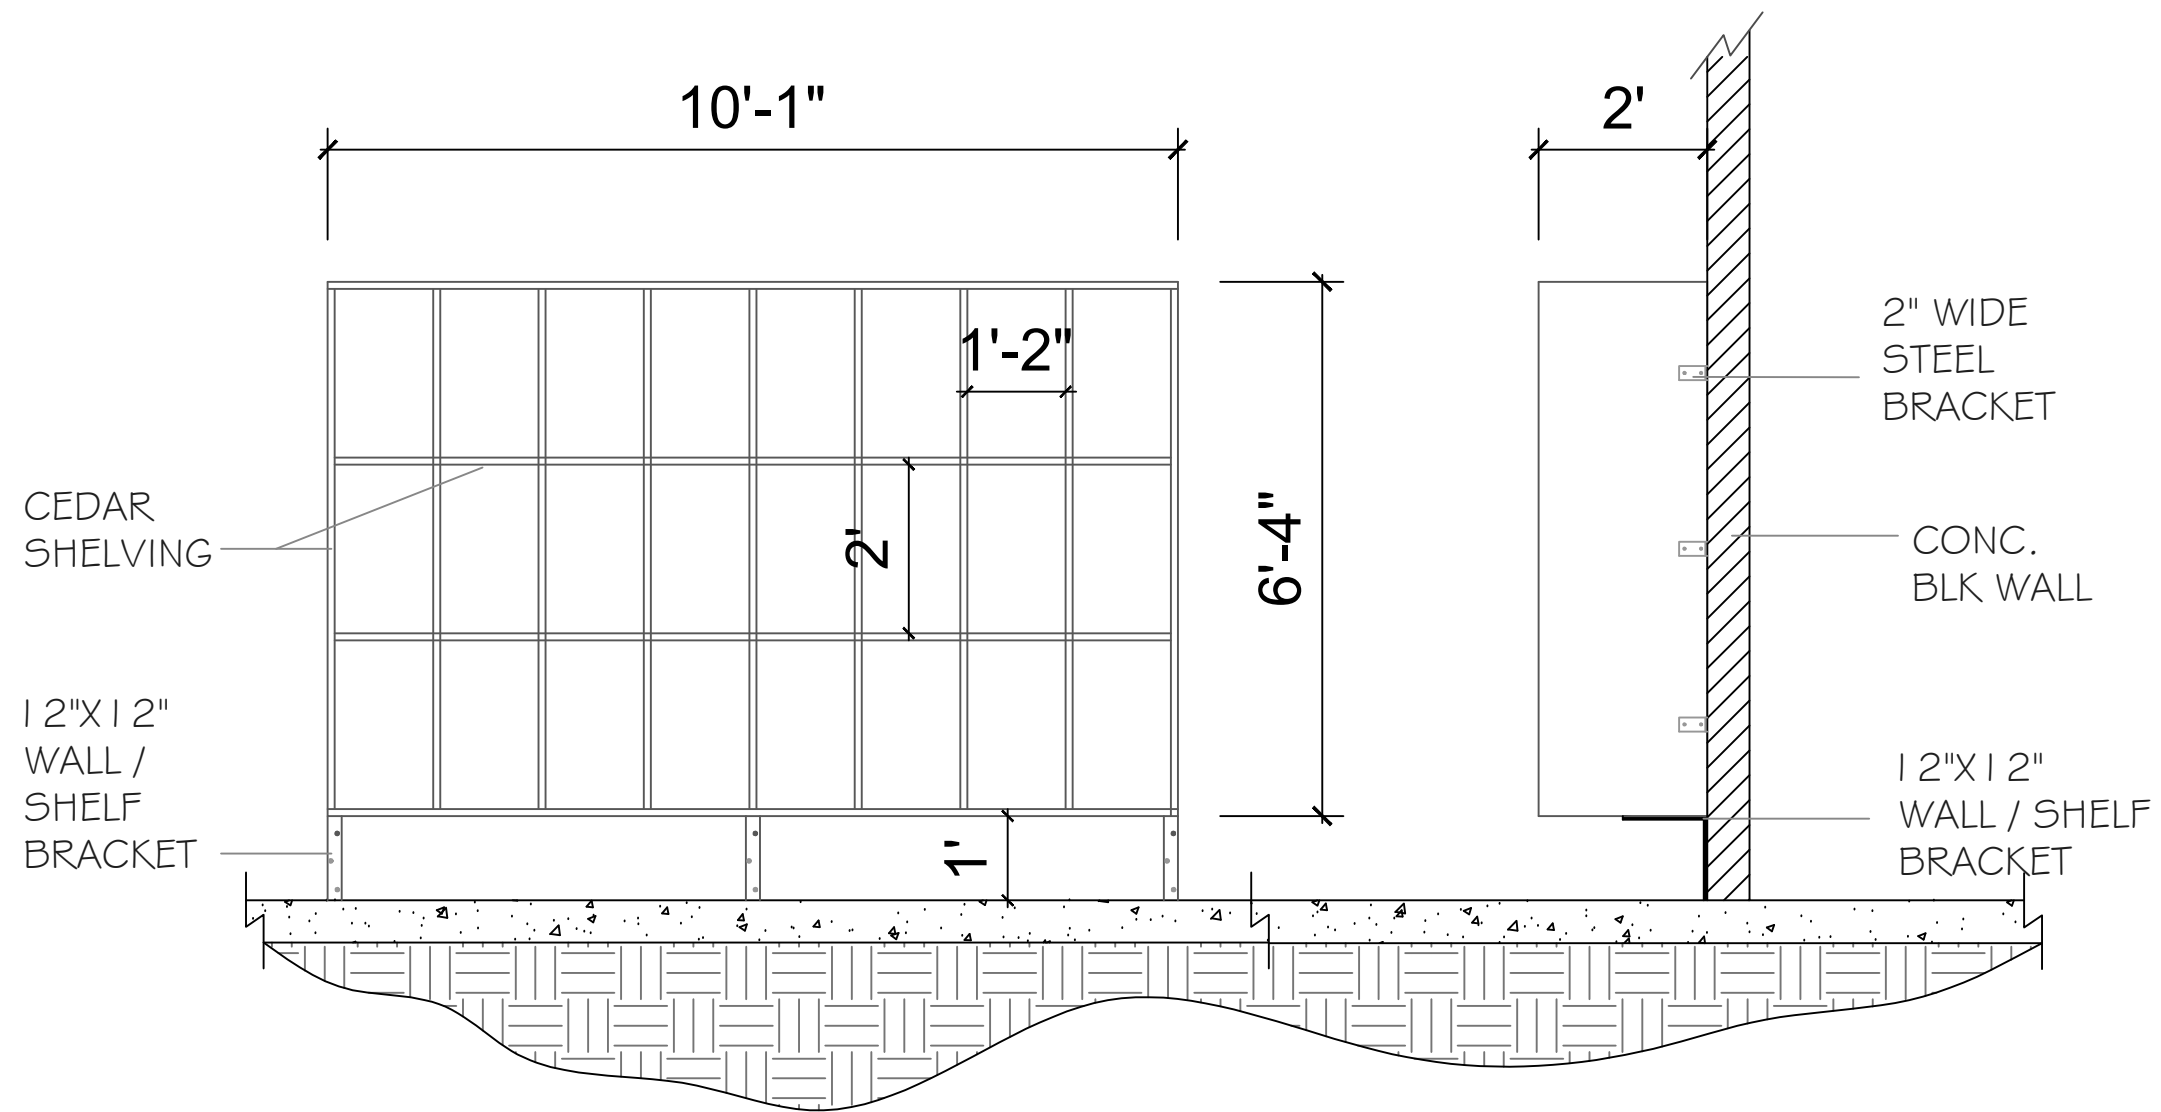

LOCKERS / SHELVING

General Notes

- SHELVING IS TO BE CONSTRUCTED FROM 1" THICK CEDAR; MOUNTED 0 WALL AND ELEVATED 1' OFF OF THE FLOOR.

No.	Revision/Issue	Date

Firm Name and Address

DIVISION OF SPORT & YOUTH AFFAIRS
JANIS SOLOMON BLDG
28 ORANGE HILL RD
SCARBOROUGH, TOBAGO

DRAWN BY:
CHECKED BY:

Project Name and Address

CHANGE ROOM & TOILET FACILITY

Drawing:
BENCH & SHELVING


Date
12/20/2019

Scale
3/4" = 1' 0"

Sheet

A-501

1/15/2004

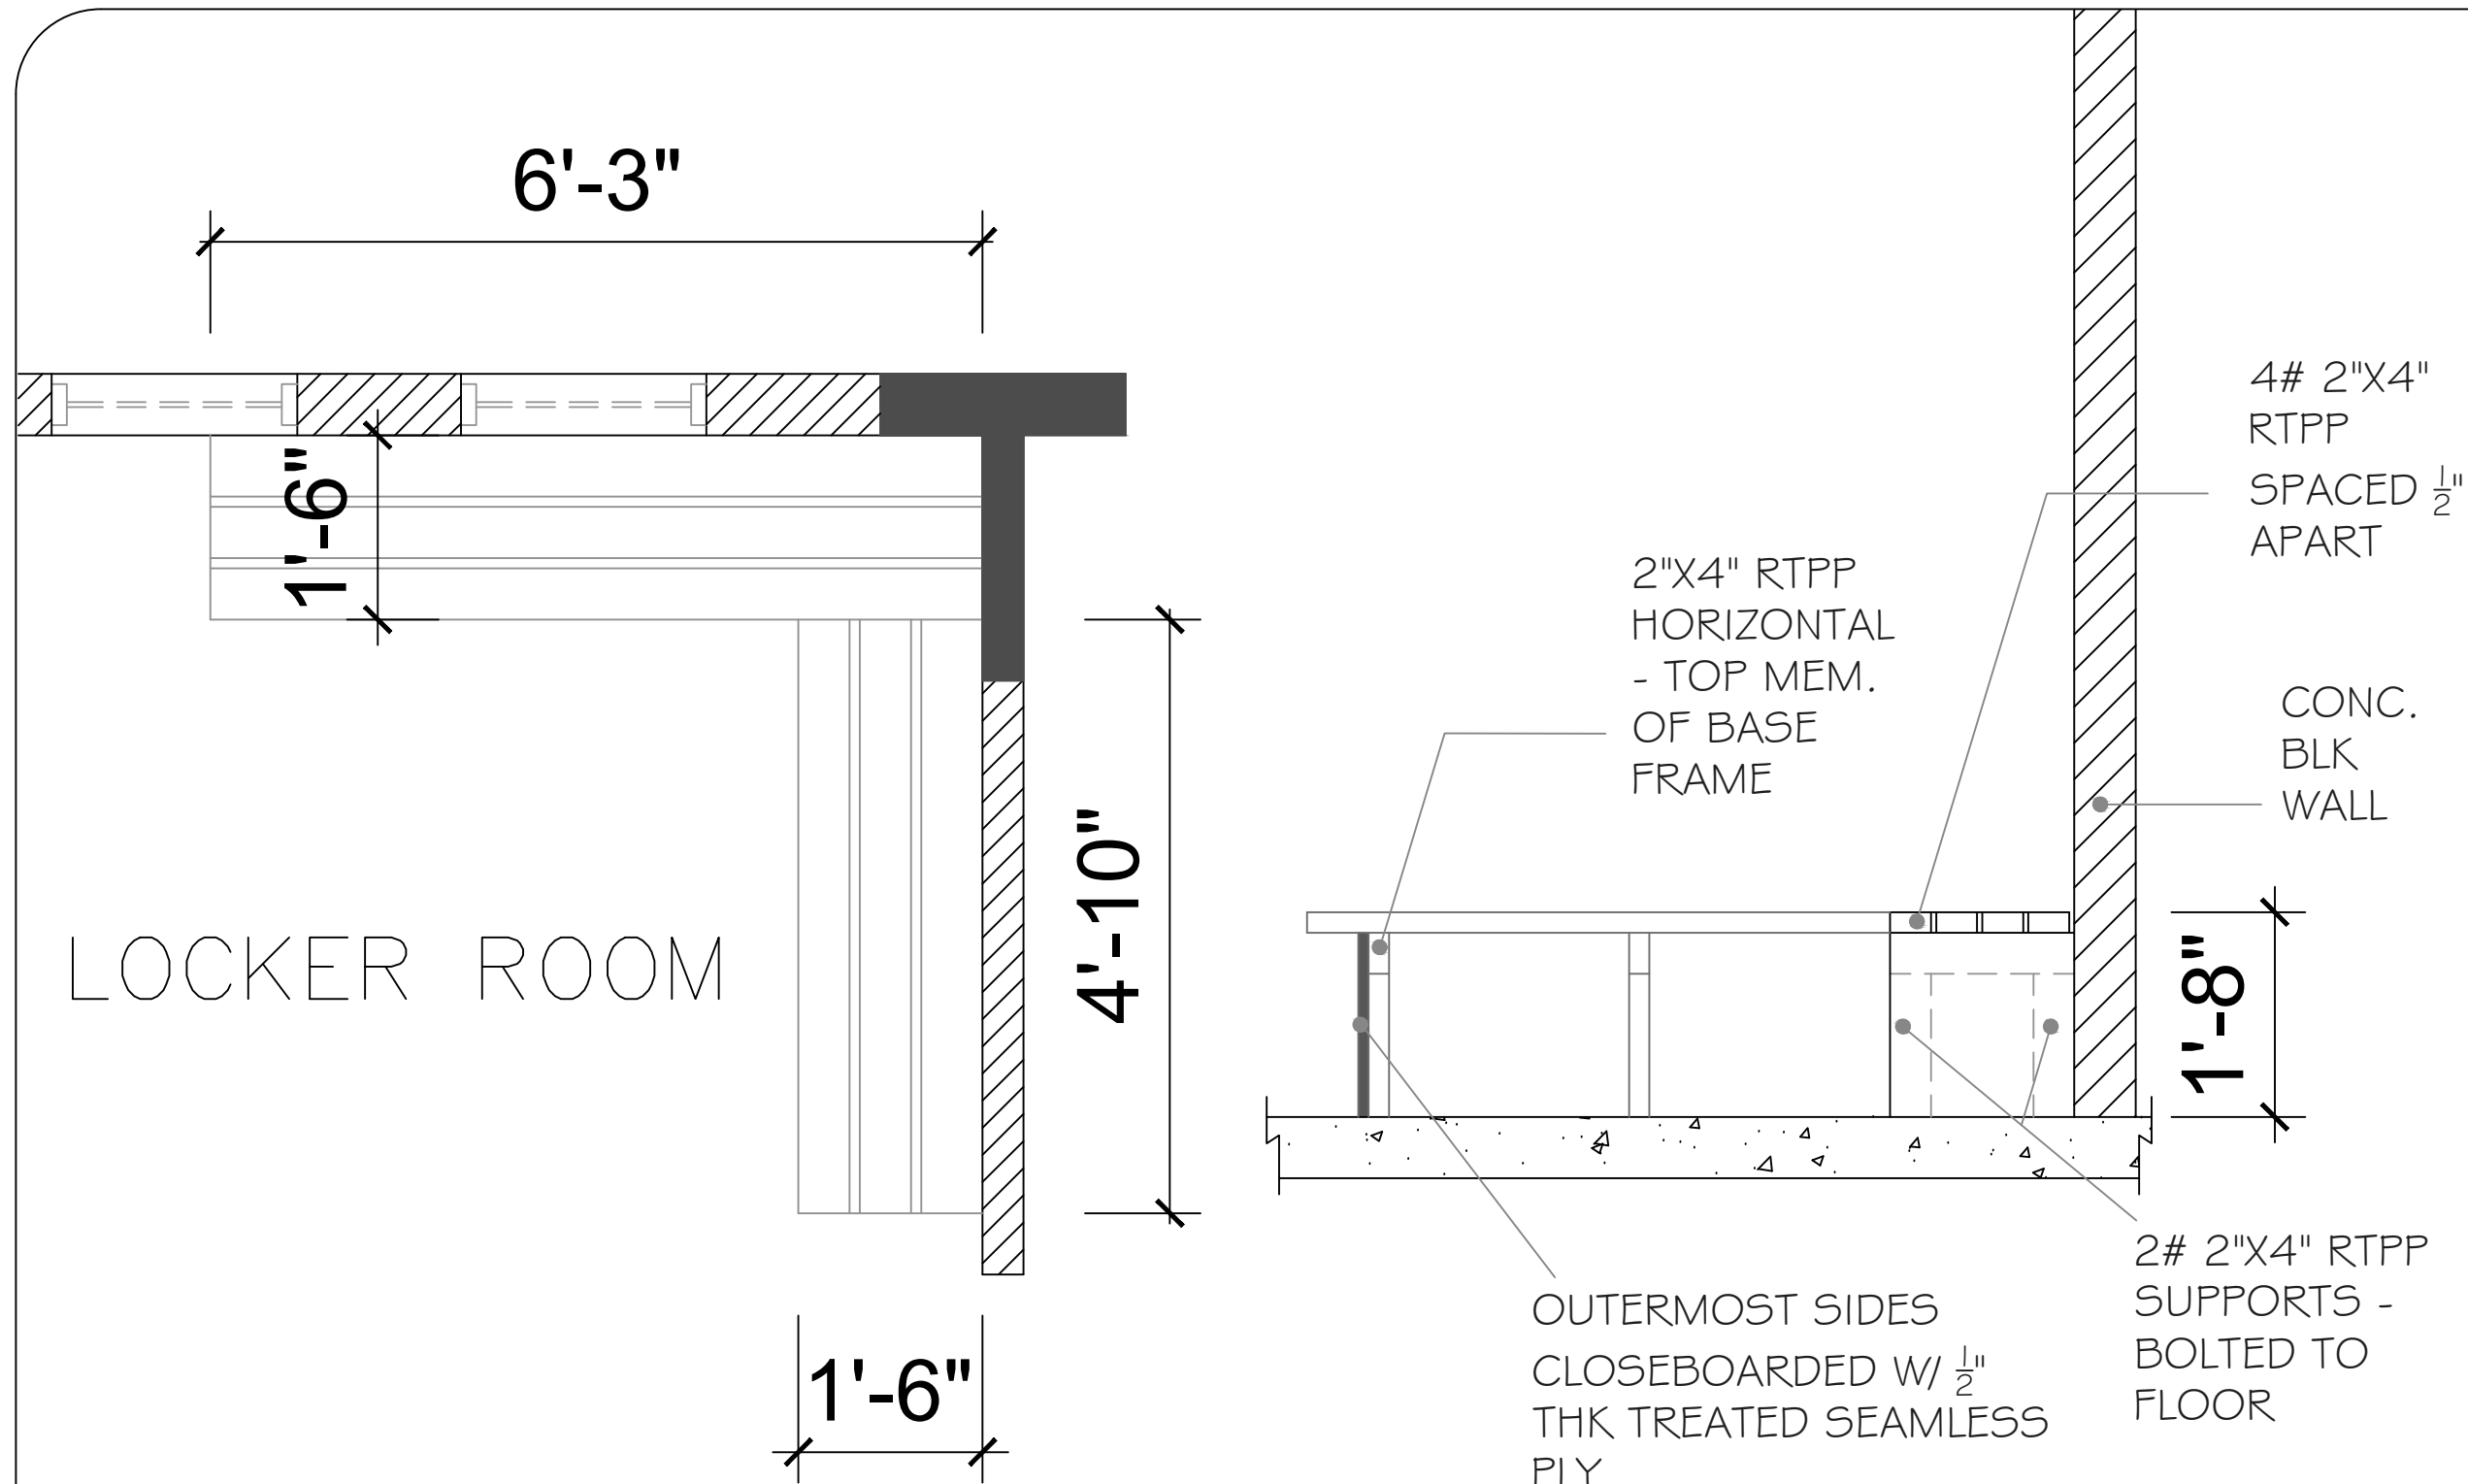

BENCH ASSEMBLY DWGS

General Notes



No.	Revision/Issue	Date

Firm Name and Address
DIVISION OF SPORT & YOUTH AFFAIRS
JANIS SOLOMON BLDG
28 ORANGE HILL RD
SCARBOROUGH, TOBAGO
DRAWN BY:
CHECKED BY:

Project Name and Address
CHANGE ROOM & TOILET FACILITY

Drawing: BENCH DWG	Sheet A-502
Date 12/20/2019	
Scale 1 1/2" = 1' 0"	

1/15/2004

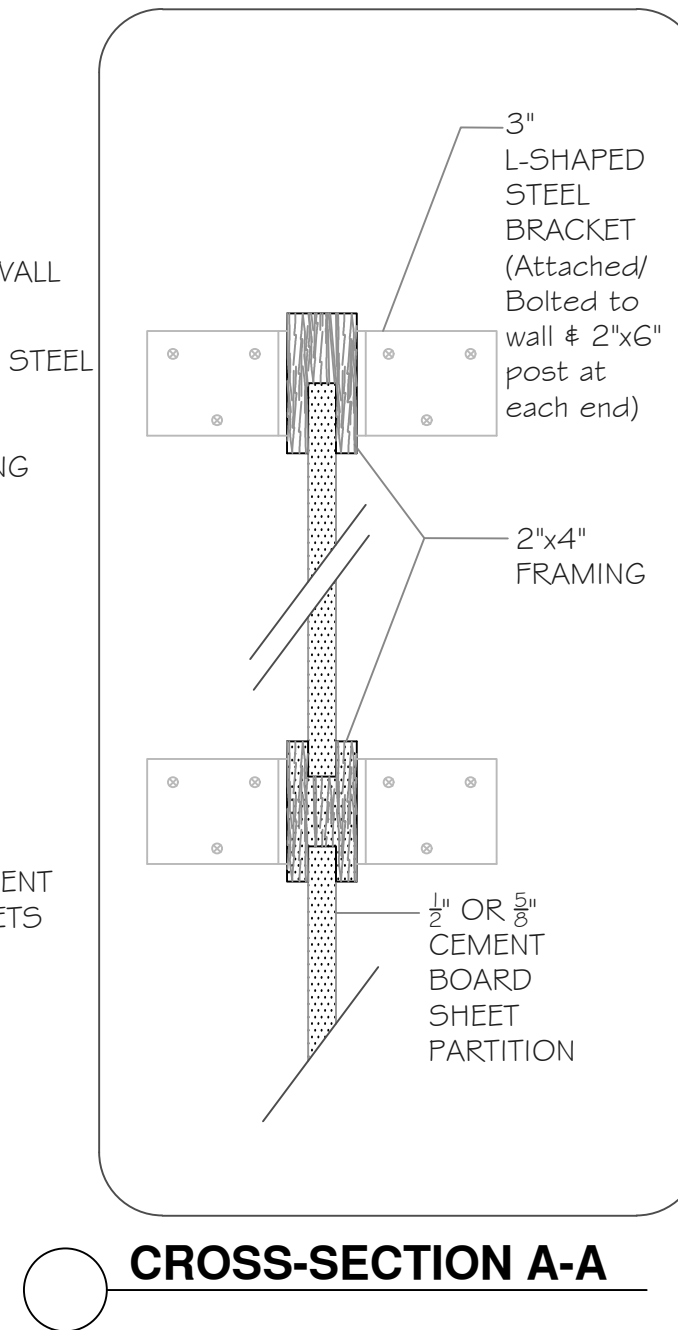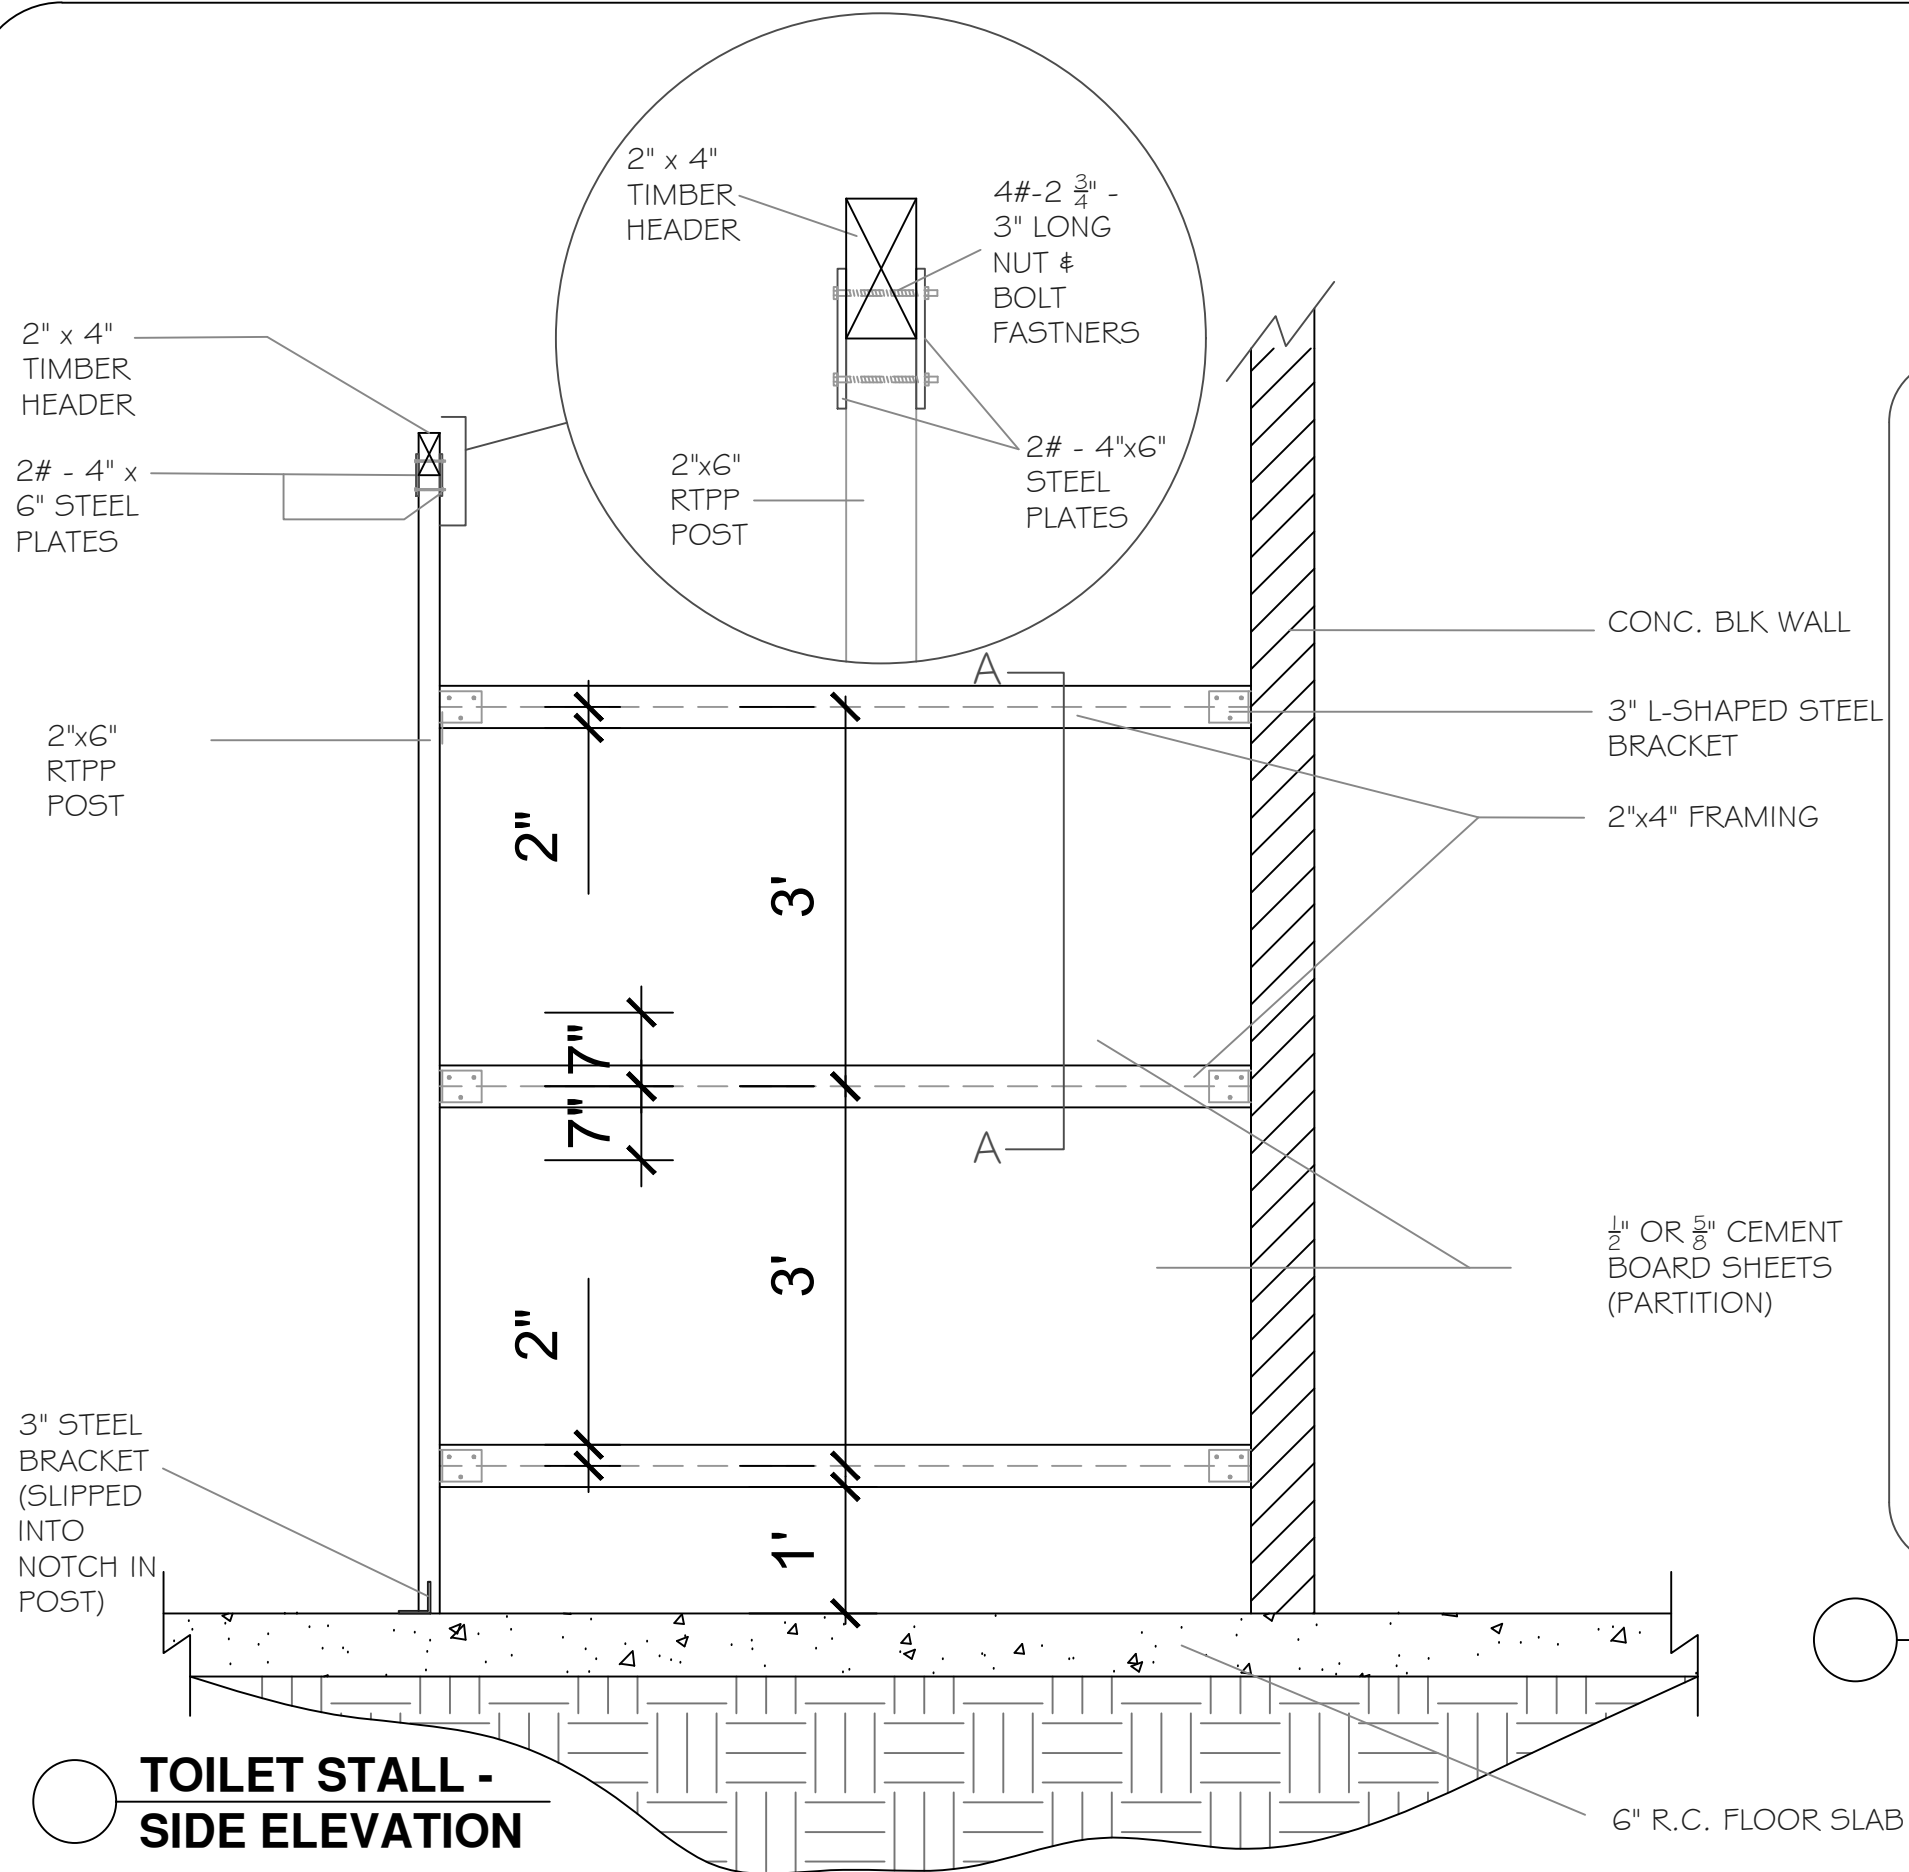

General Notes

No.	Revision/Issue	Date


Firm Name and Address
DIVISION OF SPORT & YOUTH AFFAIRS
JANIS SOLOMON BLDG
28 ORANGE HILL RD
SCARBOROUGH, TOBAGO
DRAWN BY:
CHECKED BY:

Project Name and Address
CHANGE ROOM & TOILET FACILITY

Drawing: PARTITION DETAIL 2
Date: 1/7/2020
Scale: 1 1/2" = 1' 0"

Sheet
A-602


1/15/2004

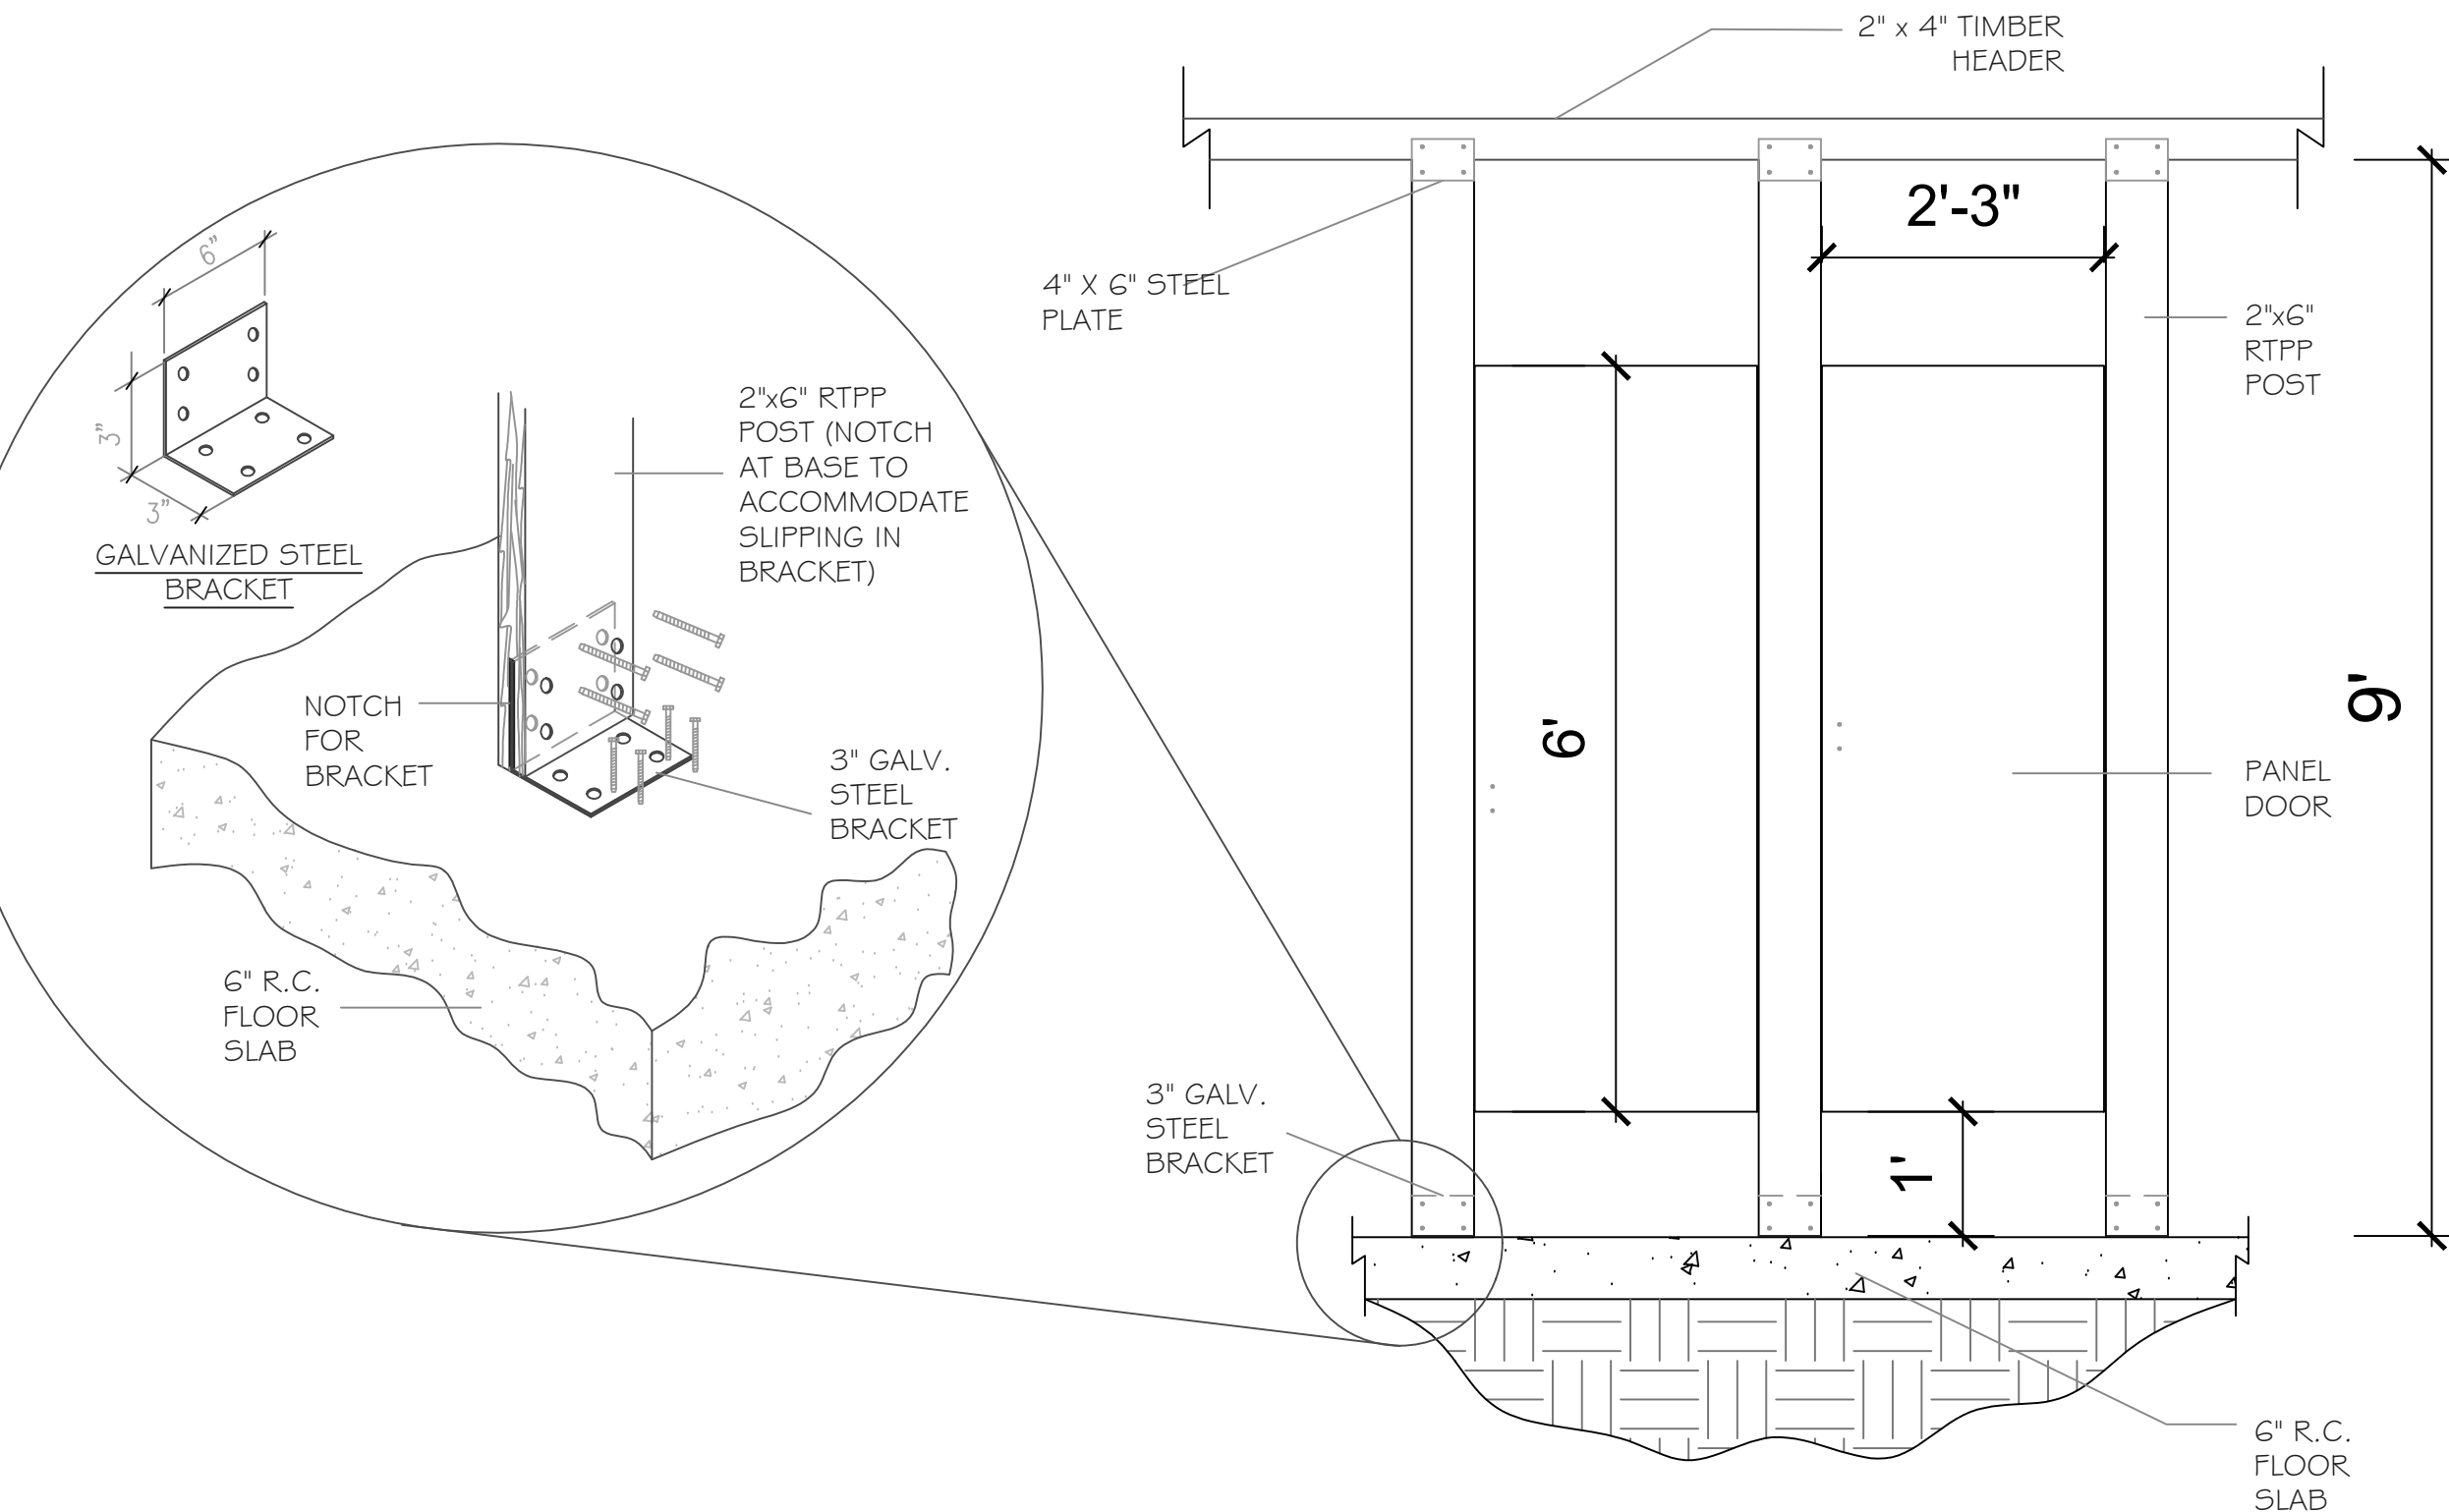


TOILET STALL - FRONT ELEVATION

General Notes		
No.	Revision/Issue	Date
Firm Name and Address		
DIVISION OF SPORT & YOUTH AFFAIRS JANIS SOLOMON BLDG 28 ORANGE HILL RD SCARBOROUGH, TOBAGO		
DRAWN BY: CHECKED BY:		
Project Name and Address		
CHANGE ROOM & TOILET FACILITY		
Drawing: PARTITION DETAIL 3		Sheet
Date: 12/20/2019		A-603
Scale: 1 1/2" = 1' 0"		

1/15/2004

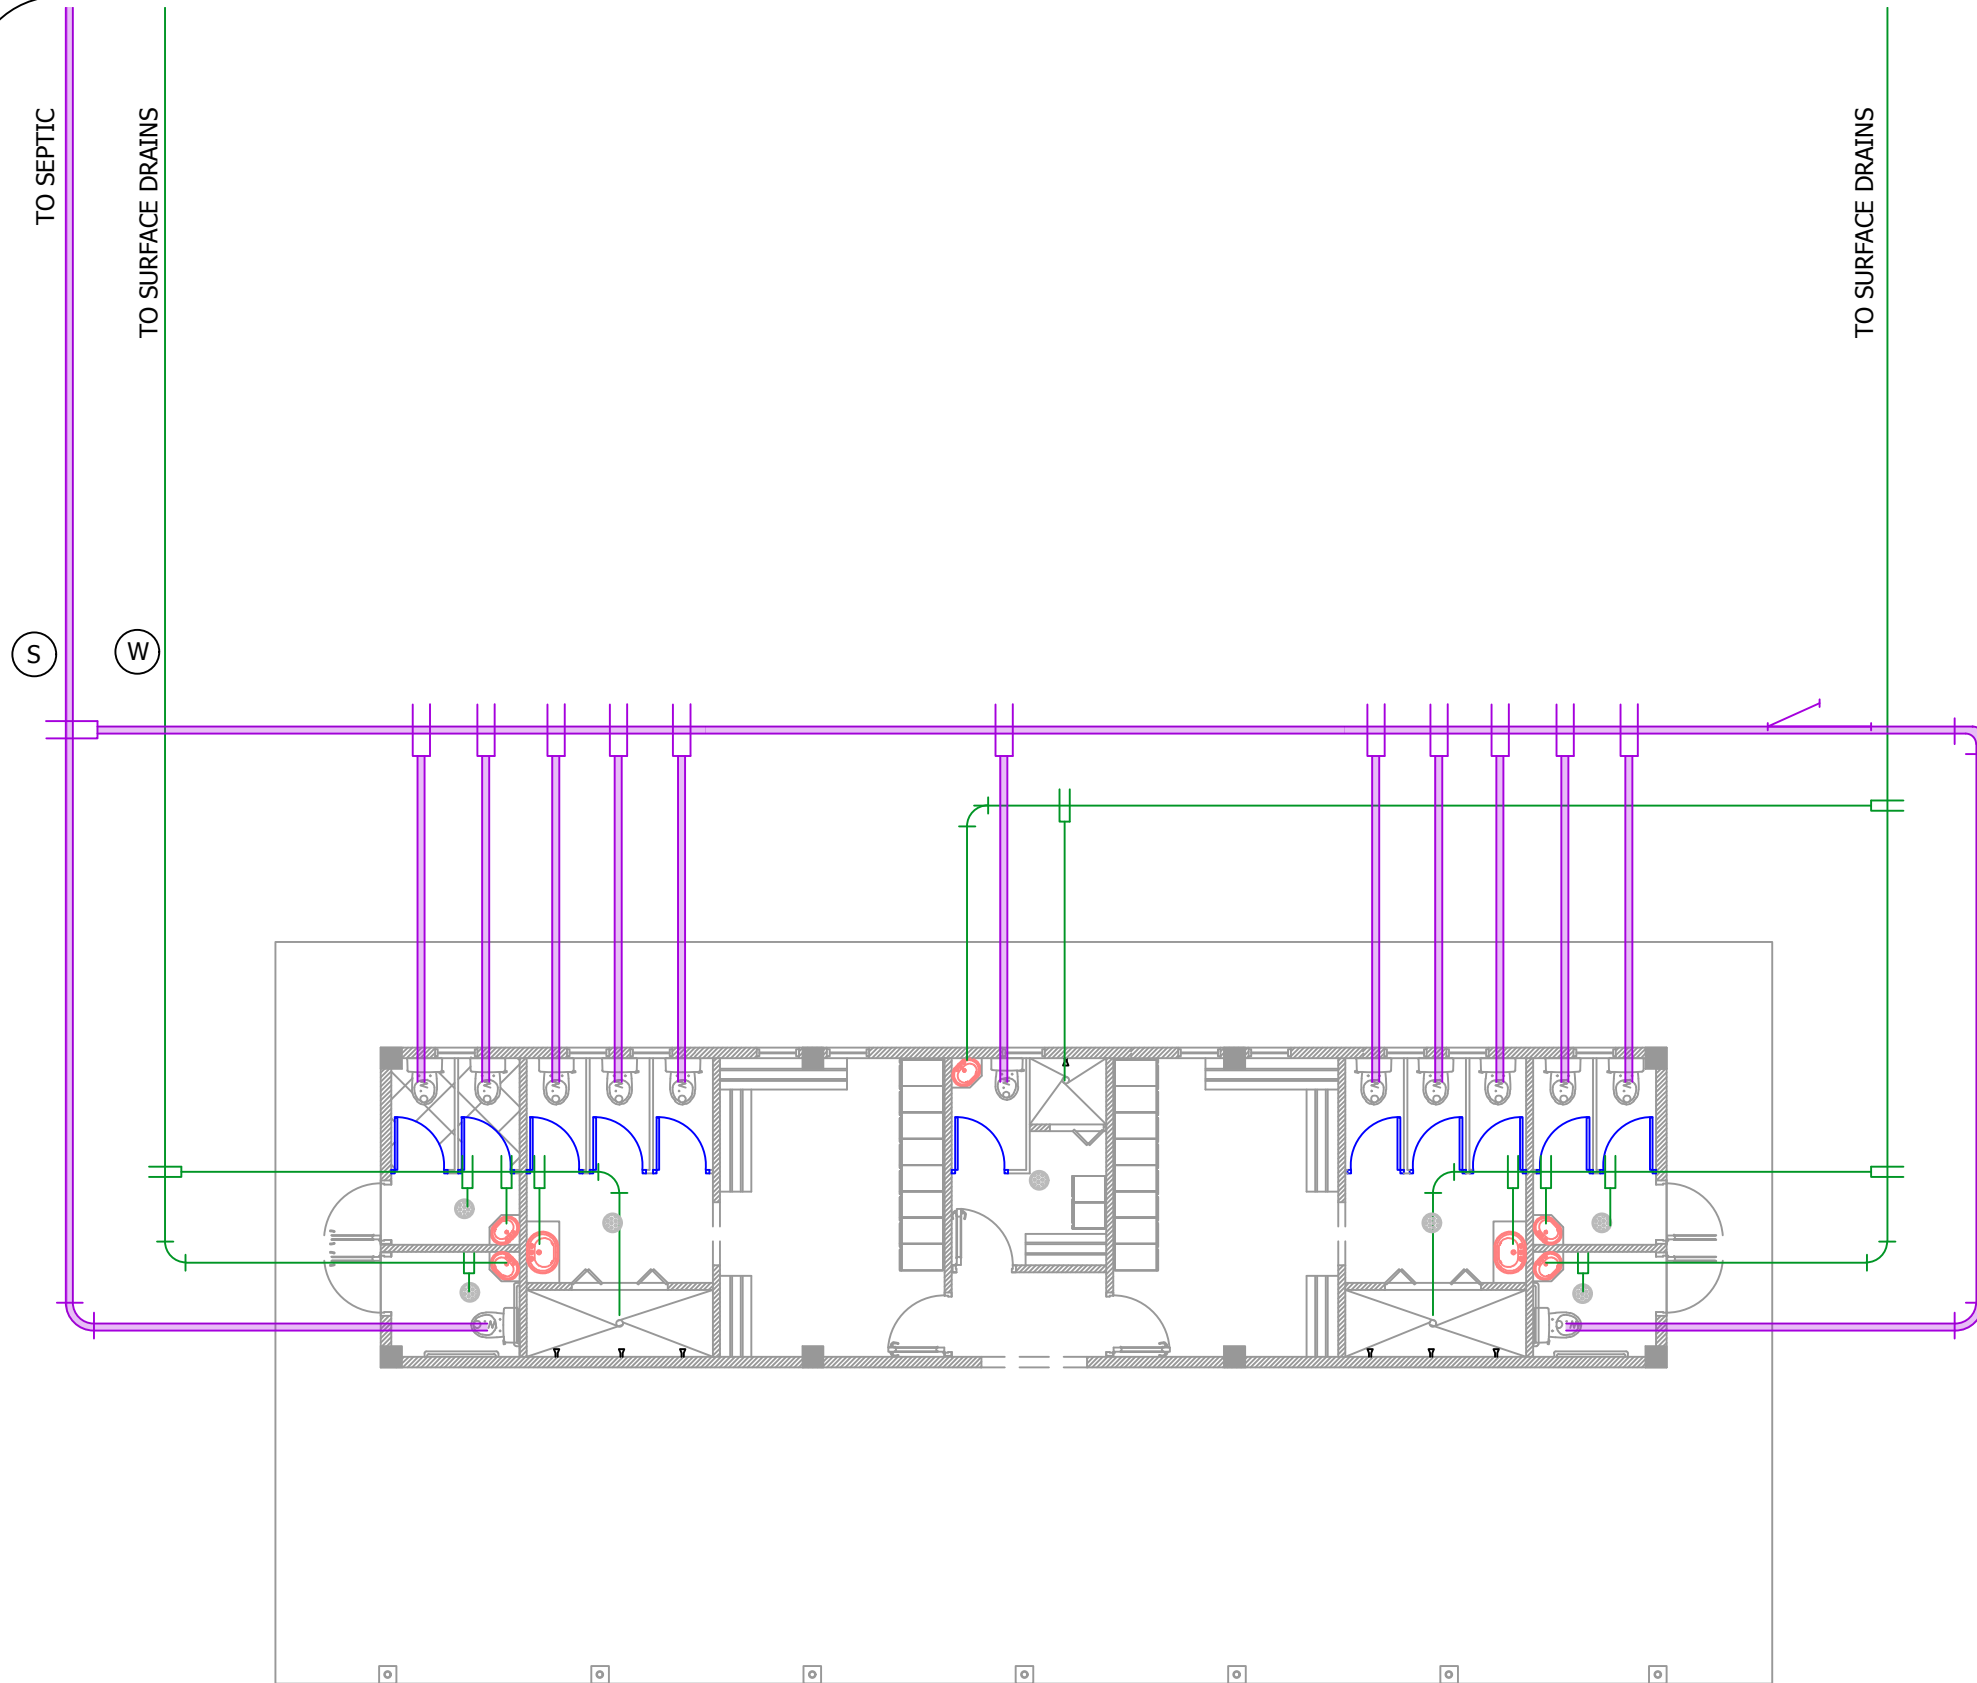

1/15/2004

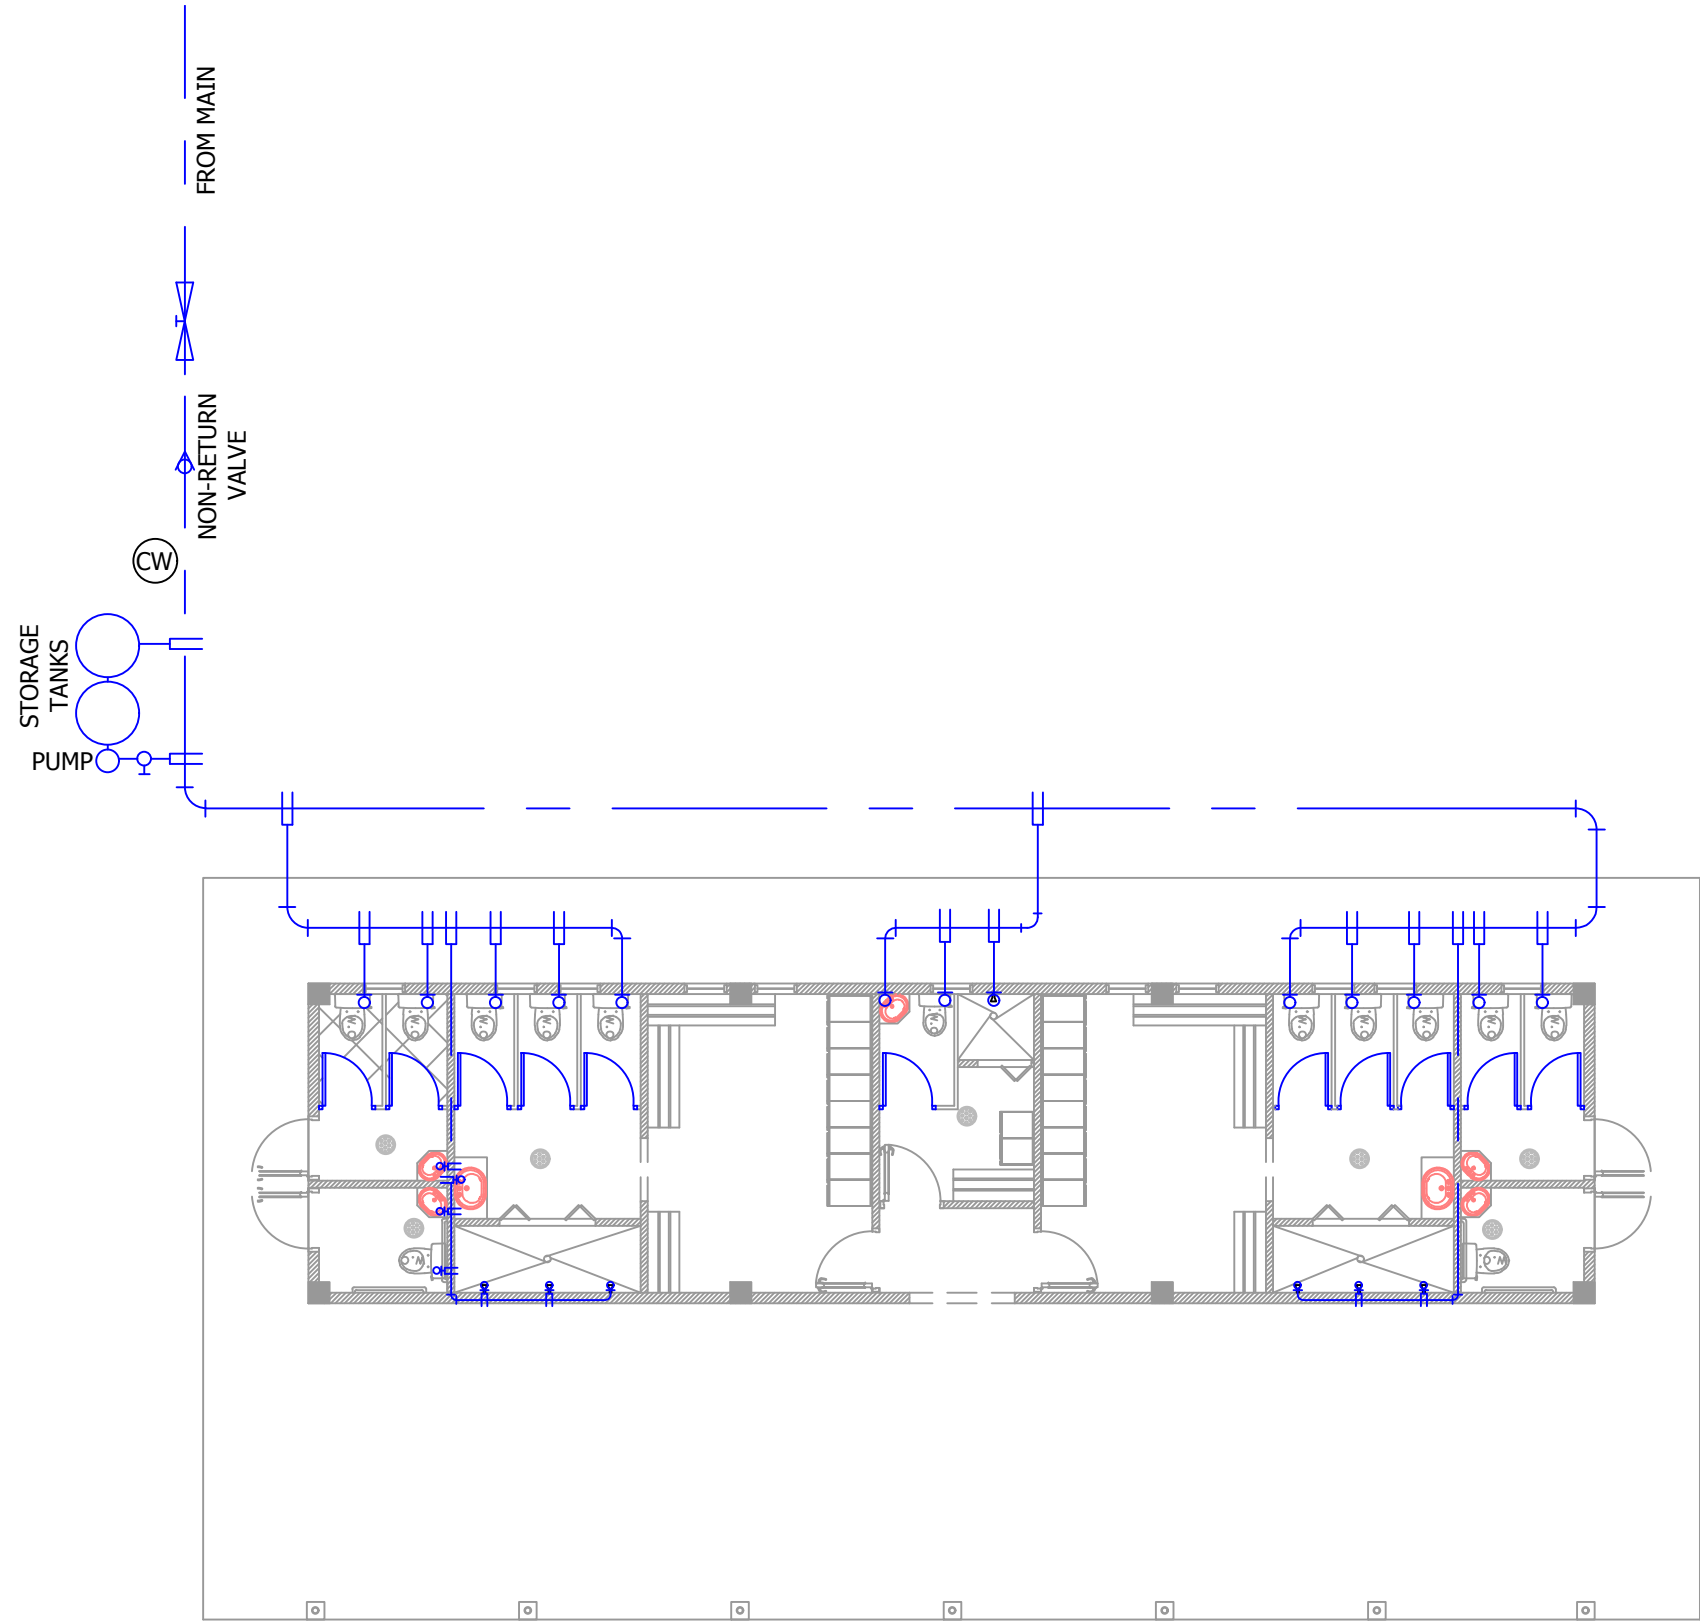

○ **WATER SUPPLY**

PLUMBING LEGEND	
SYMBOL	NAME
Ⓢ	SOIL LINE
Ⓦ	WASTE LINE
ⒸⓌ	COLD WATER LINE
↷	90° ELBOW HORIZONTAL
⊥	TEE TURNED-UP
—┴—	TEE HORIZONTAL
⊥○	ELBOW TURNED UP
↗	CLEAN OUT

General Notes


No.	Revision/Issue	Date

Firm Name and Address
DIVISION OF SPORT & YOUTH AFFAIRS
JANIS SOLOMON BLDG
28 ORANGE HILL RD
SCARBOROUGH, TOBAGO
DRAWN BY:
CHECKED BY:


Project Name and Address
CHANGE ROOM & TOILET FACILITY

Drawing: PLUMBING PLAN	Sheet: P-102
Date: 12/20/2019	
Scale: 1/4" = 1'-0"	

1/15/2004

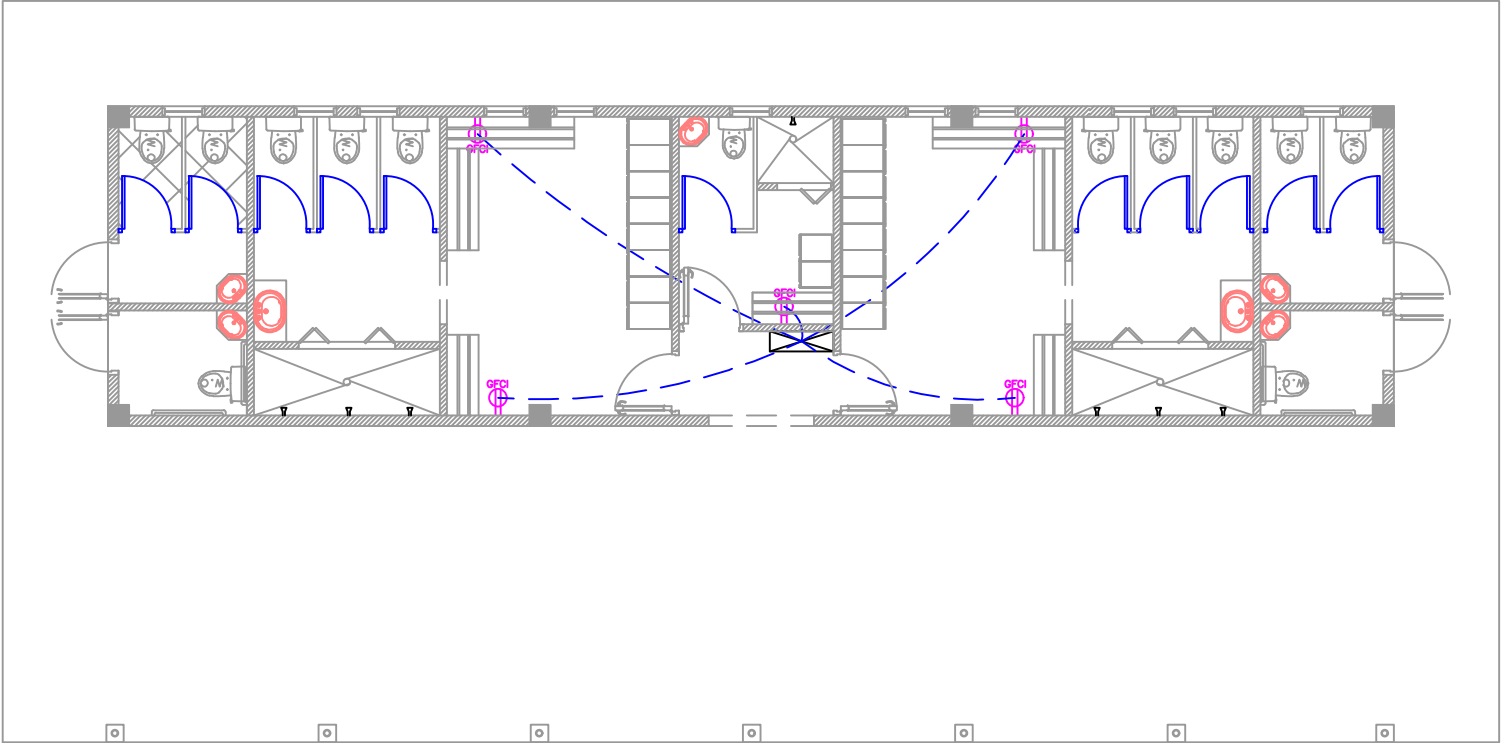

ELECTRICAL POWER

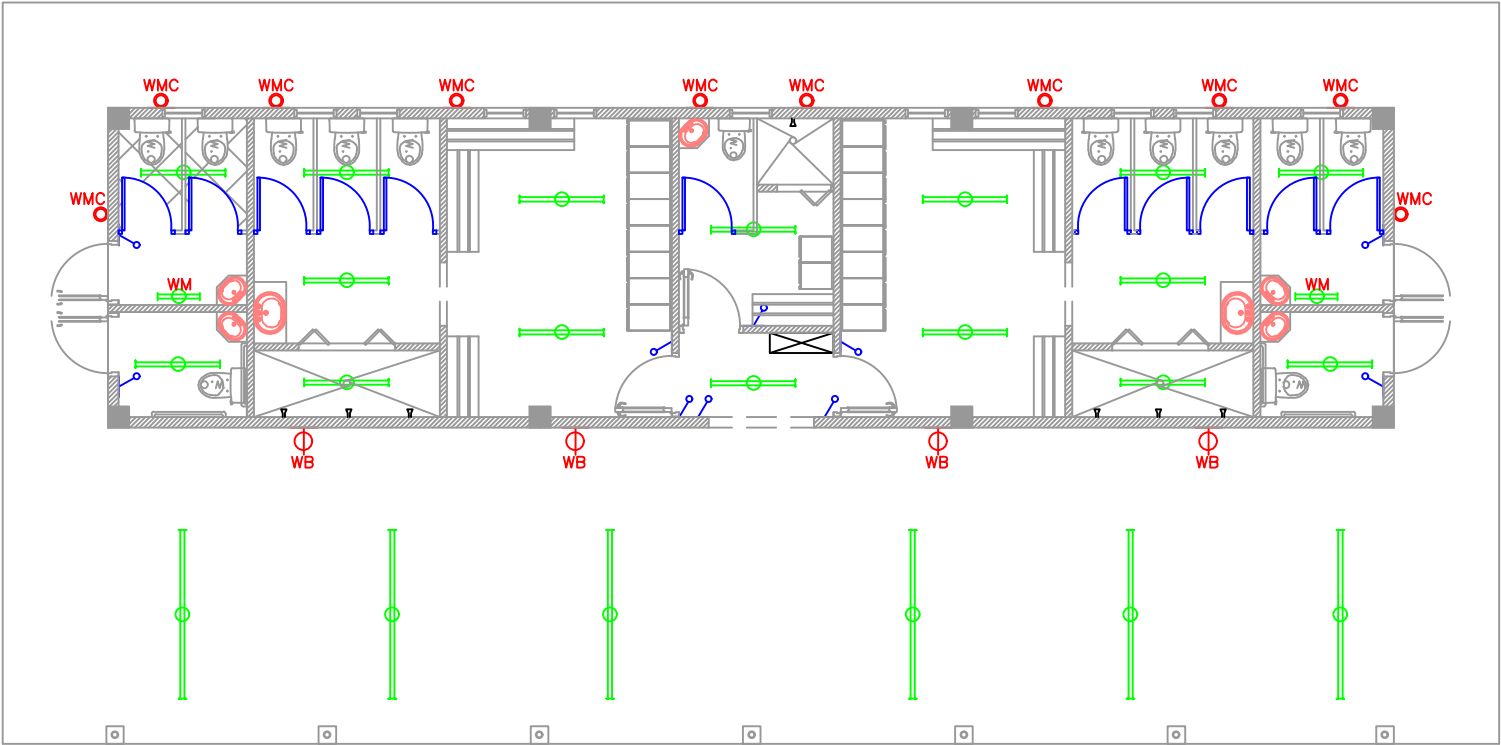

ELECTRICAL LIGHTING

ELECTRICAL LEGEND	
SYMBOL	NAME
	WALL BRACKET LIGHT
	WALL MOUNTED CYLINDRICAL LIGHT
	SINGLE LIGHT SWITCH
	WIRING
	GFCI OUTLET
	2' V/P WALL MOUNTED FLOURESCENT LIGHT
	4' V/P FLOURESCENT LIGHT
	8' V/P FLOURESCENT LIGHT
	MAIN PANEL

General Notes

No.	Revision/Issue	Date

Firm Name and Address
DIVISION OF SPORTS & YOUTH AFFAIRS
SINGH'S PLAZA
DUTCH FORT
SCARBOROUGH, TOBAGO
DRAWN BY:
CHECKED BY:

Project Name and Address
CHANGE ROOM & TOILET FACILITY

Drawing:
ELECTRICAL PLANS
Date
1/7/2020
Scale
1/4" = 1' 0"

Sheet
E-101