



TITLE TOWNSHIP ROAD IMPROVEMENTS DEPARTMENT OF TRANSPORTATION ROAD DISTRICT 11	
PROJECT LOTS D'OR PROJECTS (UNIT # 1) WINDWARD ROAD, DISTRICT 11	
DRAWING TITLE SITE & LOCATION PLANS	
DATE	10/11/11
SCALE	1" = 10'
DRAWN BY	A. DUBOIS
CHECKED BY	

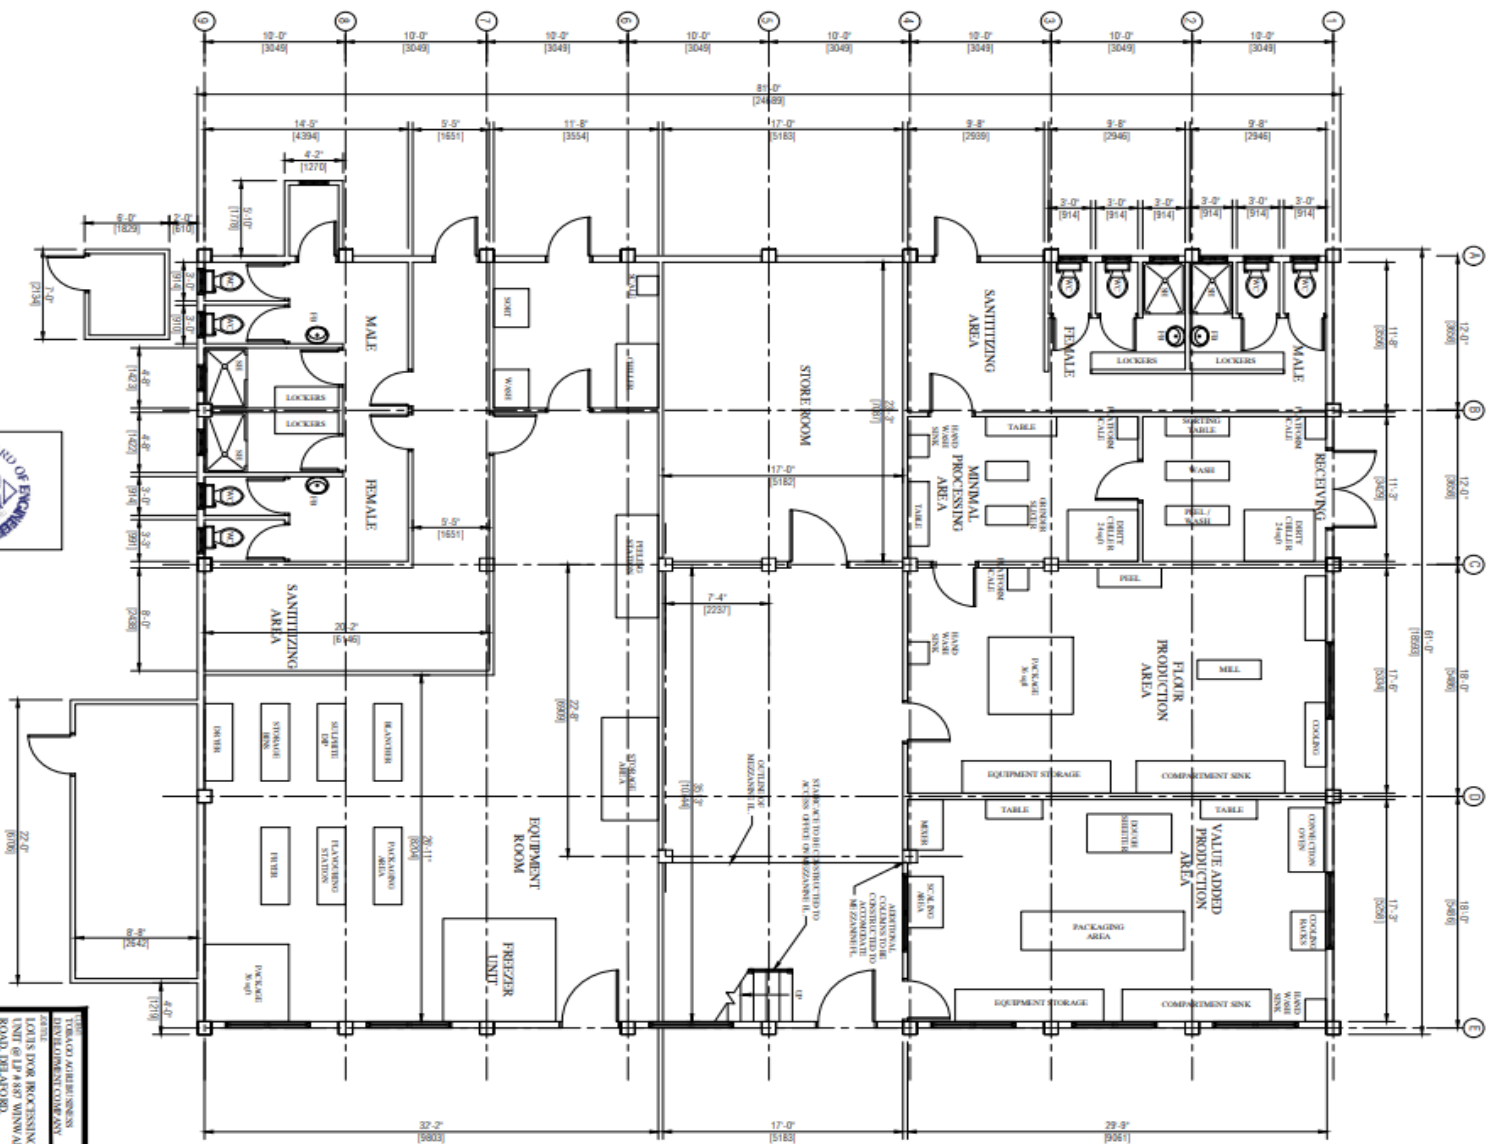

TONYO ARCHITECTS
 CIVIL ENGINEERS
 1015 DOB PROCESSING
 UNIT #1P 487 WINNARD
 ROAD DELAWARE


**PROPOSED
 FL. LAYOUT**

SCALE: 1/4" = 1'-0"
 SHEET NO. 402
 DRAWN BY: CHADLER

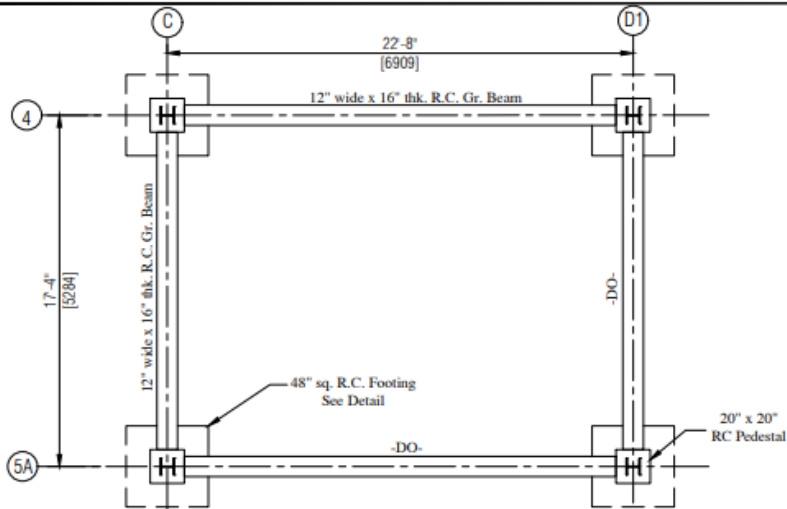


FOUNDATION PLAN

SCALE: 3/8" = 1'-0"

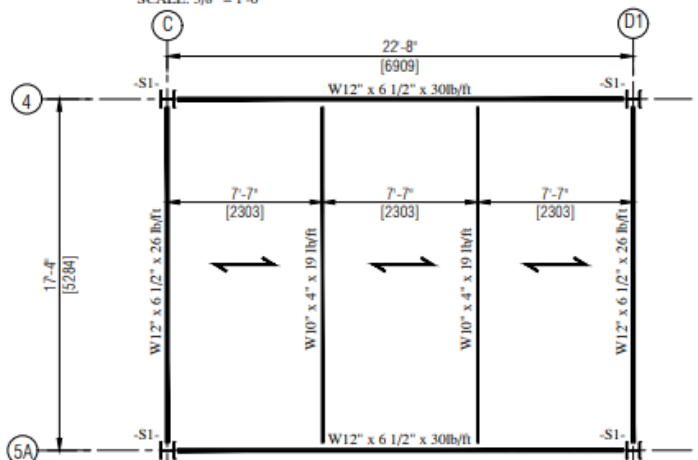


MEZZANINE FL. BEAM FRAMING


SCALE: 3/8" = 1'-0"

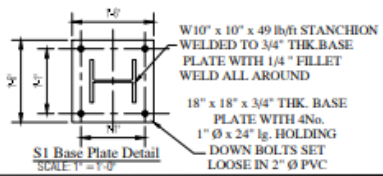


S1 Base Plate Detail
SCALE: 1" = 1'-0"

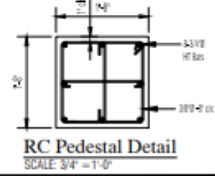


RC Pedestal Detail
SCALE: 3/4" = 1'-0"

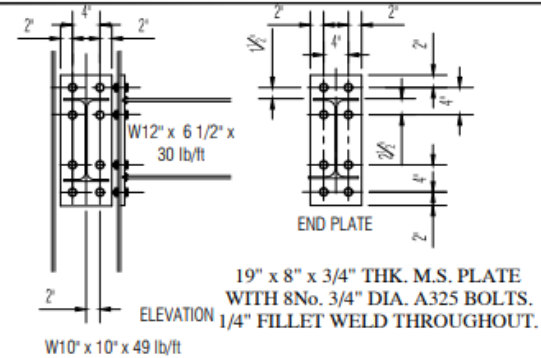


W12" x 6 1/2" x 30 lb/ft Beam Connection To W10" x 10" x 49 lb/ft Stanchion (FLANGE)
SCALE: 1 1/2" = 1'-0"

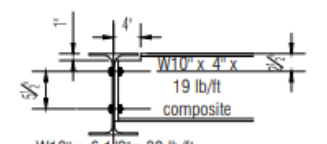


W12" x 6 1/2" x 30 lb/ft Beam Connection To W10" x 4" x 19 lb/ft composite Beam (WEB)
SCALE: 1 1/2" = 1'-0"

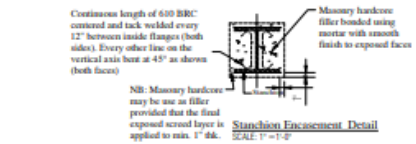


Stanchion Encasement Detail
SCALE: 1" = 1'-0"

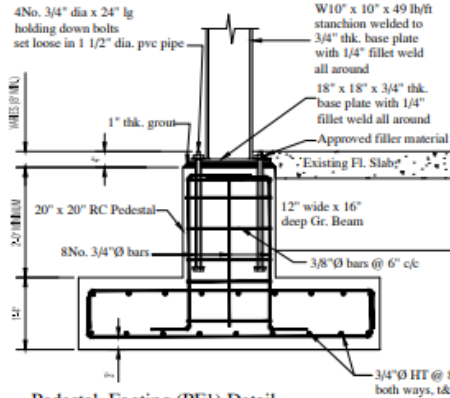


Pedestal, Footing (PF1) Detail
SCALE: 1" = 1'-0"

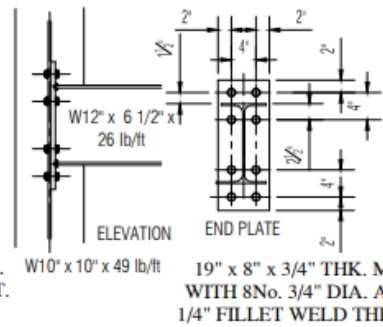


W12" x 6 1/2" x 26 lb/ft Beam Connection To W10" x 10" x 49 lb/ft Stanchion (WEB)
SCALE: 1 1/2" = 1'-0"

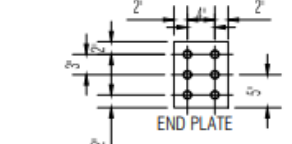

W12" x 6 1/2" x 30 lb/ft Beam Connection To W10" x 4" x 19 lb/ft composite Beam (WEB)
SCALE: 1 1/2" = 1'-0"

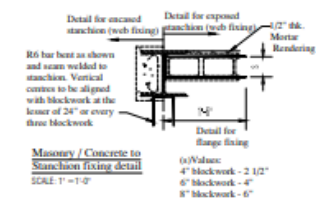


Masonry / Concrete to Stanchion fixing detail
SCALE: 1" = 1'-0"

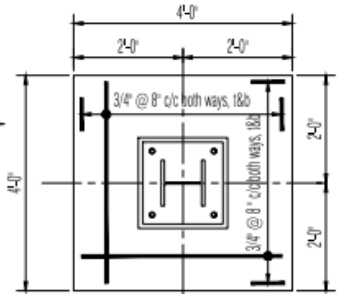


Pad Footing Detail (PF1)
SCALE: 1" = 1'-0"

CLIENT	TOBAGO AGRICULTURE BUSINESS DEVELOPMENT COMPANY
PROJECT	LOUIS FOR PROCESSING UNIT @ LP #187 WINWARD ROAD, DELAFORD.
DESIGNED BY	FOUNDATION PLAN BEAM FRAMING & DETAILS
DATE	02/27/2018
SCALE	AS SHOWN
DRAWN BY	G. CHARLES

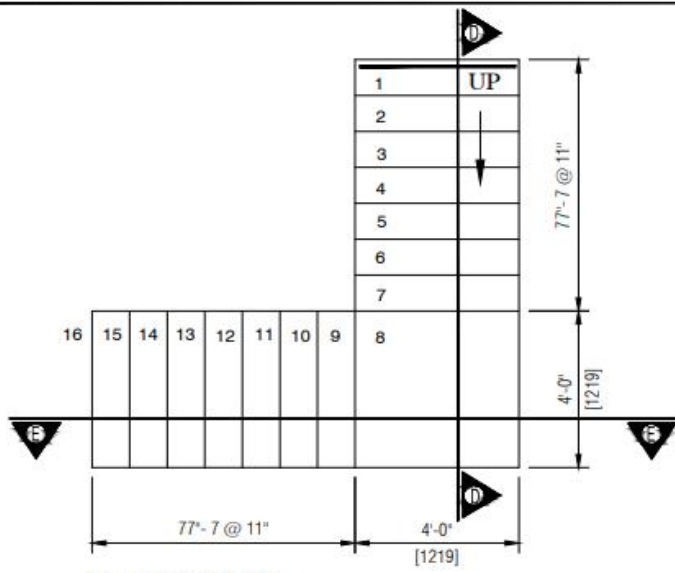


PLAN OF STAIR
SCALE: 1/8" = 1'-0"

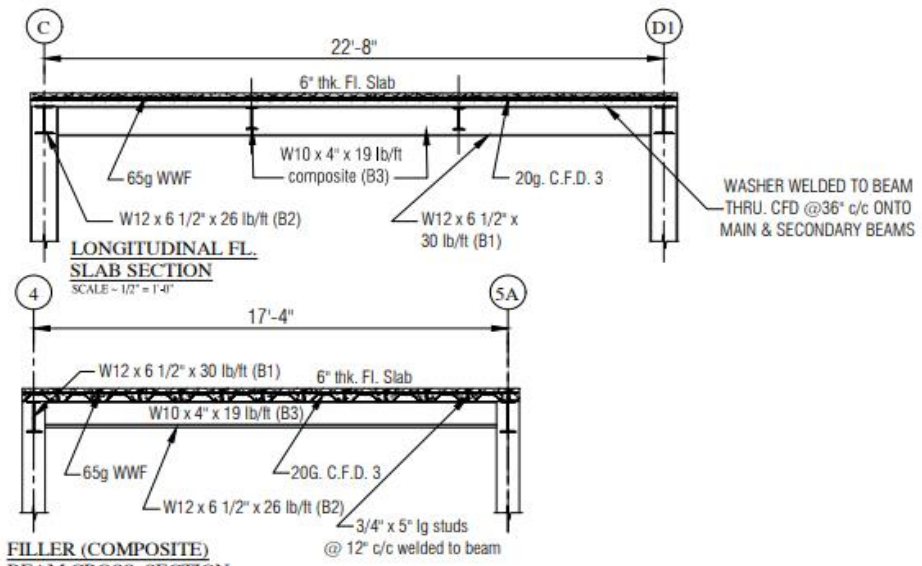


LONGITUDINAL FL. SLAB SECTION
SCALE: 1/2" = 1'-0"

FILLER (COMPOSITE) BEAM CROSS SECTION
SCALE: 1/2" = 1'-0"

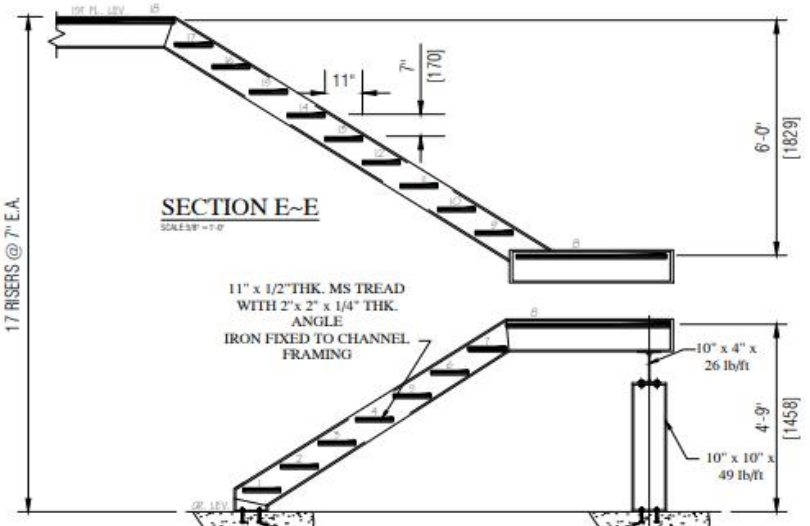


SECTION E~E
SCALE: 3/8" = 1'-0"

SECTION D~D
SCALE: 3/8" = 1'-0"

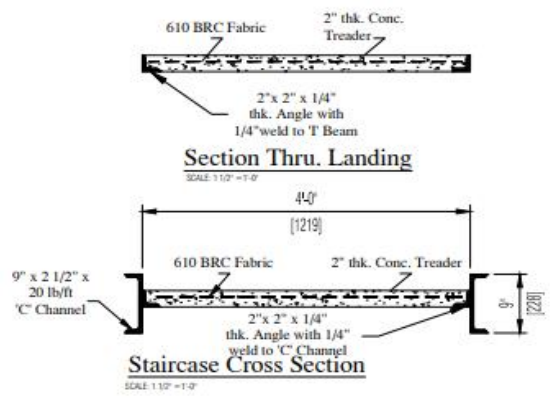


Section Thru. Landing
SCALE: 1/12" = 1'-0"

Staircase Cross Section
SCALE: 1/12" = 1'-0"

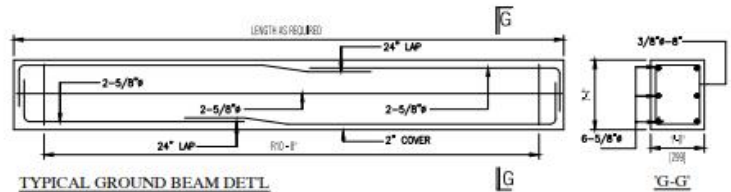


TYPICAL GROUND BEAM DETL

CLIENT: TOBAGO AGRICULTURE BUSINESS DEVELOPMENT COMPANY	
PROJECT: LOUIS D'OR PROCESSING UNIT @ LP # 887 WINWARD ROAD, DELAFORD.	
DRAWING TITLE: STAIR, GR. BEAM DETAILS & FL. SLAB CROSS SECTIONS	
DATE: 02.22	DRAWN BY: S. CHANDRA
SCALE: AS SHOWN	CHECKED BY: S. CHANDRA
SHEET NO. 5 OF 7	

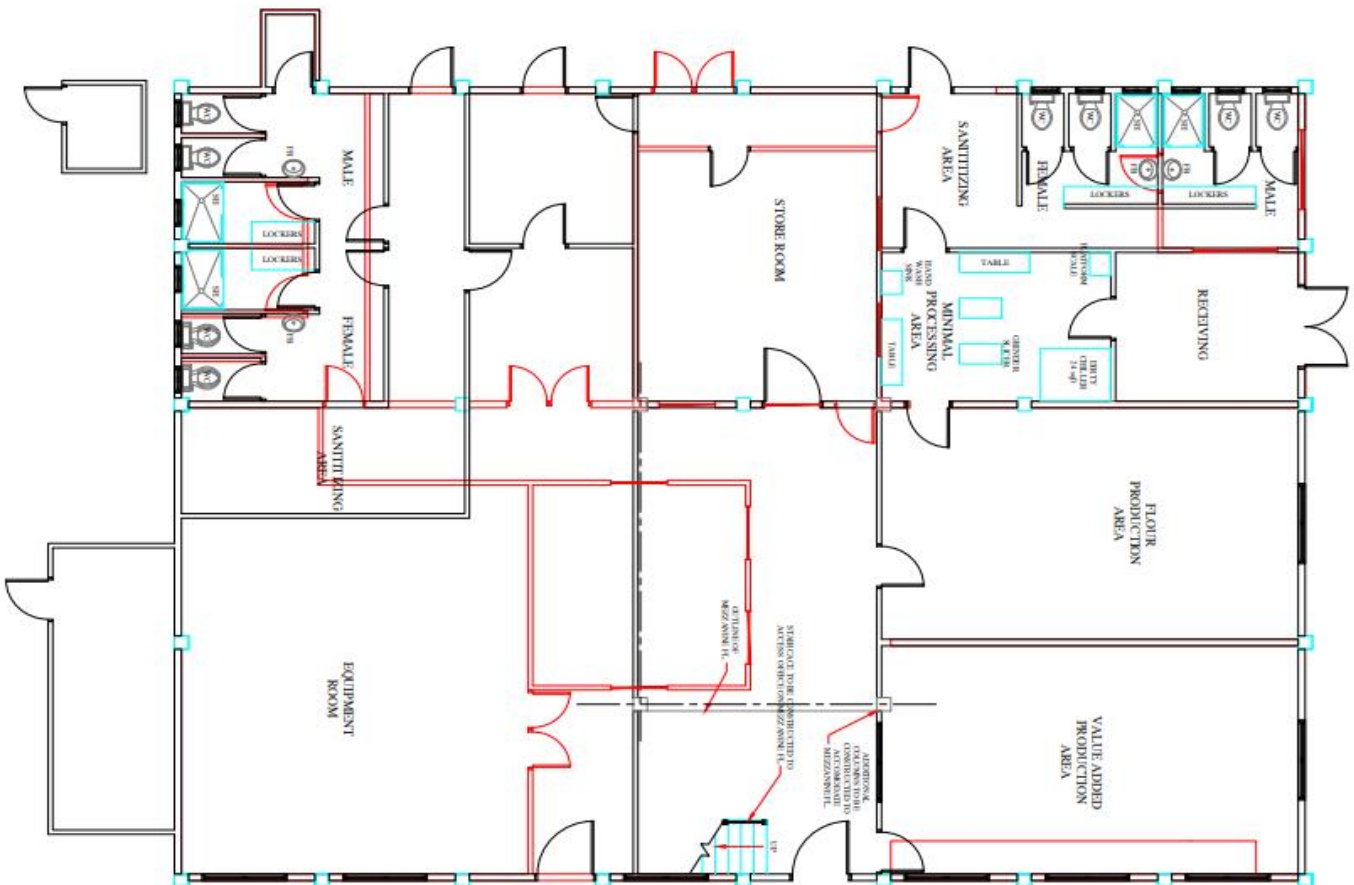

NOTE: STRUCTURE SHADED IN RED ARE TO BE DEMOLISHED

THE AGRI-BUSINESS DEVELOPMENT COMPANY 1015 S. W. PROGRESS AVE. UNIT #17 9875 WINWARD ROAD, DELAWARE, OH 43015	
DRAWN BY: DATE: 02-22-14 SCALE: 1/2" = 1'-0" SHEET NO.: 104	DEMOLITION LAYOUT

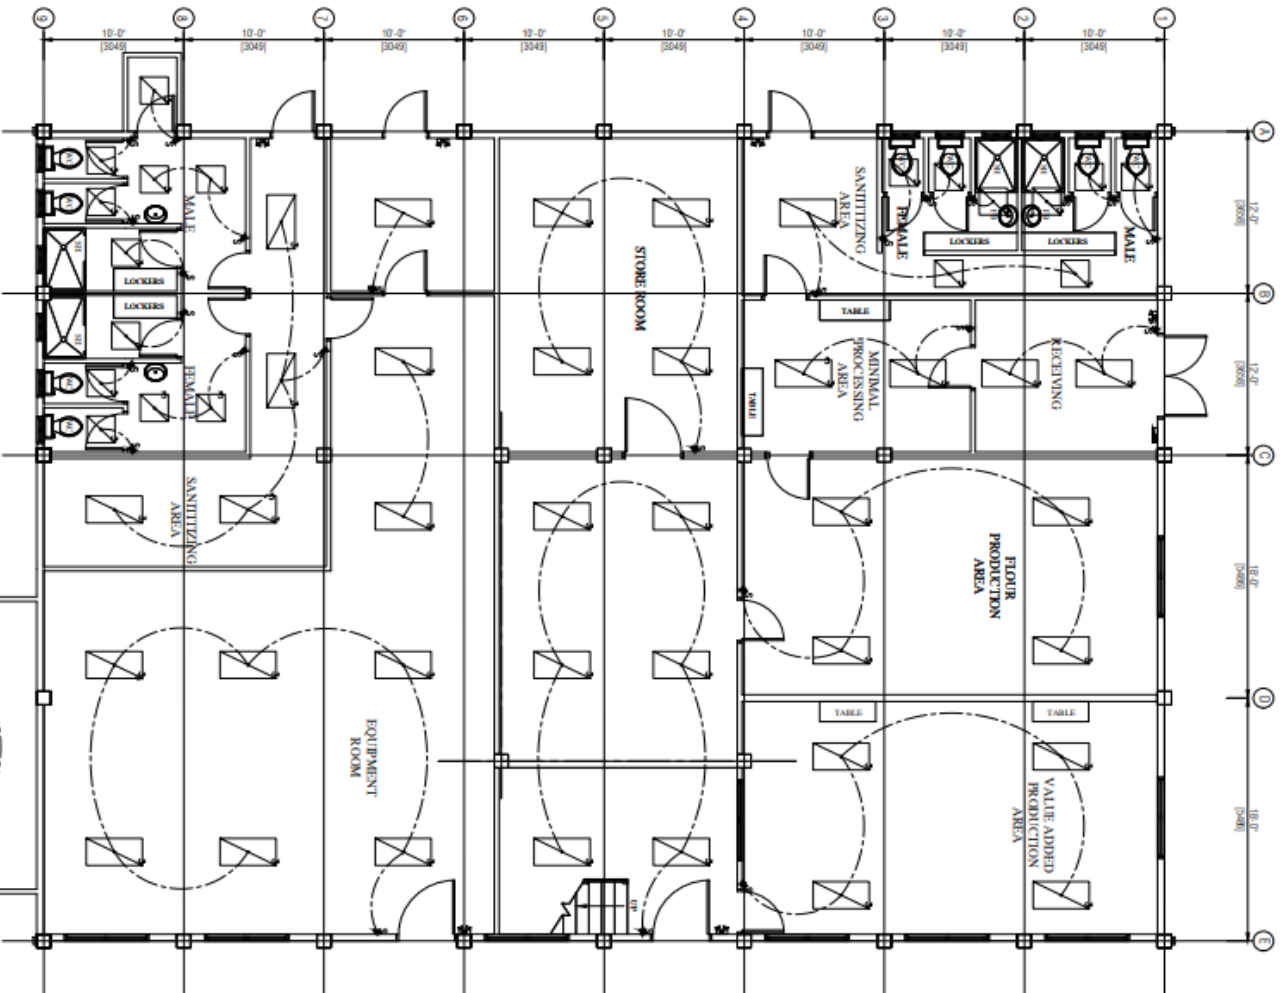

LEGEND


- 120-27V, 600mm x 1200mm RECESSED FLUORESCENT LIGHT FIXTURE OR APPROVED EQUIV.
- 120-27V, 600mm x 600mm RECESSED FLUORESCENT LIGHT FIXTURE OR APPROVED EQUIV.
- 120-27V WALL LIGHT SECURITY LIGHT FIXTURE
- 120-27V WALL LIGHT SECURITY LIGHT FIXTURE WITH VANDAL RESISTANT OR APPROVED EQUIV.
- EMERGENCY LIGHTING
- 20A, 120-27V DOUBLE POLE LIGHT SWITCH OR APPROVED EQUIV.
- 20A, 120-27V SINGLE POLE LIGHT SWITCH OR APPROVED EQUIV.
- ELECTRICAL PANEL
- CONCRETE RIBBON CEILING



THE SINGAPORE ENGINEERS' AND SURVEYORS' BOARD
 100, ROBINSON ROAD, SINGAPORE 068914
 TEL: 4342400
 FAX: 4342401
 www.esb.gov.sg

LIGHTING LAYOUT

DATE	07/17
SCALE	AS SHOWN
PROJECT NO.	B-10

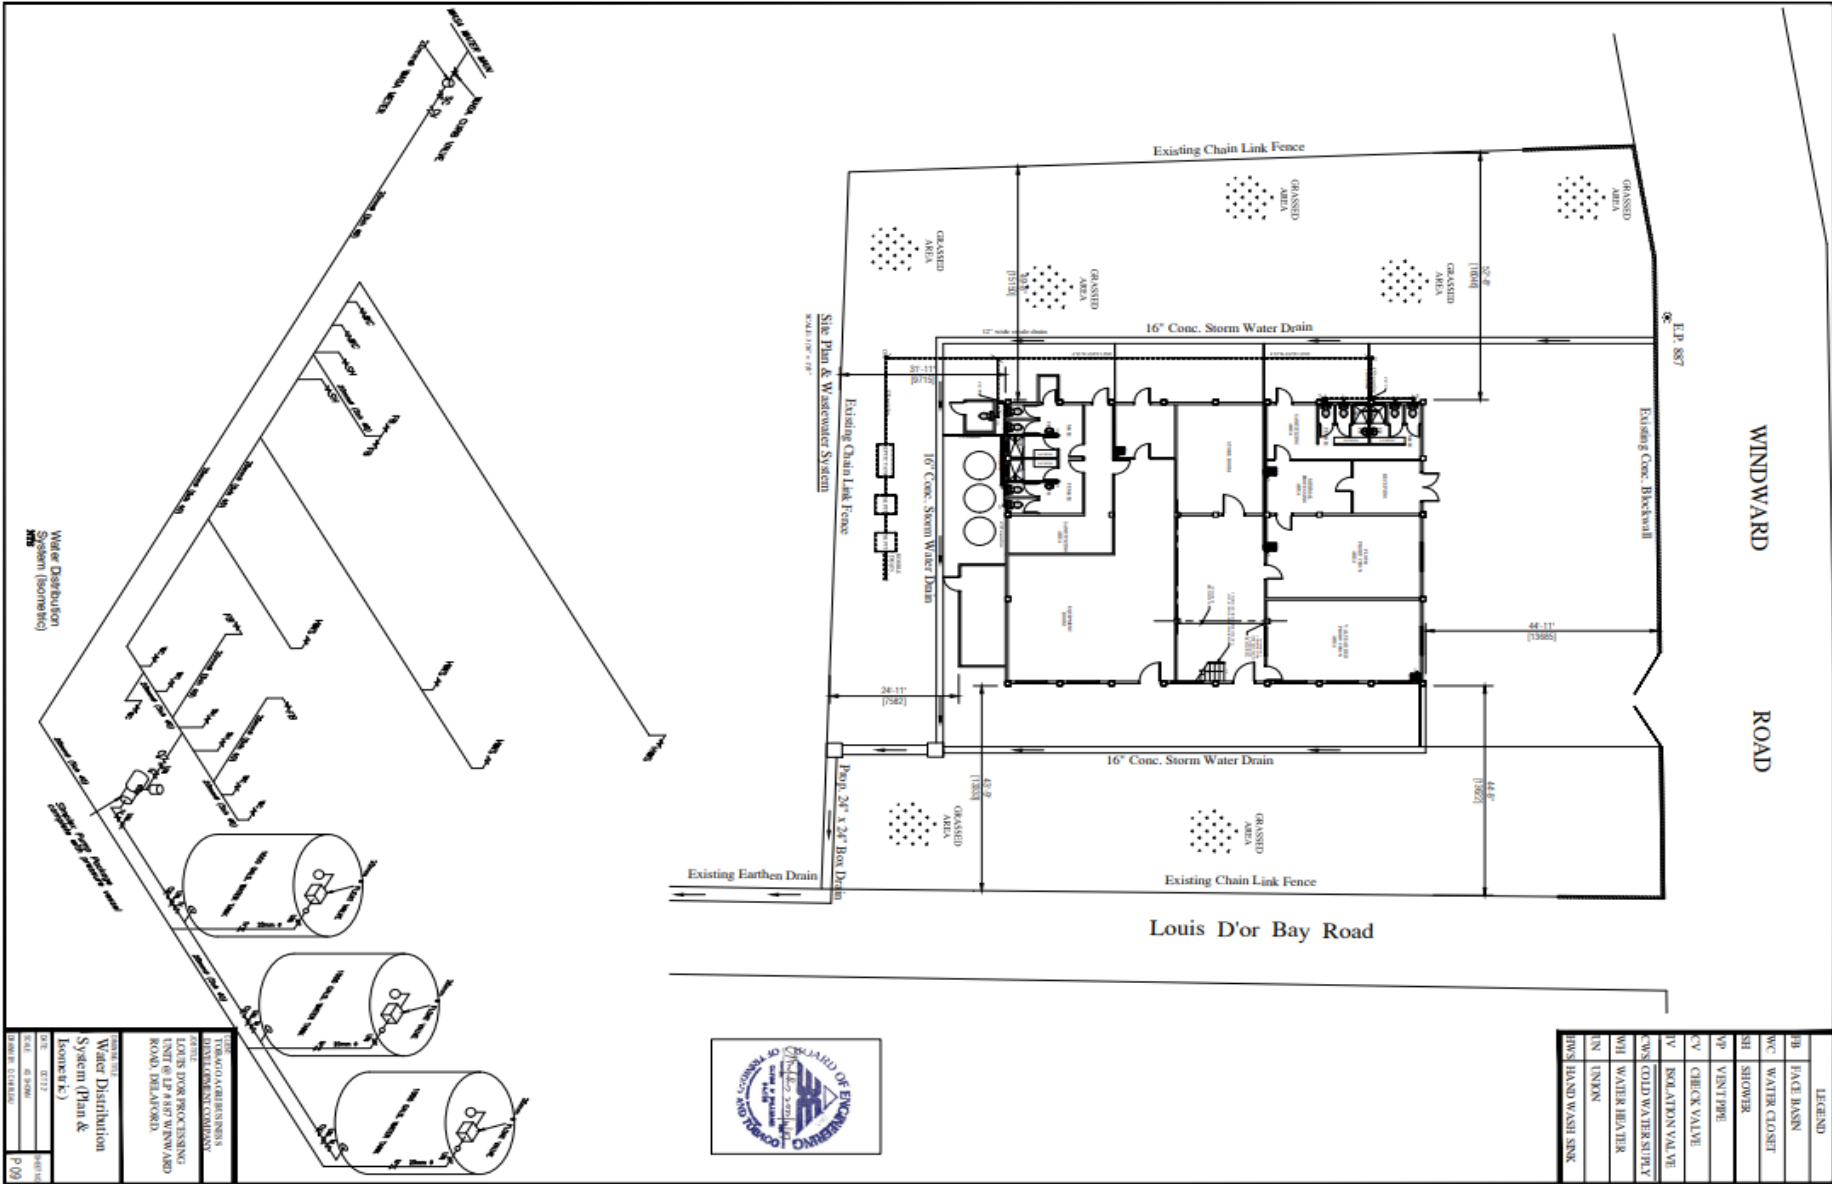

WINDWARD ROAD

Louis D'or Bay Road

LEGEND	
BB	FACE BASIN
WC	WATER CLOSET
SH	SHOWER
VP	VENT PIPE
CV	CHECK VALVE
IV	ISOLATION VALVE
CWS	COLD WATER SERVICE
WH	WATER HEATER
TN	TANK
HWS	HAND WASH SINK






TITLE: WATER DISTRIBUTION SYSTEM (Plan & Isometrics)	
DRAWN BY: [Name]	
CHECKED BY: [Name]	
DATE: 01/2024	
SCALE: AS SHOWN	
SHEET NO. 01 OF 01	
PROJECT NO. [Number]	
CLIENT: [Name]	
SITE: [Address]	
DRAWING NO. [Number]	
P.01	


WINDWARD

ROAD


LEGEND	
CO	CLEAN/OUT
FB	FACE BASIN
WC	WATER CLOSET
SH	SHOWER
VP	VINT PIPE
HWS HAND WASH SINK	

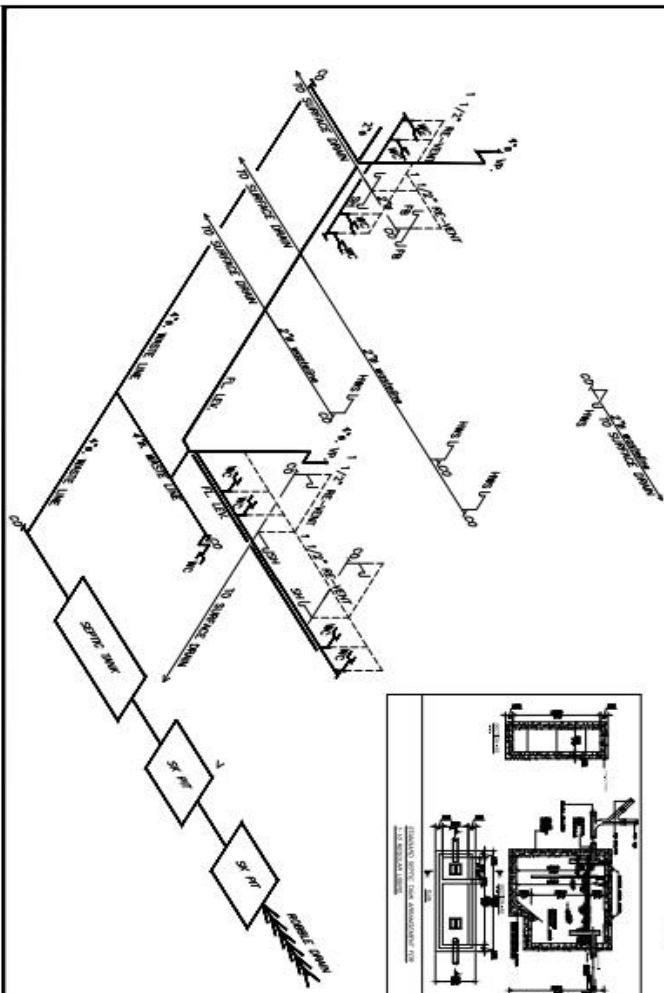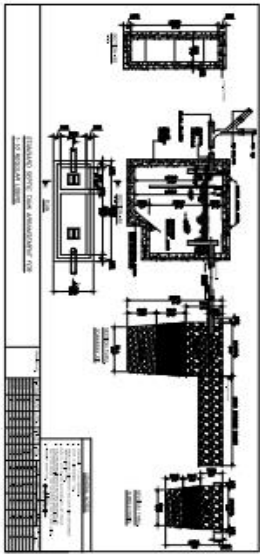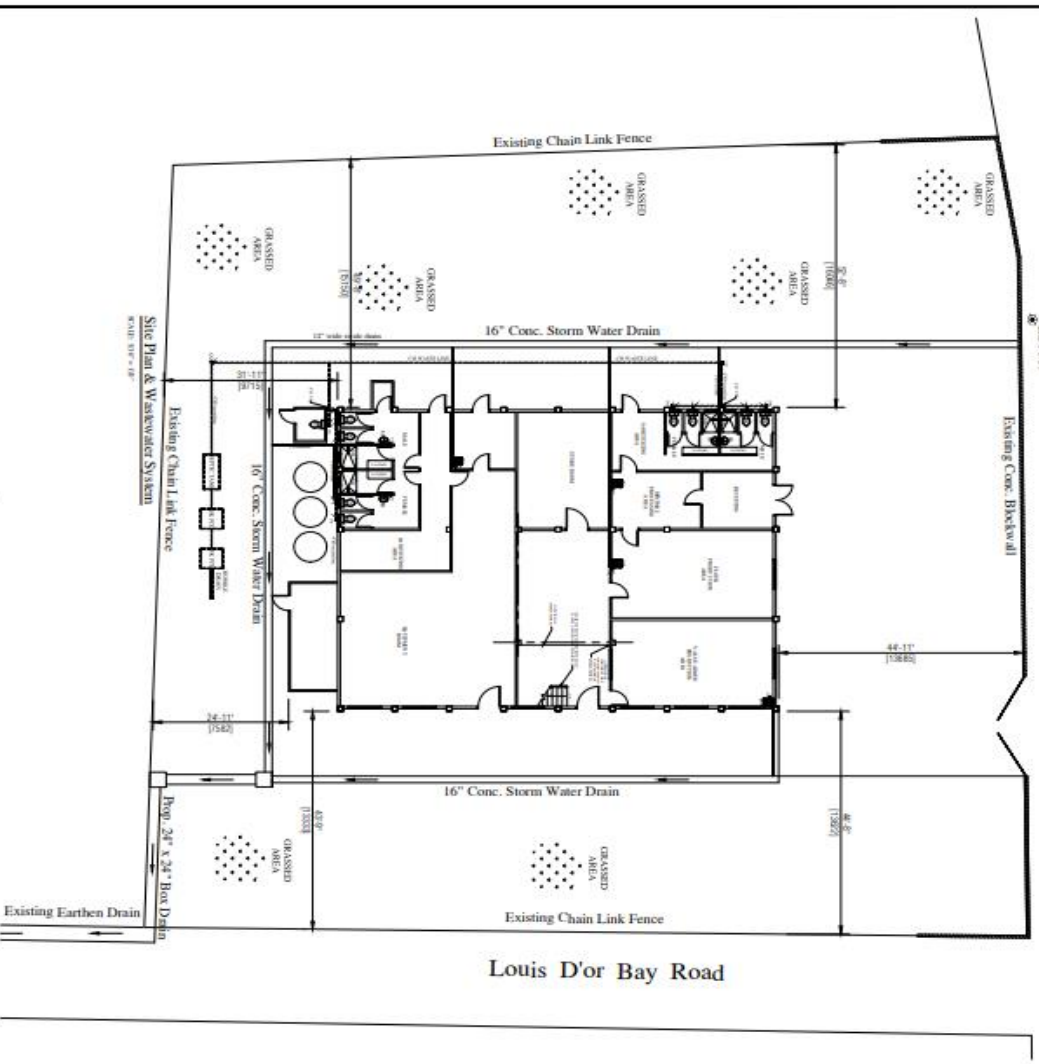


PROJECT	
PROJECT NO.	17-0001
DATE	05/11/2017
SCALE	AS SHOWN
DESIGNED BY	DAVID L. CHARRAU
TITLE: TRUCKO'LETTRE SERVICE 16175 LAFAYETTE BOULEVARD LOUIS D'OR PROJECT SIGNAGE (N17) @ 17487 WINDWARD ROAD DELAWARE	
PROJECT: Site Plan, Septic Tank Arrangement & Wastewater System (Plan & Elevation)	
DATE	05/11/2017
SCALE	AS SHOWN
DESIGNED BY	DAVID L. CHARRAU
P 08	

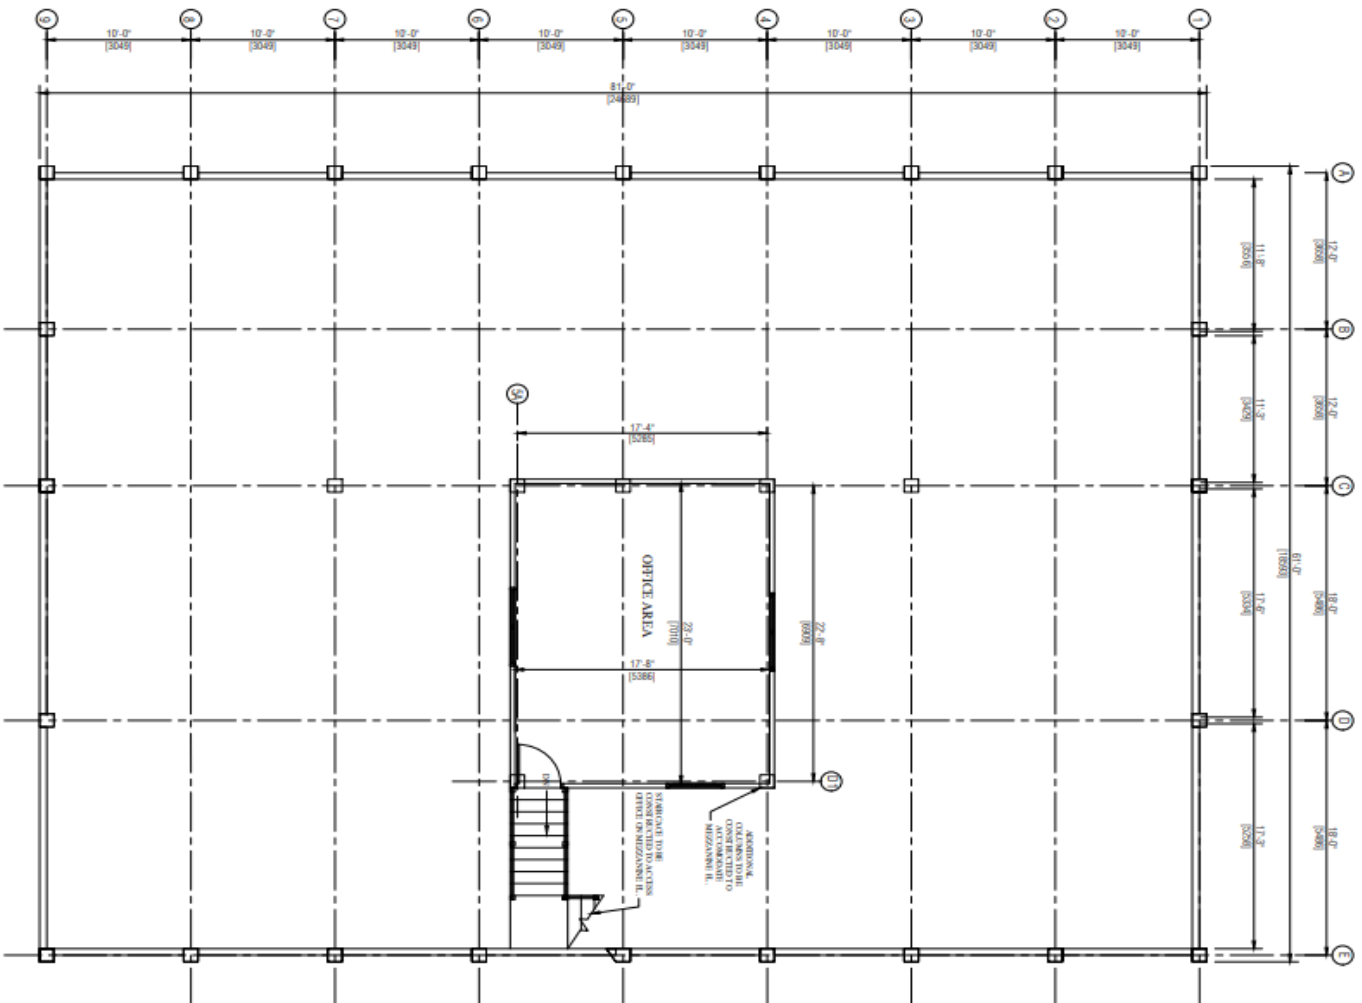


TITLE: MEZZANINE F.L. LAYOUT	
DATE: 02-27-17	DRAWN: C. CHADLER
SCALE: 1/8" = 1'-0"	SHEET: A-03
PROJECT: LOT 15 FOR PROGRESSIVE DEVELOPMENT COMPANY ADDRESS: LOT 15 FOR PROGRESSIVE DEVELOPMENT COMPANY ROAD, DELAWARE	

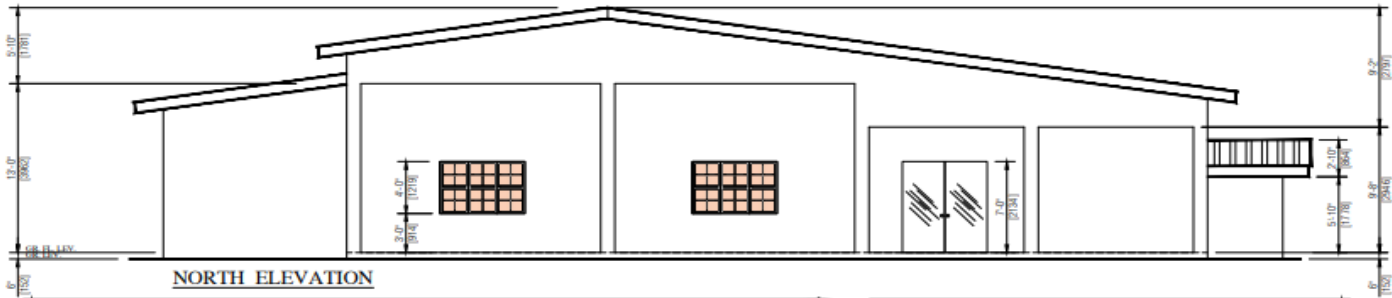


NORTH ELEVATION

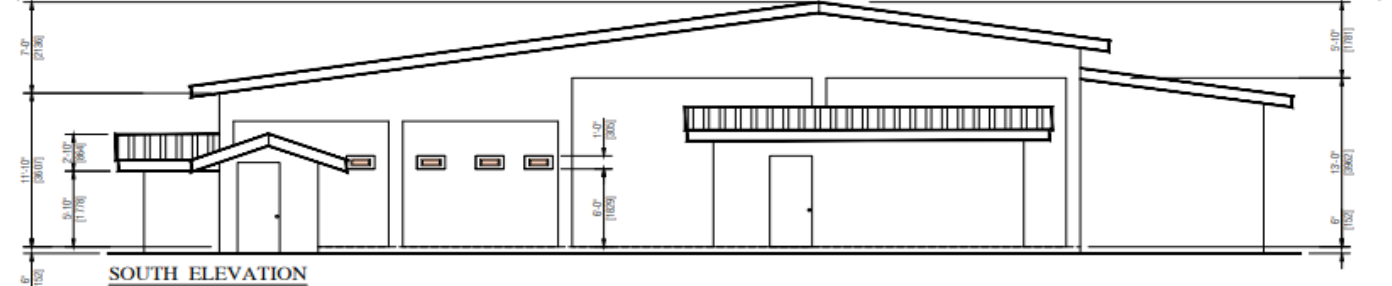

SOUTH ELEVATION

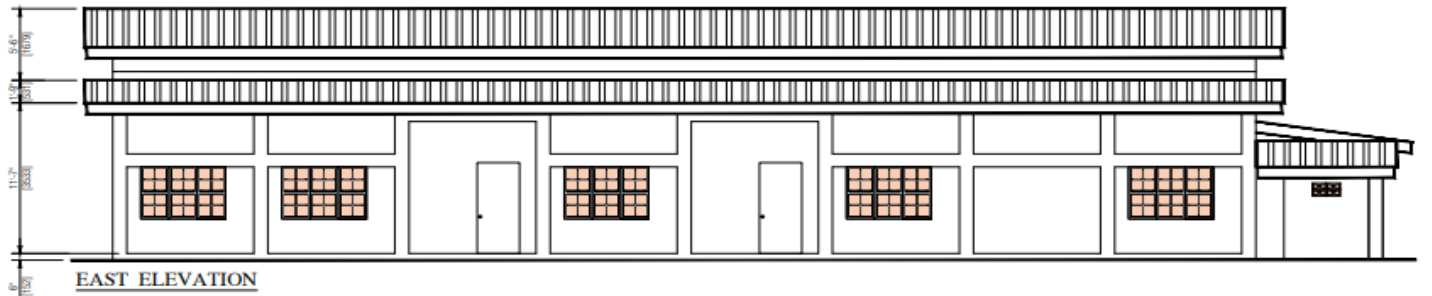

EAST ELEVATION

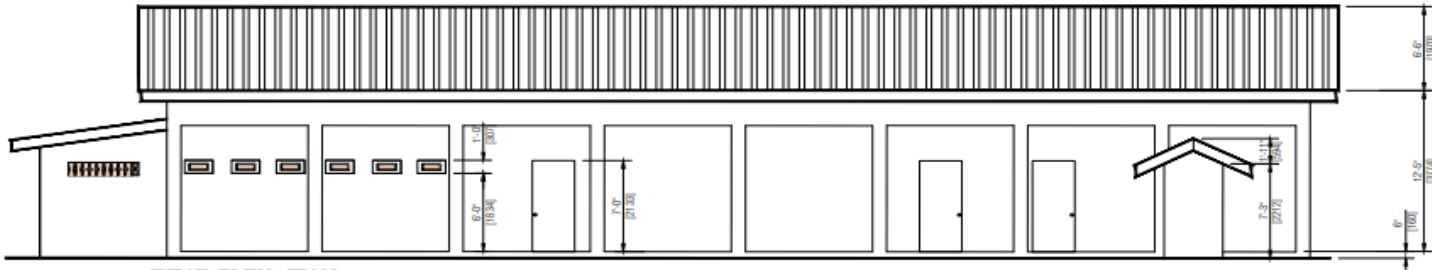

WEST ELEVATION



CLIENT:
 TORRADO AGRI BUSINESS
 DEVELOPMENT COMPANY
 FOR THE:
 LOUIS D'OR PROCESSING
 UNIT @ LP # 887 WINWARD
 ROAD, DELAFORD.

DRAWING TITLE:
ELEVATIONS

DATE:	SHEET NO:
SCALE: 1/4" = 1'-0"	
DRAWN BY: S. CARROLL	A 05