

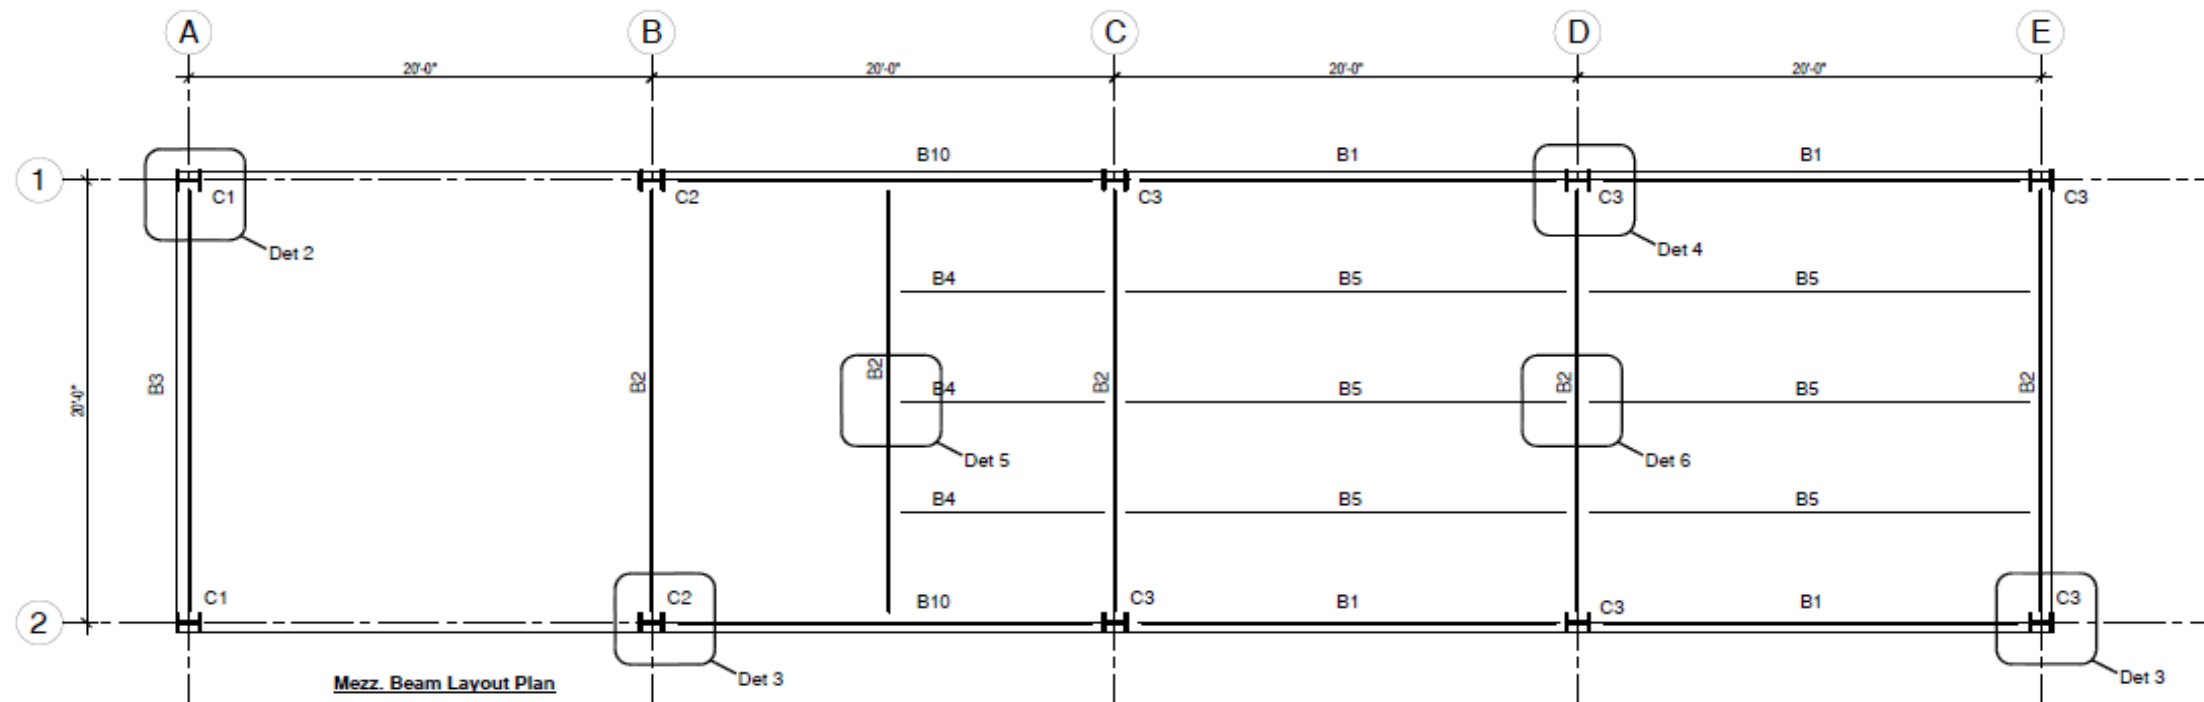



PROJECT: TRACTOR POOL	CLIENT: SS-TT	COMPANY NAME: DIVISION OF FOOD SECURITY, NATURAL RESOURCES, THE ENVIRONMENT & SUSTAINABLE DEVELOPMENT. Contact: 638-1966	LOCATION: OLD GOVERNMENT FARM ROAD, SHAW PARK, TOBAGO.
TITLE: FABRICATION DRAWING	DRAWN BY: SS-TT	DATE STARTED: 01: 02: 2024	DATE FINISHED: 07: 02: 2024
		SCALE: N.T.S.	DWG NO: D/002/2024
			SHEET NO: F 01

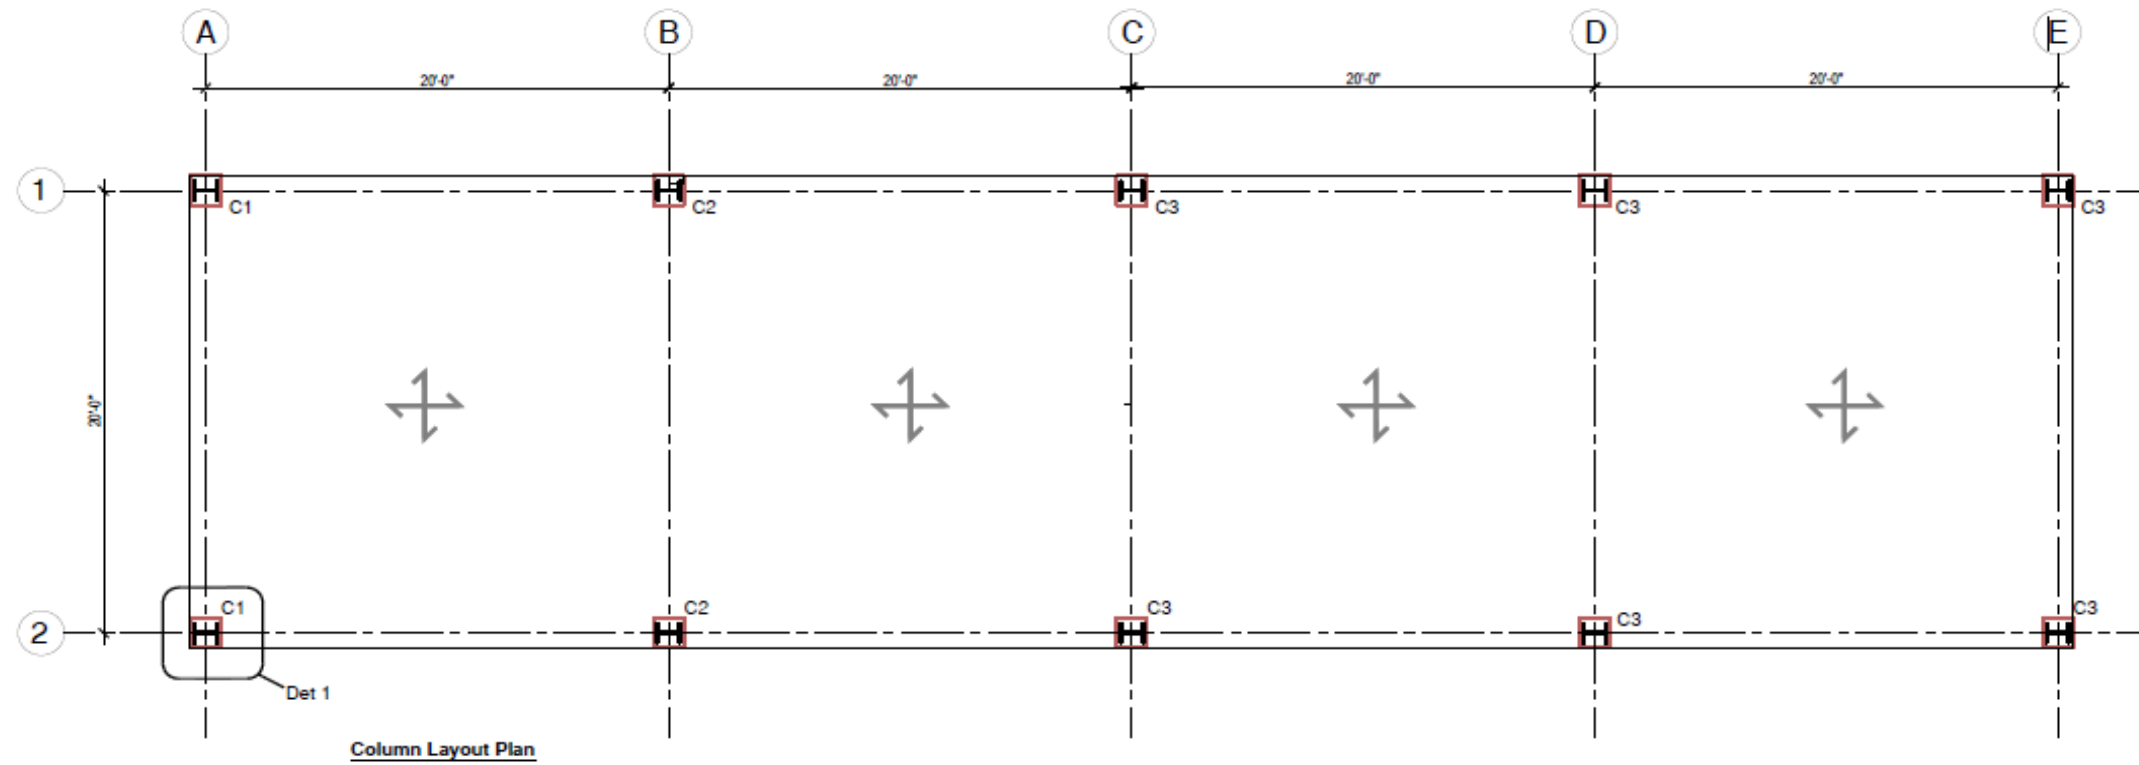

PROJECT: TRACTOR POOL	CLIENT:	COMPANY NAME: DIVISION OF FOOD SECURITY, NATURAL RESOURCES, THE ENVIRONMENT & SUSTAINABLE DEVELOPMENT. Contact: 639-1966	LOCATION: OLD GOVERNMENT FARM ROAD, SHAW PARK, TOBAGO.
TITLE: FABRICATION DRAWING	DRAWN BY: SS-TT	DATE STARTED: 01: 02: 2024	DATE FINISHED: 07: 02: 2024
		SCALE: N.T.S.	JOB NO.: D/002/2024
			SHEET NO.: F 01

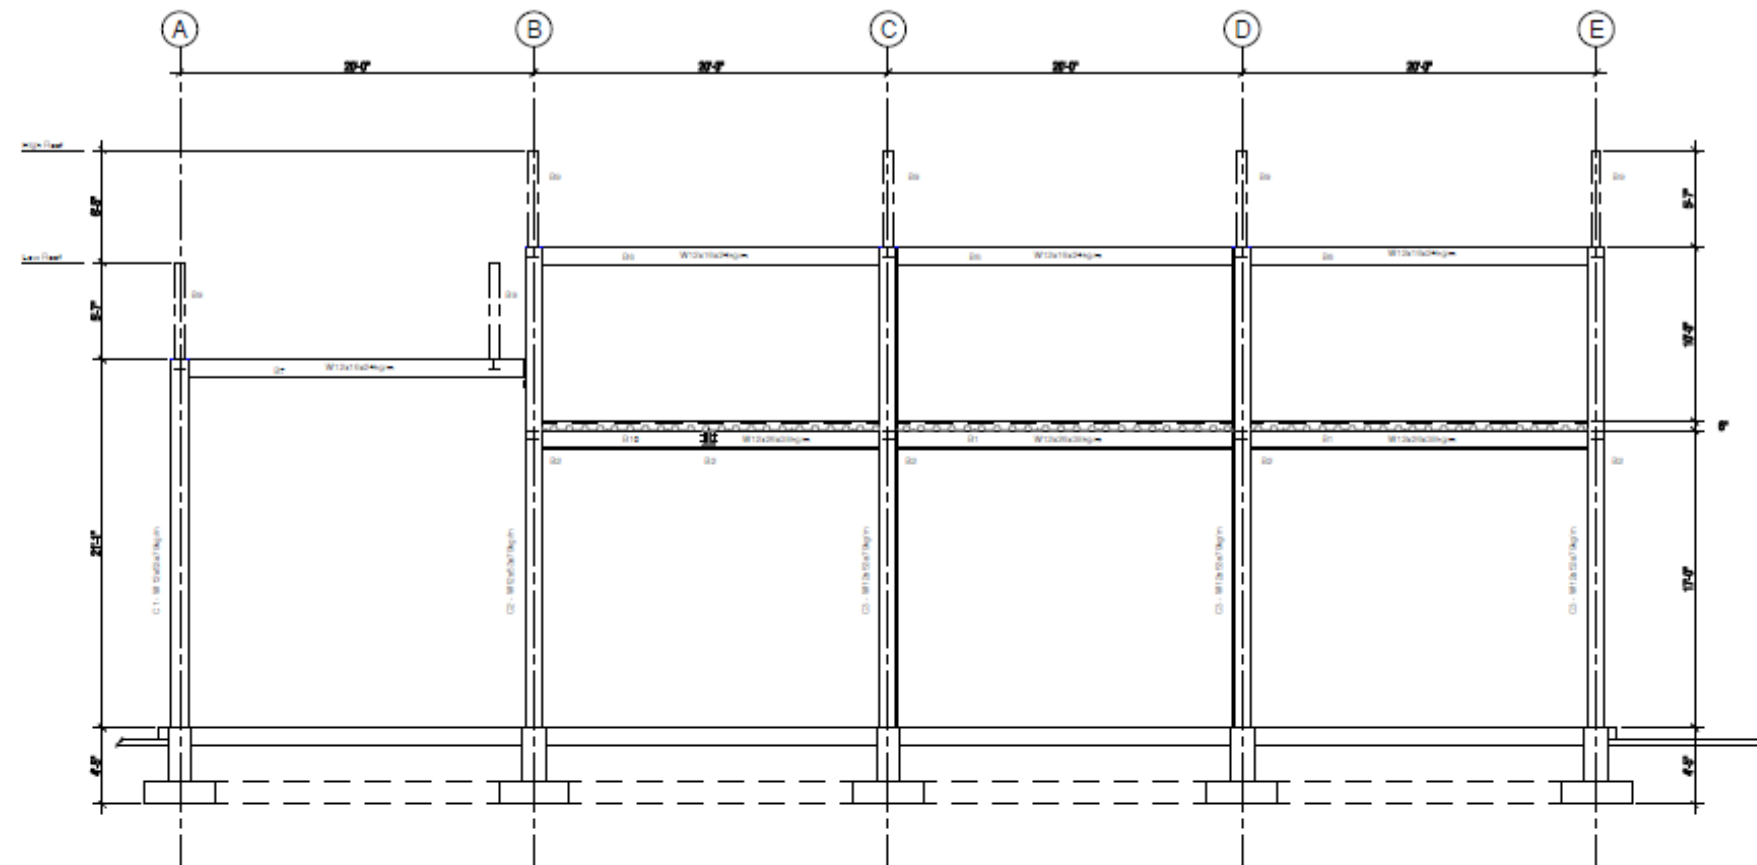


Grid Line 1 & 2

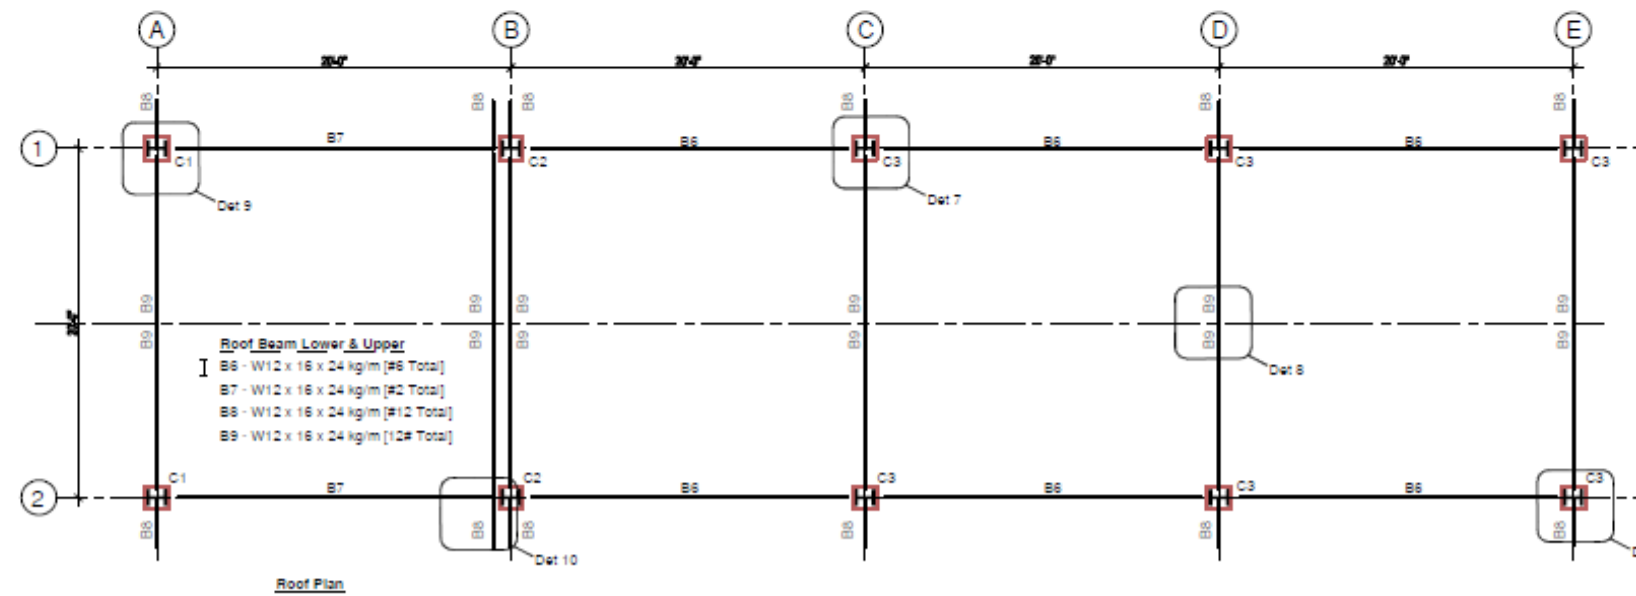


Roof Plan

PROJECT TRACTOR POOL	CLIENT SS-TT	DRAWING NAME DIVISION OF FOOD SECURITY, NATURAL RESOURCES, THE ENVIRONMENT & SUSTAINABLE DEVELOPMENT. Contact: 638-1966	LOCATION OLD GOVERNMENT FARM ROAD, SHAW PARK, TOBAGO.
TITLE FABRICATION DRAWING	DRAWING NO. SS-TT	DATE STARTED 01: 02: 2024	DATE FINISHED 07: 02: 2024
		SCALE N.T.S.	JOB NO. D/002/2024
		SHEET NO. F 02	

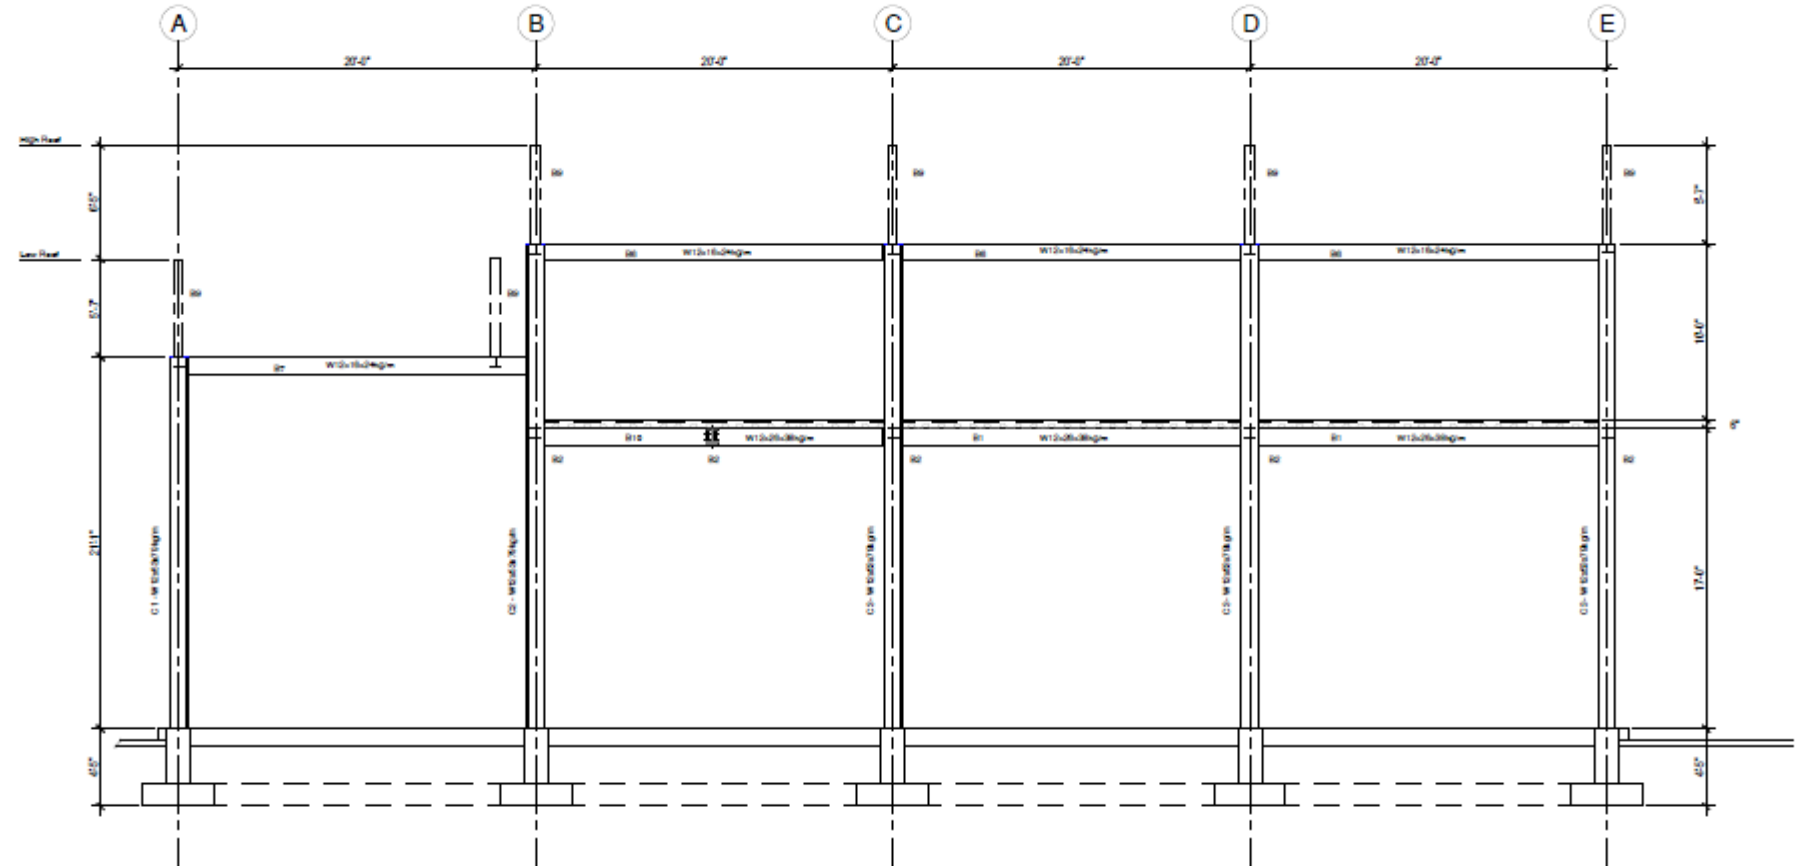


Grid Line 1 & 2

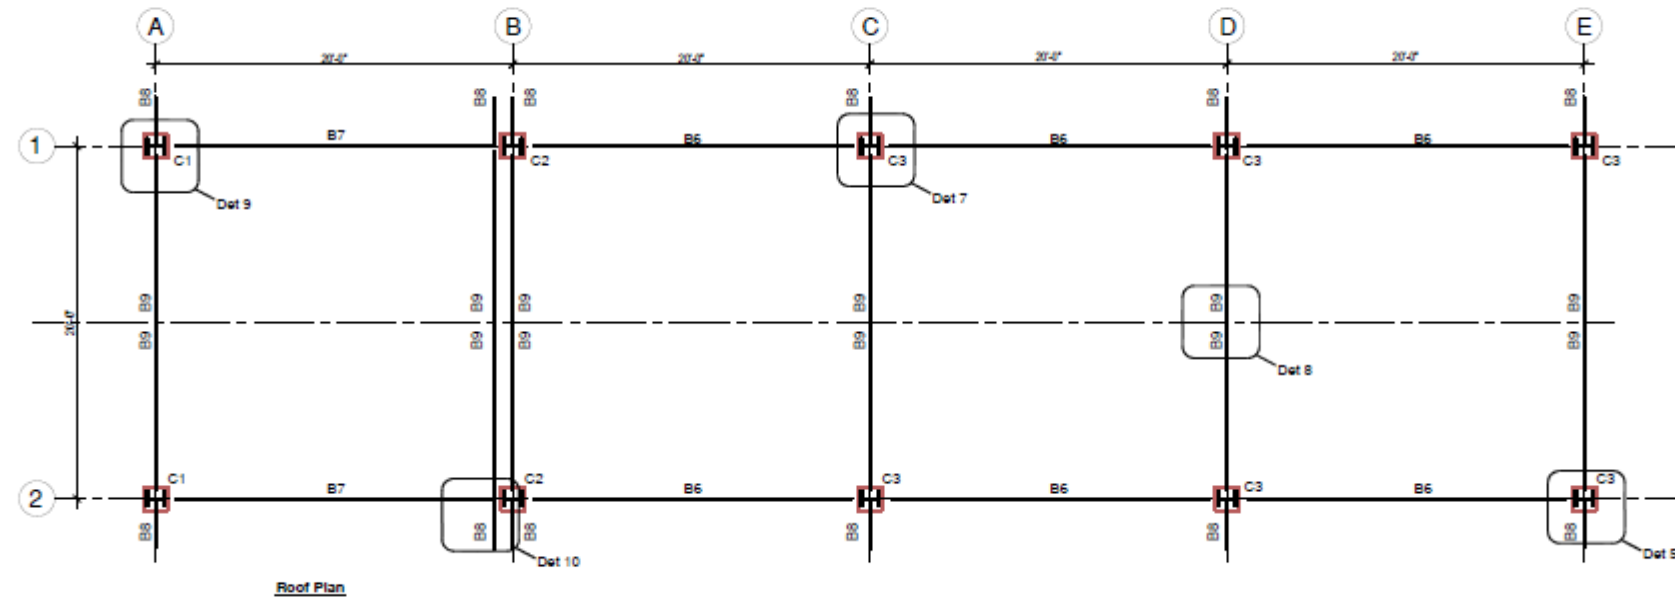


Roof Plan


PROJECT: TRACTOR POOL	CLIENT:	COMPANY NAME: DIVISION OF FOOD SECURITY, NATURAL RESOURCES, THE ENVIRONMENT & SUSTAINABLE DEVELOPMENT. Contact: 639-1966	LOCATION: OLD GOVERNMENT FARM ROAD, SHAW PARK, TOBAGO.
TITLE: FABRICATION DRAWING	DRAWN BY: SS-TT	DATE STARTED: 01-02-2024	DATE FINISHED: 07-02-2024
		SCALE: N.T.S.	JOB NO.: D/002/2024
			SHEET NO.: F 02

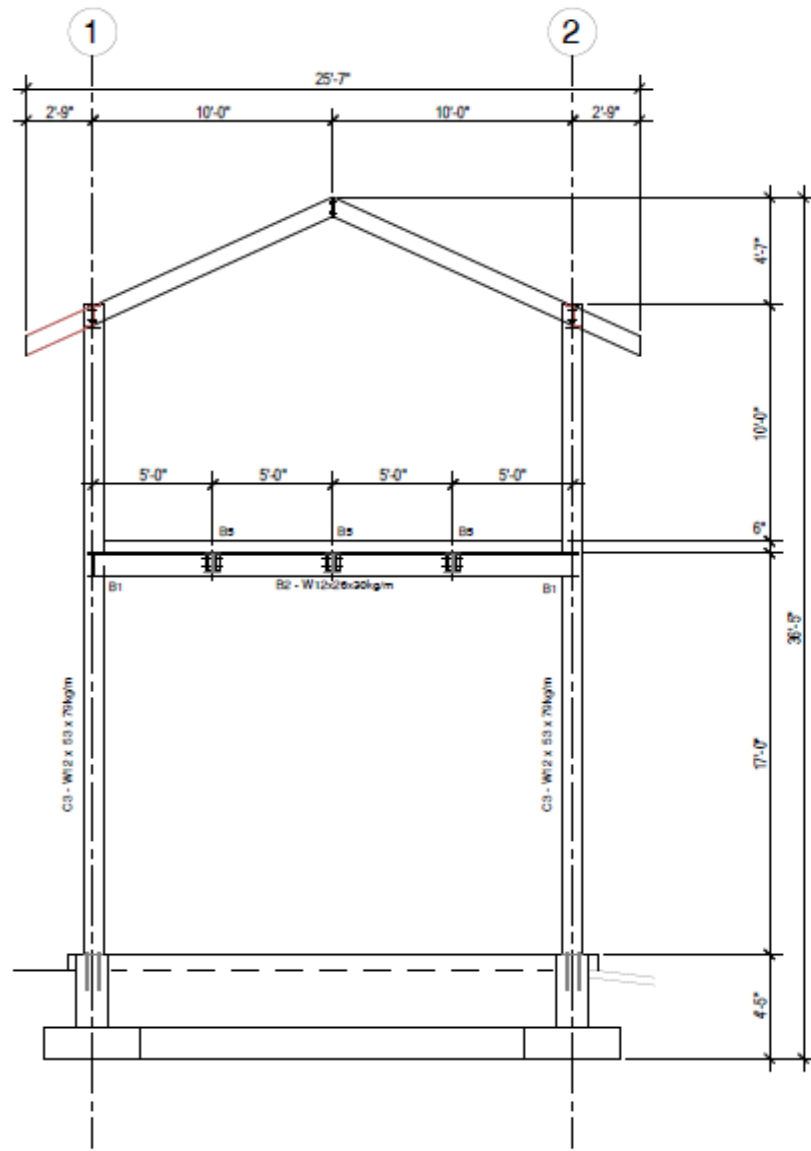

Grid Line C, D & E


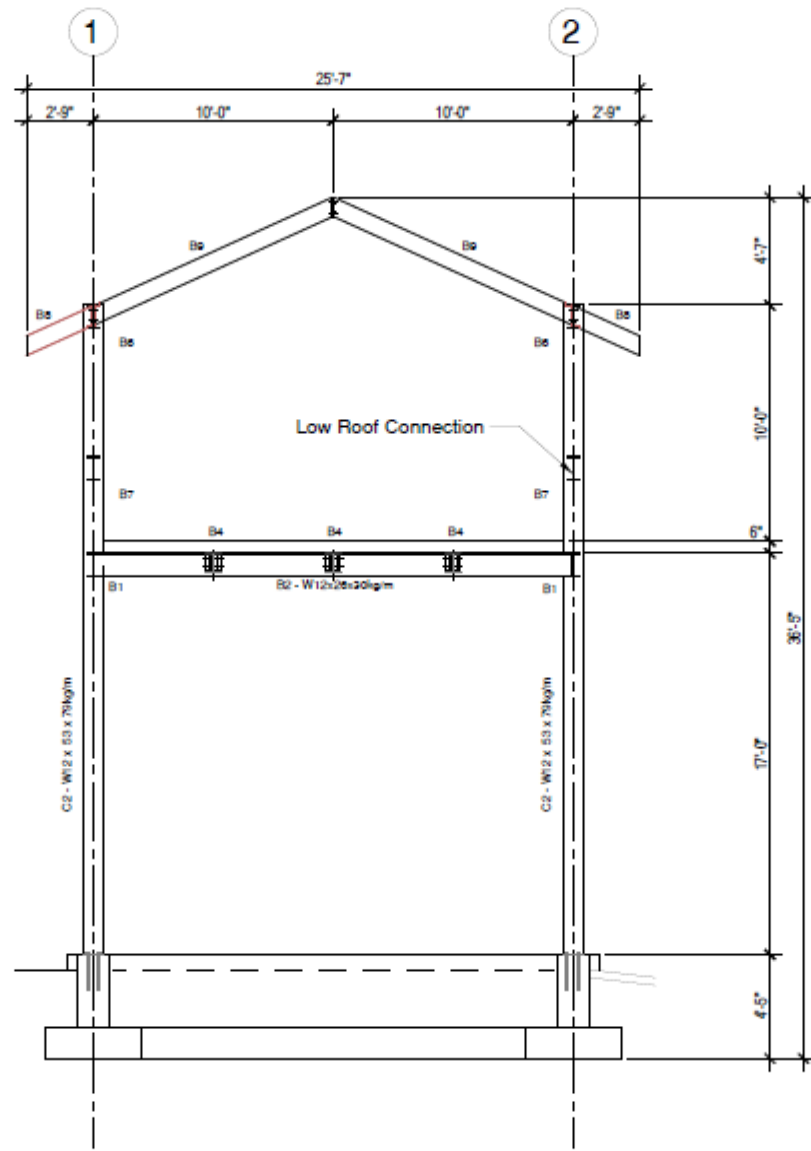


Grid Line B

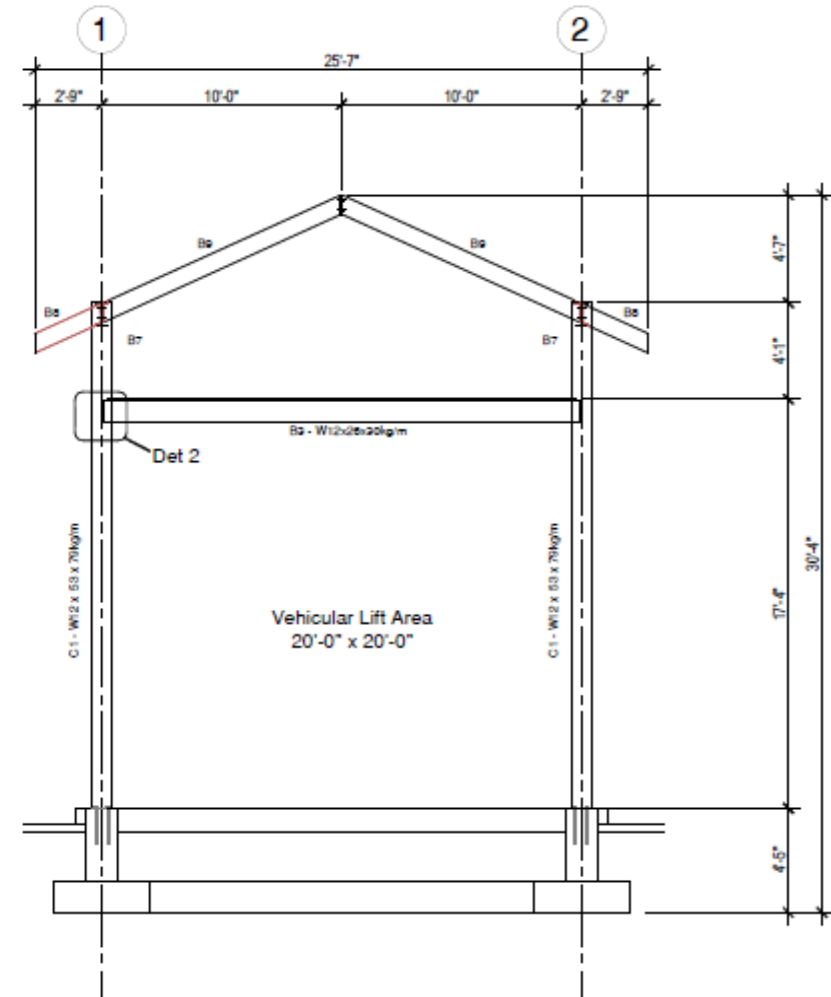


Grid Line A


PROJECT: TRACTOR POOL	CLIENT:	COMPANY NAME: DIVISION OF FOOD SECURITY, NATURAL RESOURCES, THE ENVIRONMENT & SUSTAINABLE DEVELOPMENT. Contact: 639-1966	LOCATION: OLD GOVERNMENT FARM ROAD, SHAW PARK, TOBAGO.
TITLE: FABRICATION DRAWING	DRAWN BY: SS-TT	DATE STARTED: 01-02-2024	DATE FINISHED: 07-02-2024
		SCALE: N.T.S.	DRAWING NO: D/002/2024
			SHEET NO: F 03

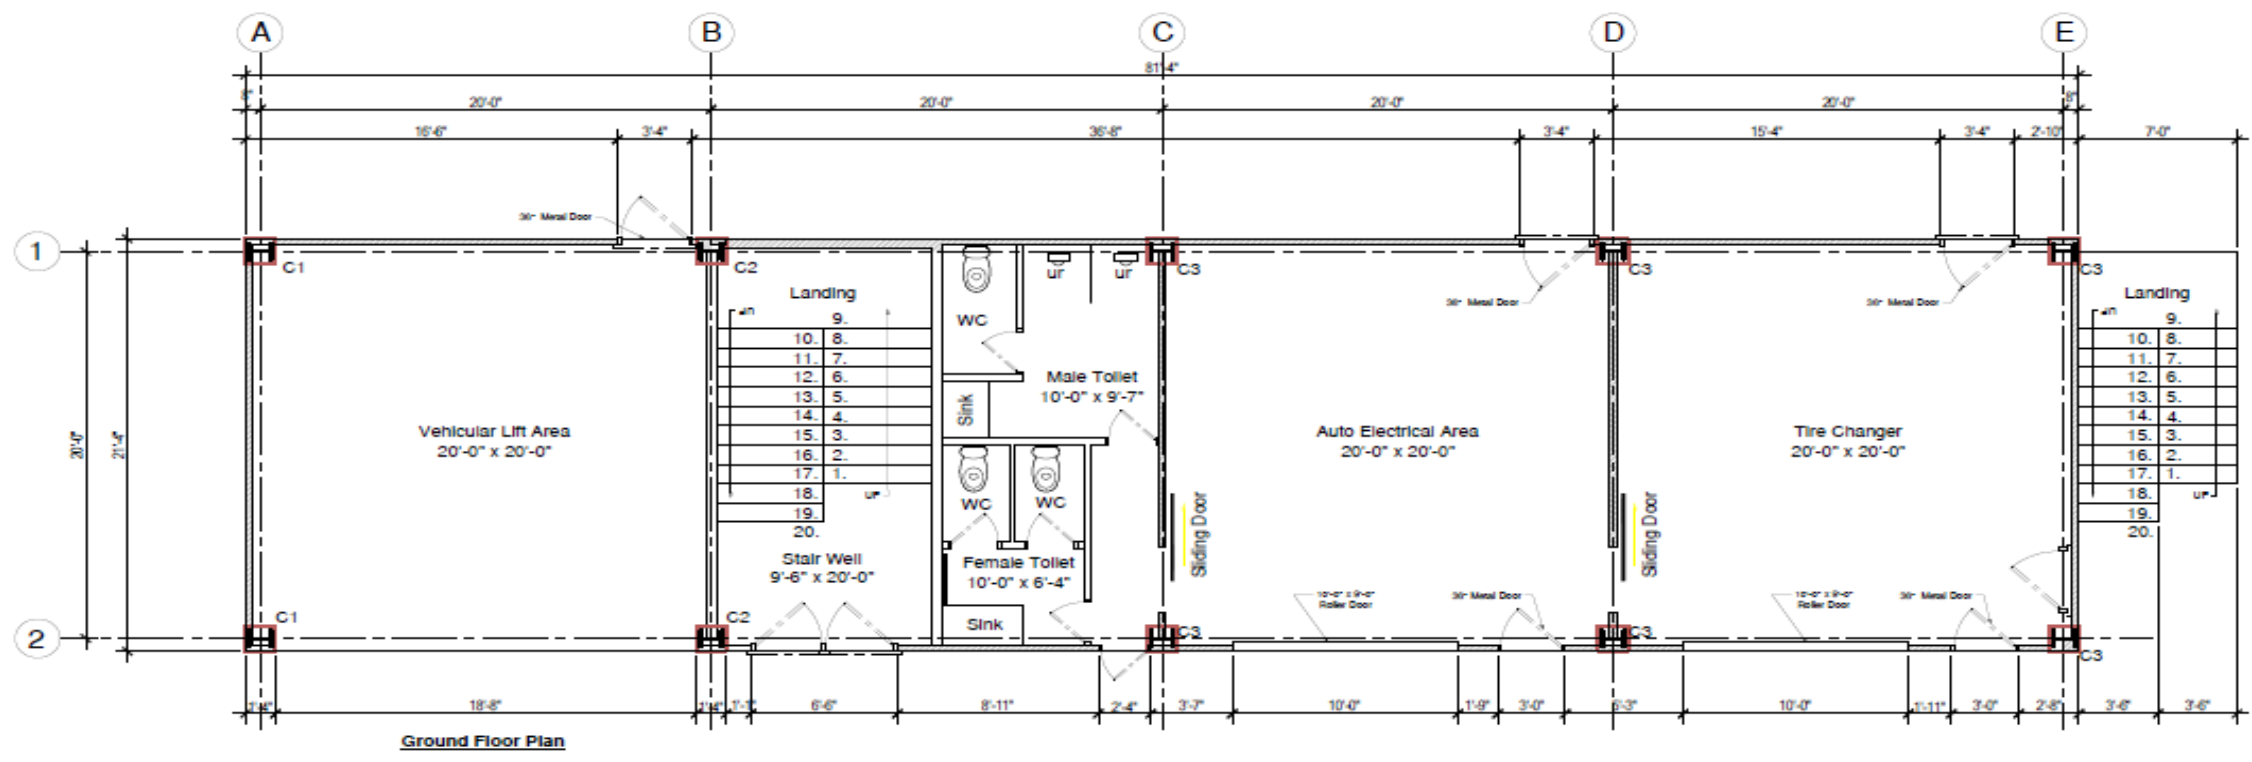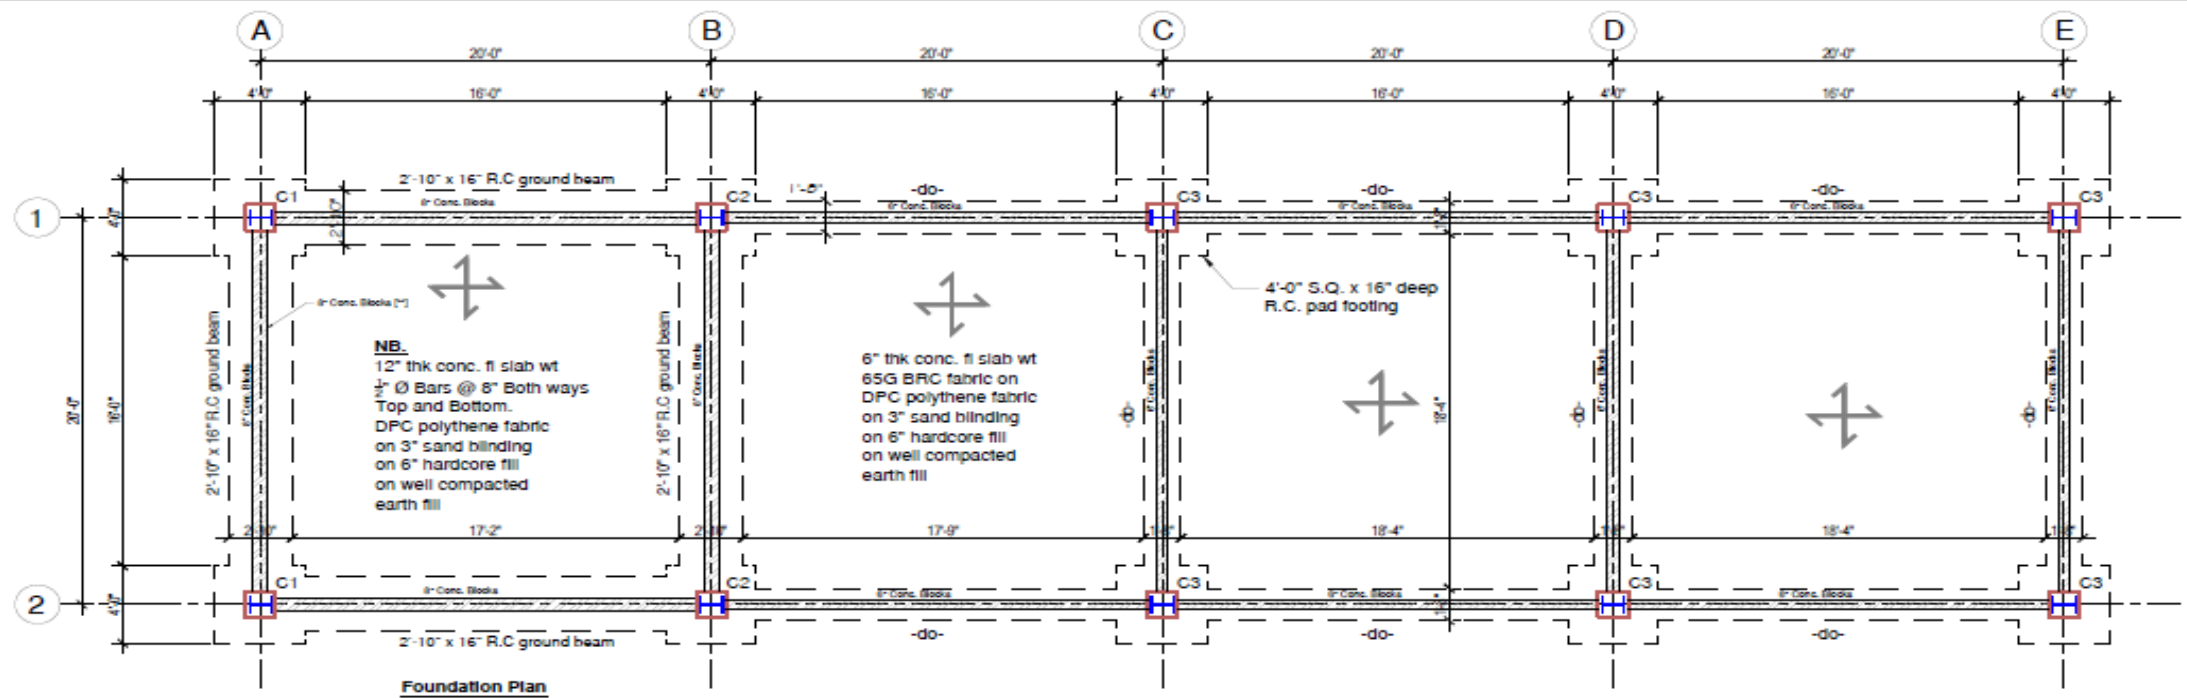

PROJECT: TRACTOR POOL	DESIGNED BY: CHRISTOPHER PERRY	COMPANY NAME: DIVISION OF FOOD SECURITY, NATURAL RESOURCES, THE ENVIRONMENT & SUSTAINABLE DEVELOPMENT. Contact: 639-1966	LOCATION: OLD GOVERNMENT FARM ROAD, SHAW PARK, TOBAGO.
TITLE: FOUNDATION & FLOOR PLAN	DRAWN BY: SS-TT	DATE SUBMITTED: 01.02.2024	DATE APPROVED: 07.02.2024
		SCALE: N.T.S.	DWG NO: D/002/2024
			SHEET NO: ST 01

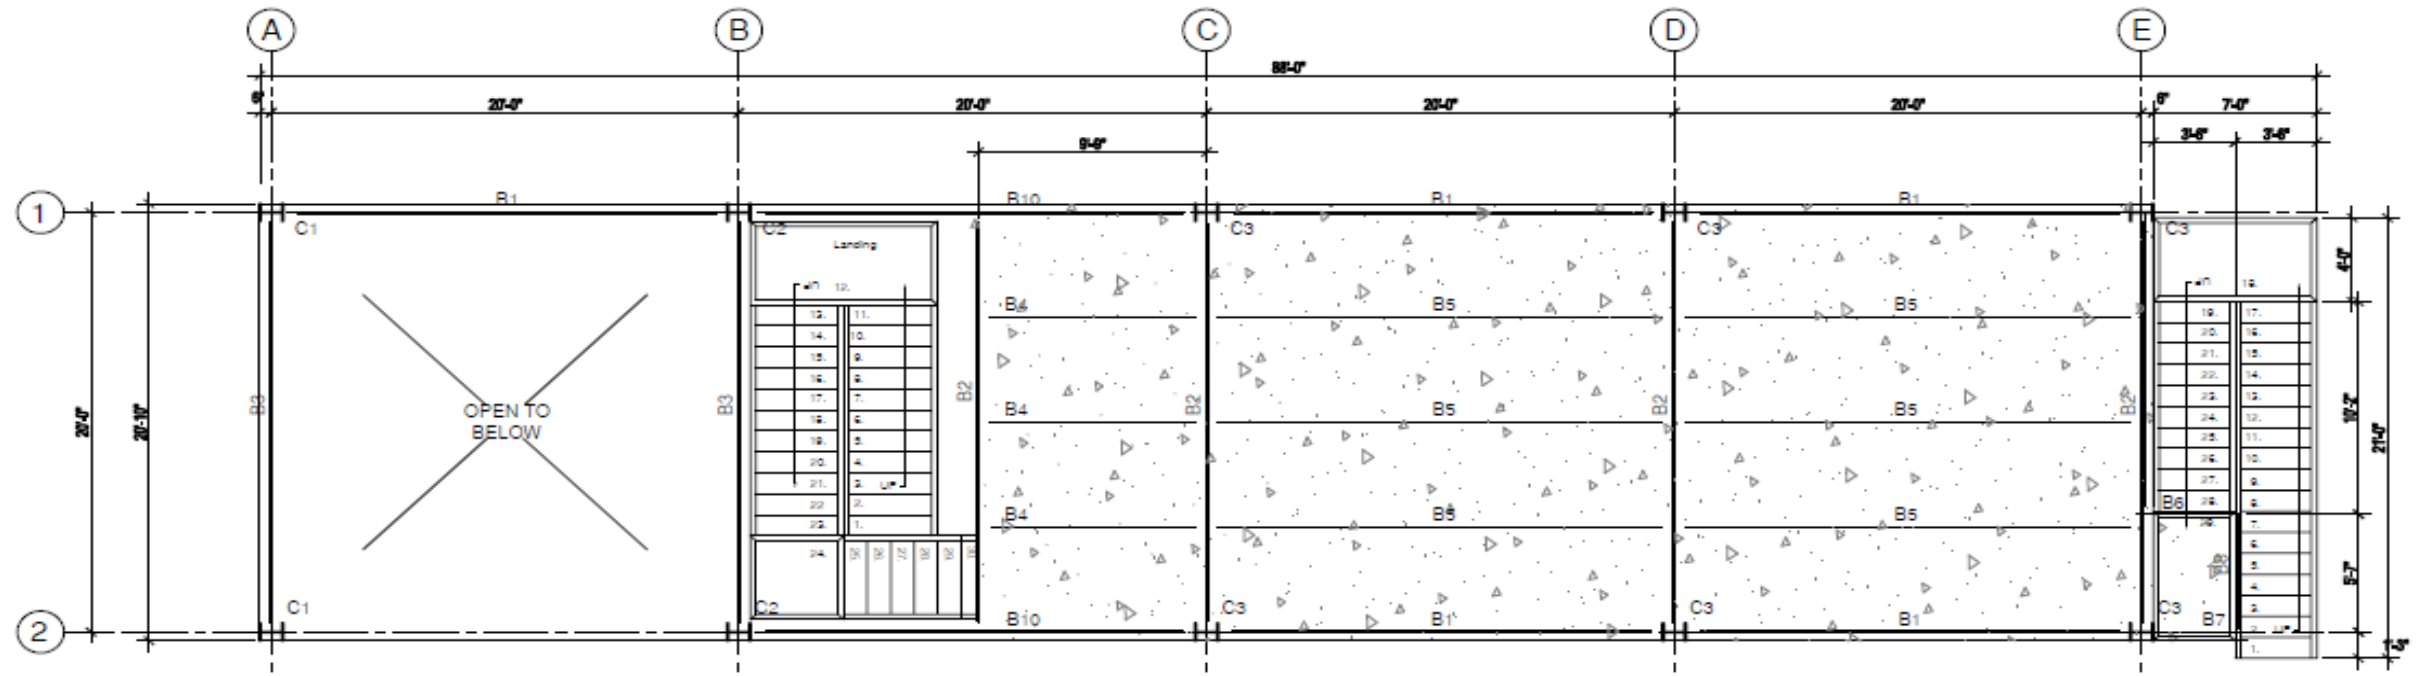


Mezz. Plan

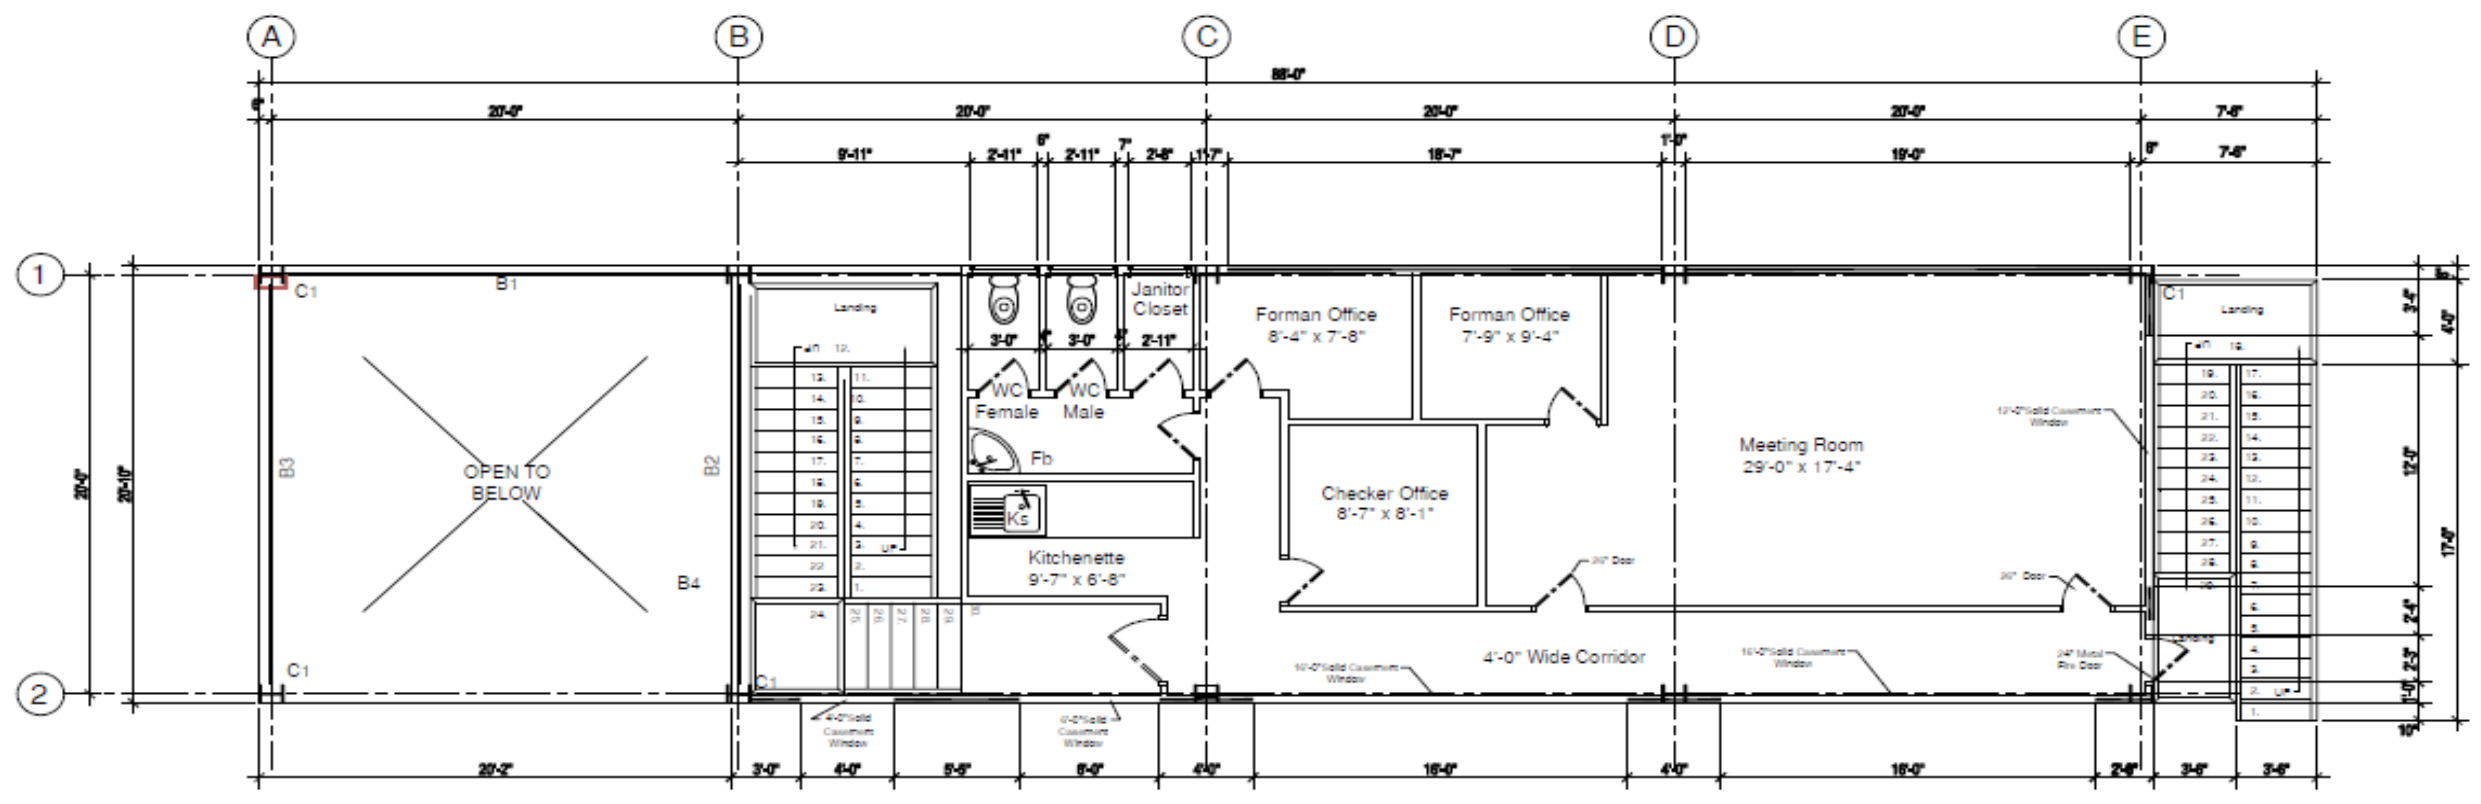


1st Floor Mezz. Plan


PROJECT TRACTOR POOL	CLIENT SS-TT	APPROVED BY DIVISION OF FOOD SECURITY, NATURAL RESOURCES, THE ENVIRONMENT & SUSTAINABLE DEVELOPMENT. Contact: 639-1966	LOCATION OLD GOVERNMENT FARM ROAD, SHAW PARK, TOBAGO.
TITLE MEZZ. STEEL PLAN & MEZZ FLOOR LAYOUT	DESIGNER SS-TT	DATE STARTED 01: 02: 2024	DATE FINISHED 07: 02: 2024
		SCALE N.T.S.	JOB NO. D/002/2024
			SHEET NO. ST 02

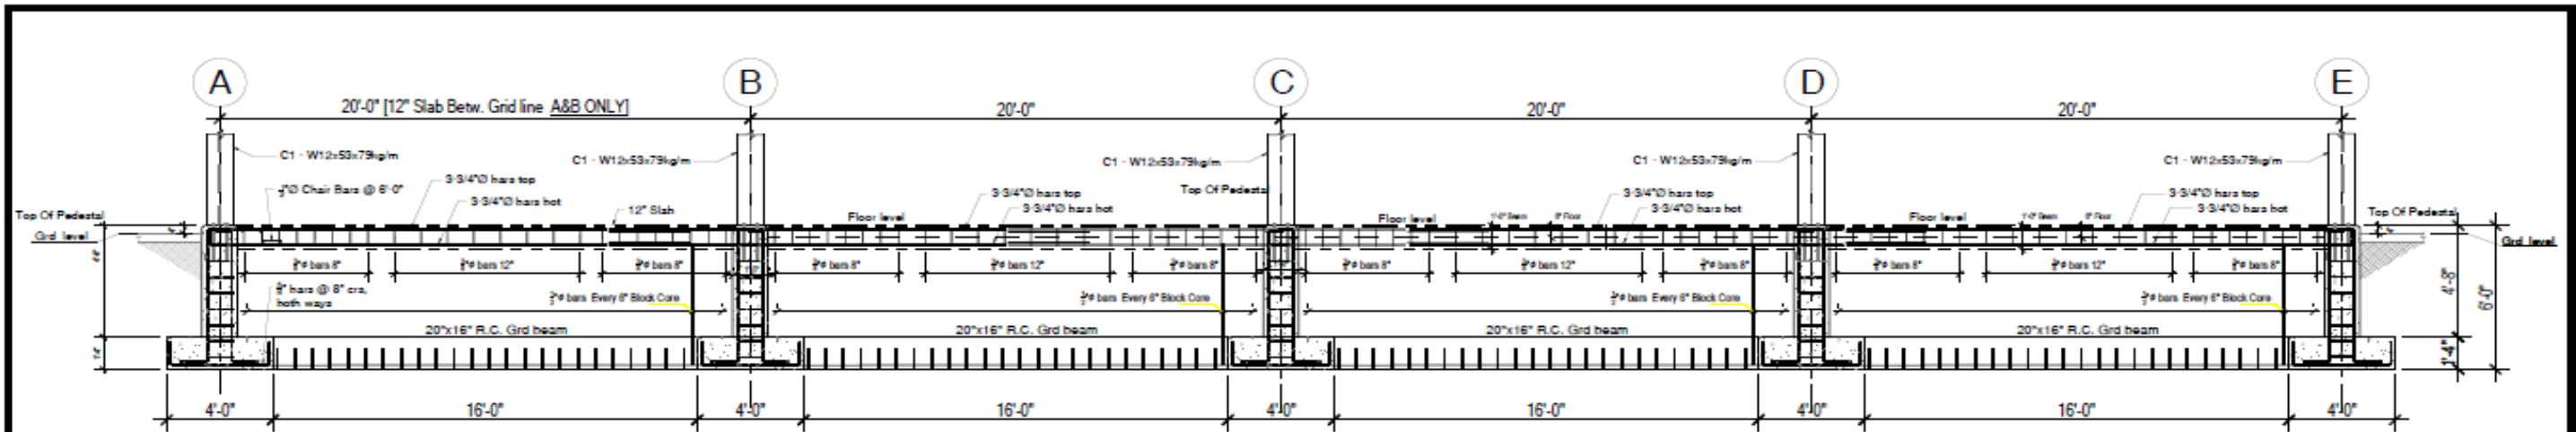


Typical Beam Detail Along Gridline 1&2

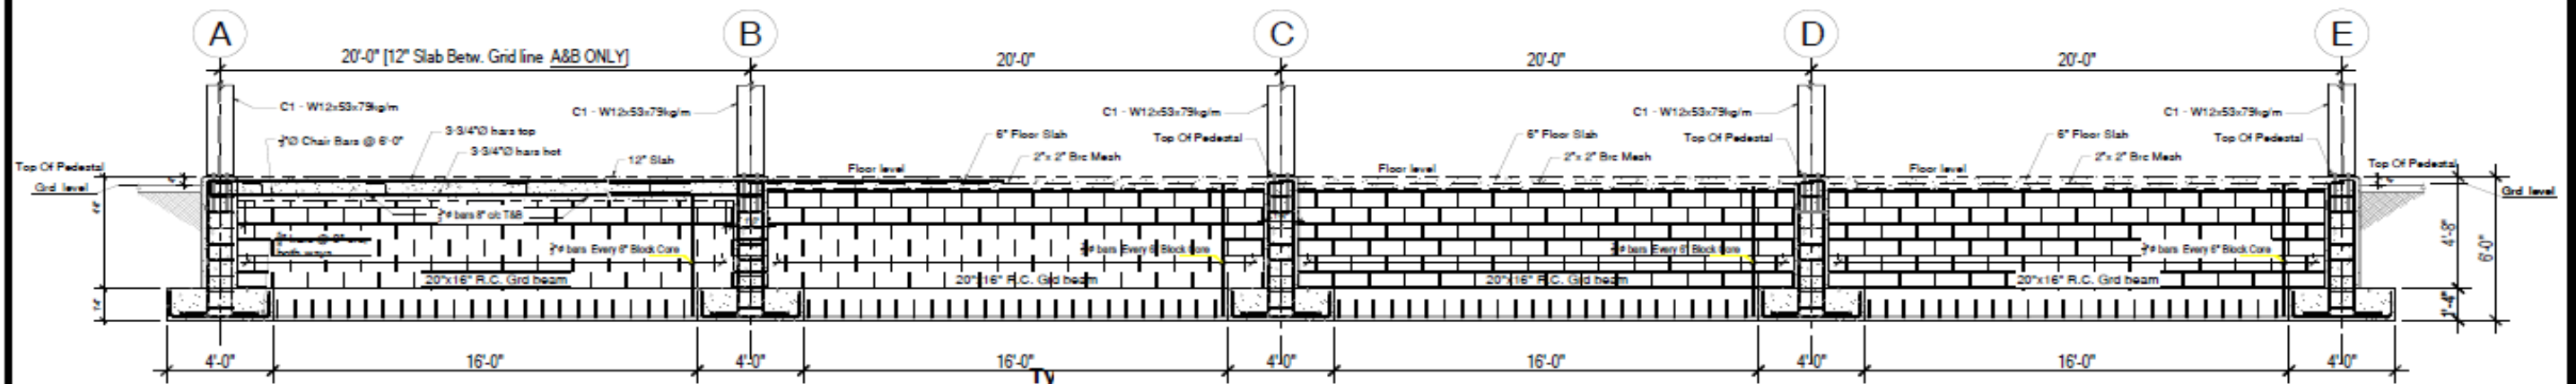


Typical Beam Detail Along Gridline 1&2

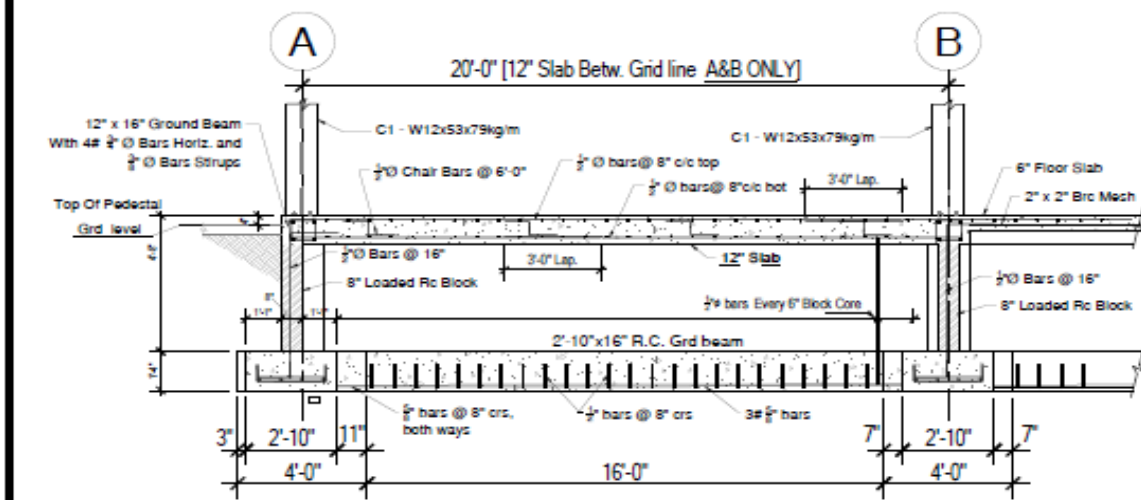



Section 1-1

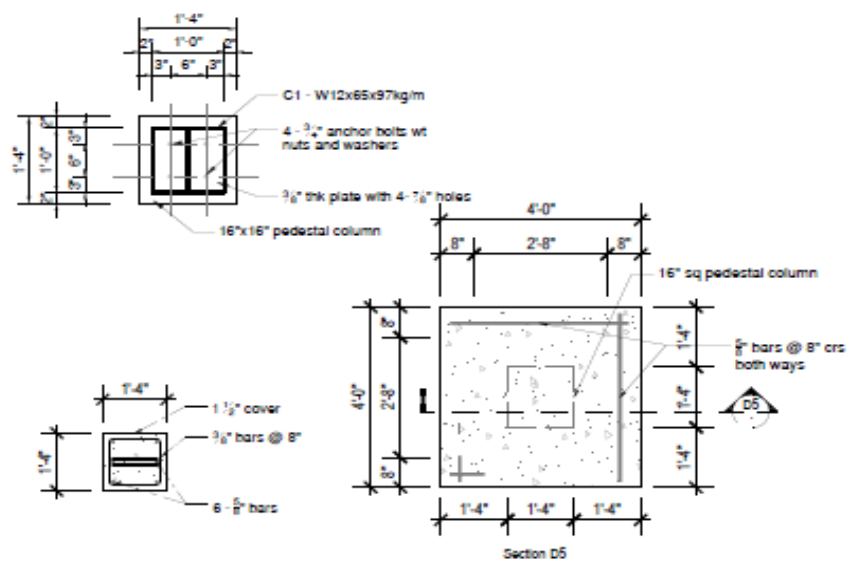

Section D5

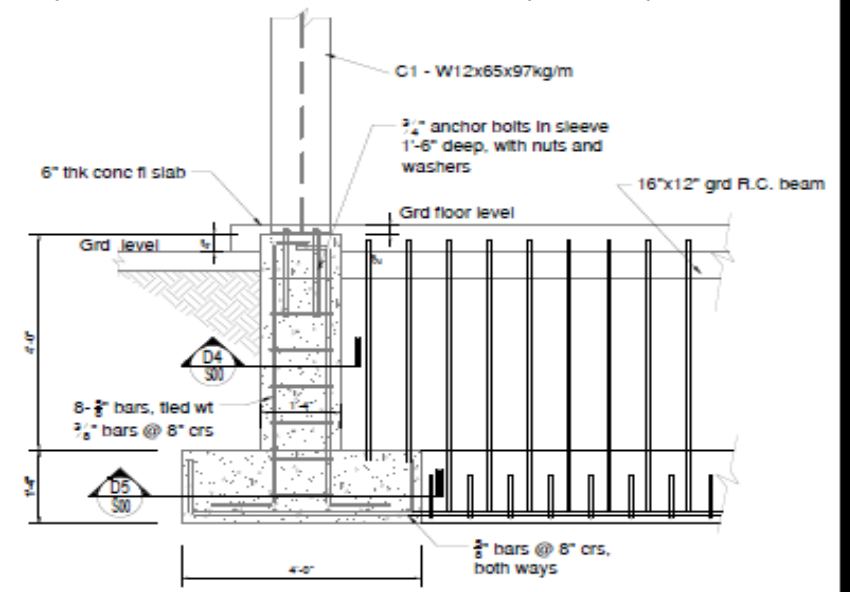


PROJECT: TRACTOR POOL	CLIENT:	COMPANY NAME: DIVISION OF FOOD SECURITY, NATURAL RESOURCES, THE ENVIRONMENT & SUSTAINABLE DEVELOPMENT.	LOCATION: OLD GOVERNMENT FARM ROAD, SHAW PARK, TOBAGO.
TITLE: GROUND BEAM DETAILS	DRAWN BY: SS-TT	Contact: 639-1966	DATE STARTED: 01-02-2024 DATE FINISHED: 07-02-2024 SCALE: N.T.S. JOB NO: D/002/2024 SHEET NO: ST 03

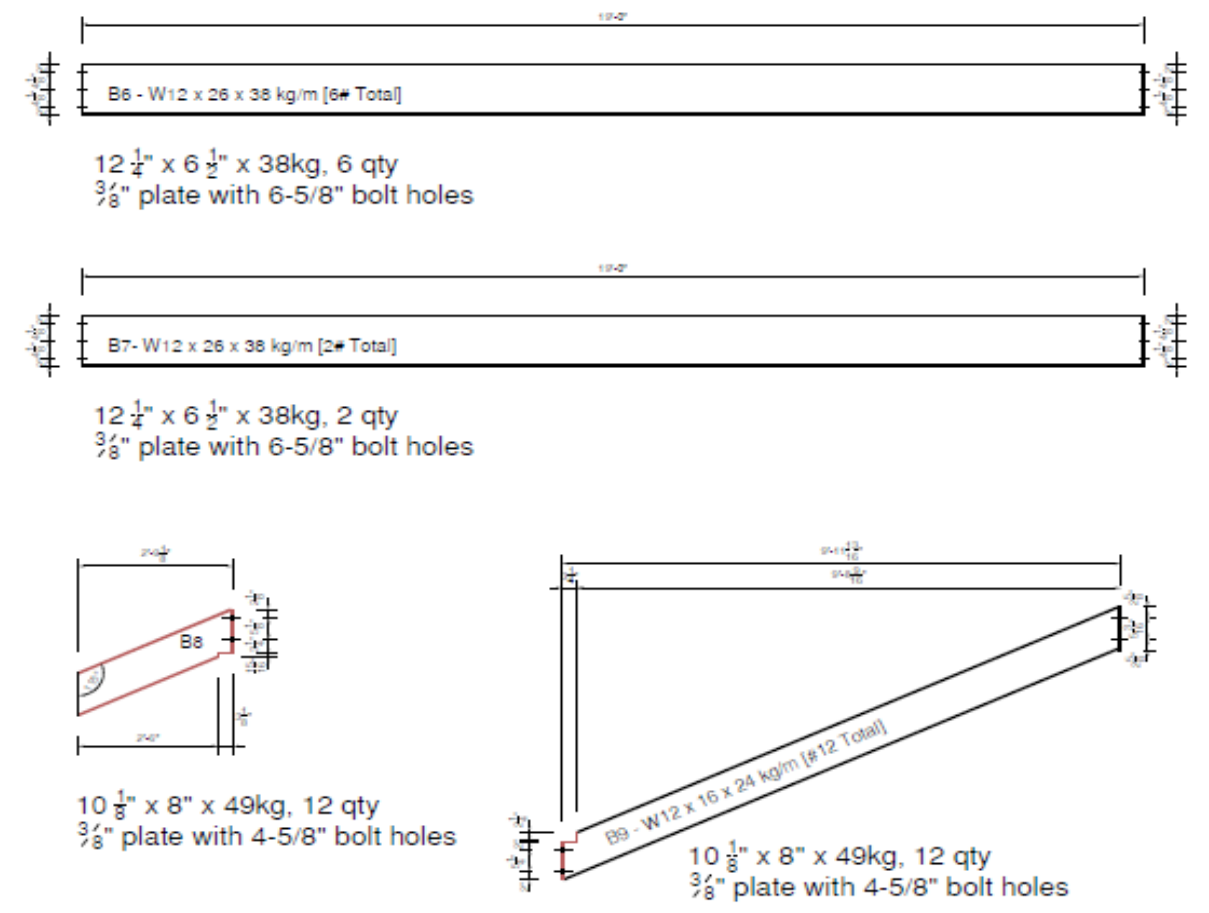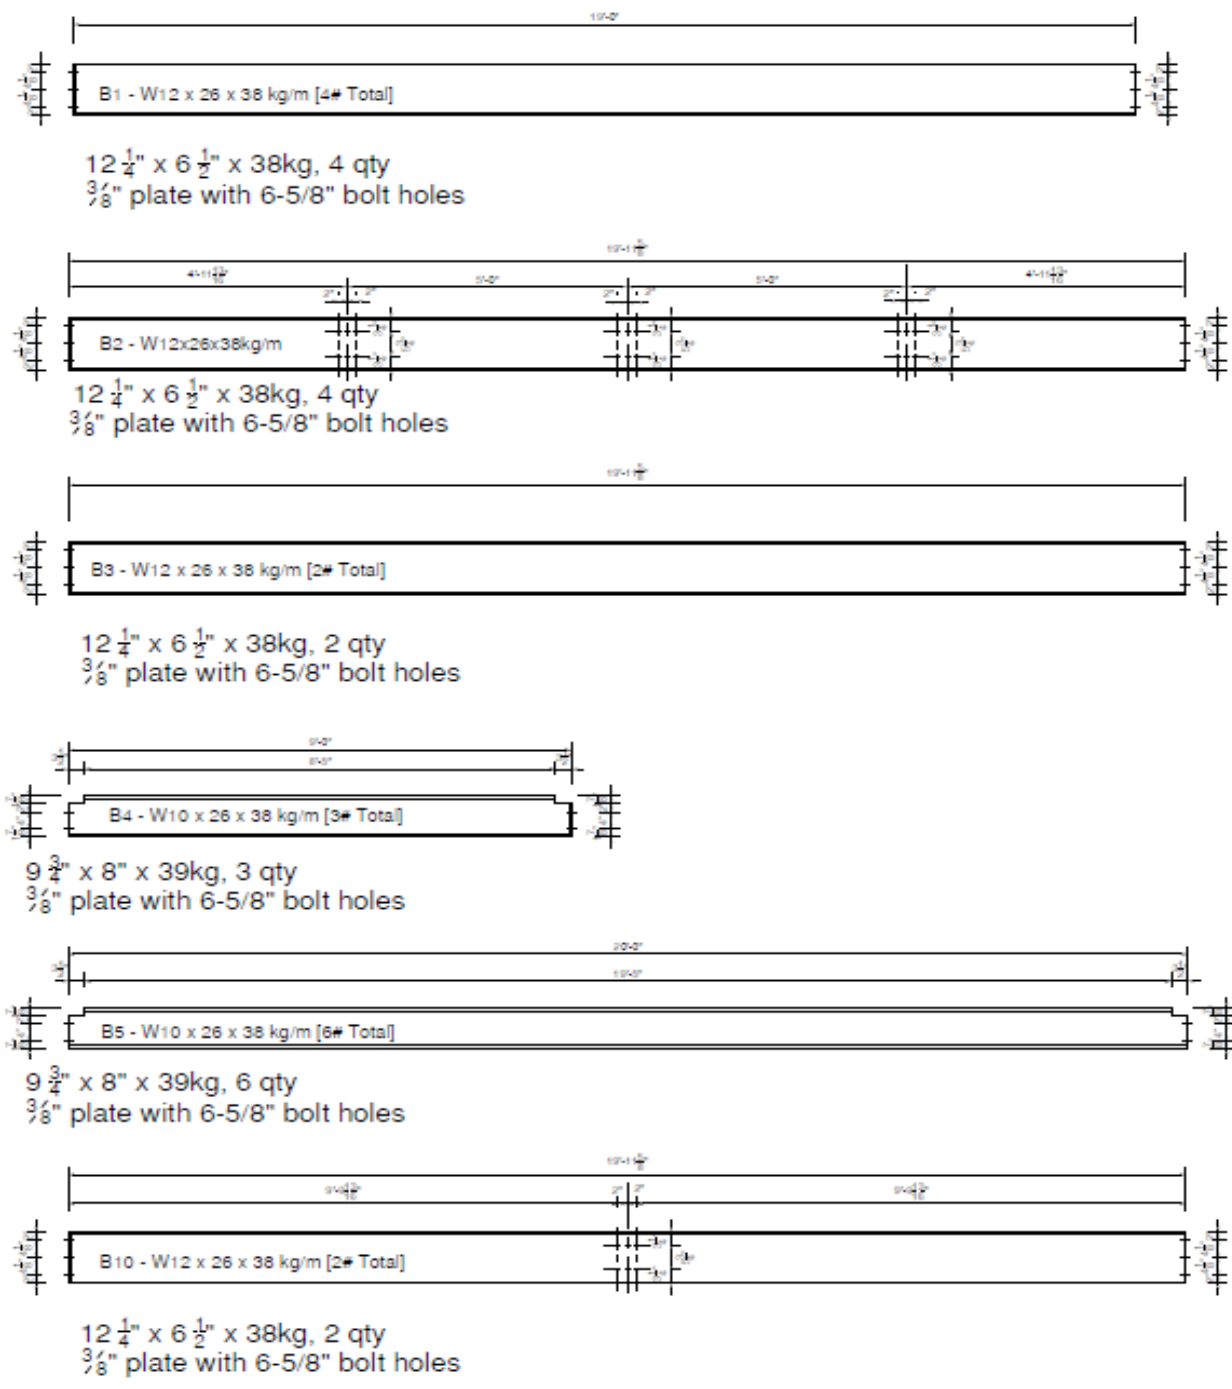


MEZZ FLOOR

ROOF


PROJECT TRACTOR POOL TIRE SHOP	CLIENT SS-TT	APPROVAL DIVISION OF FOOD SECURITY, NATURAL RESOURCES, THE ENVIRONMENT & SUSTAINABLE DEVELOPMENT. Contact: 638-1966	LOCATION OLD GOVERNMENT FARM ROAD, SHAW PARK, TOBAGO.
TITLE STEEL PLAN	DATE STARTED 01: 02: 2024	DATE FINISHED 07: 02: 2024	SCALE N.T.S.
	JOB NO. D/002/2024	SHEET NO. ST 04	

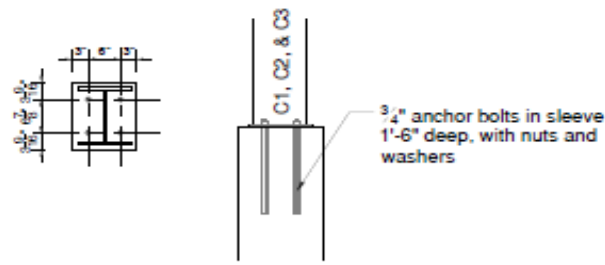


Detail 1

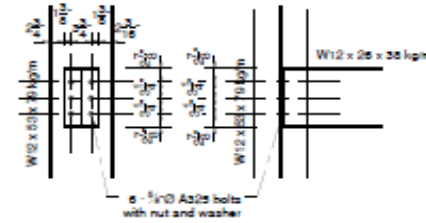


Detail 2

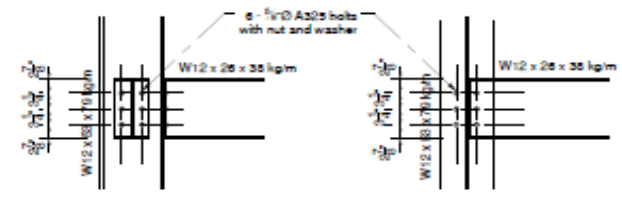

Detail 3

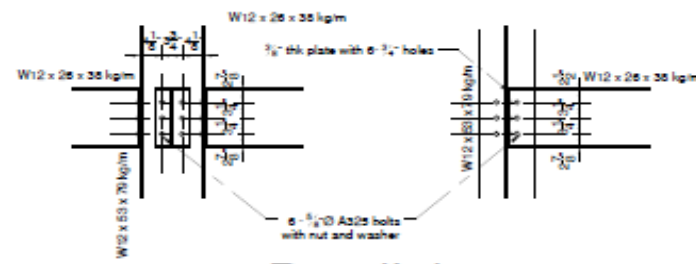


Detail 4

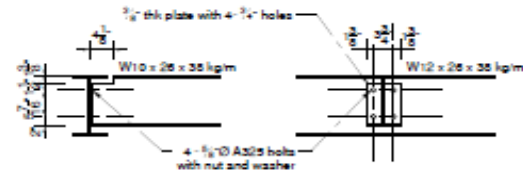


Detail 5




Detail 6

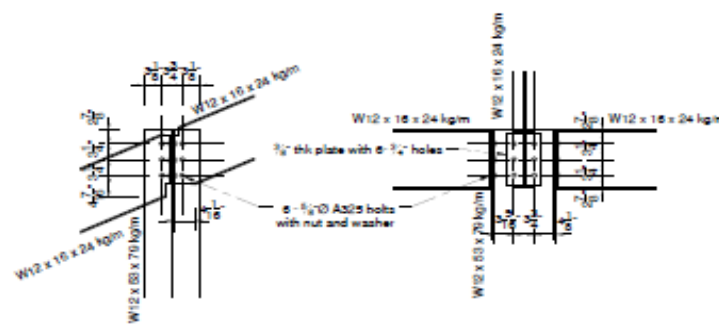


Detail 7

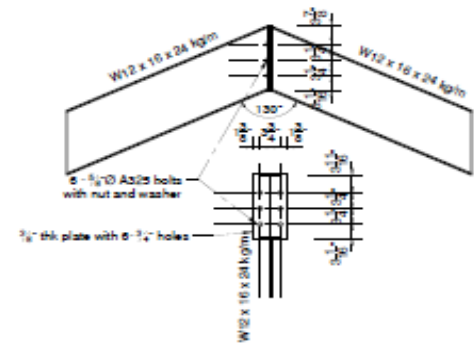

Detail 8

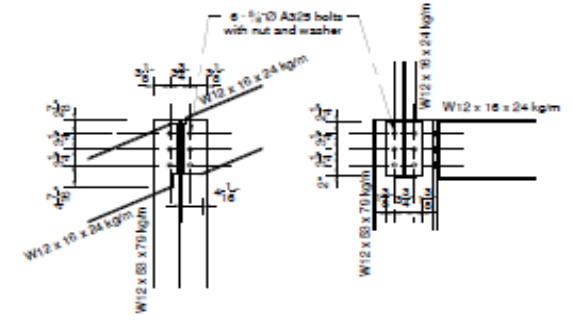

Detail 9

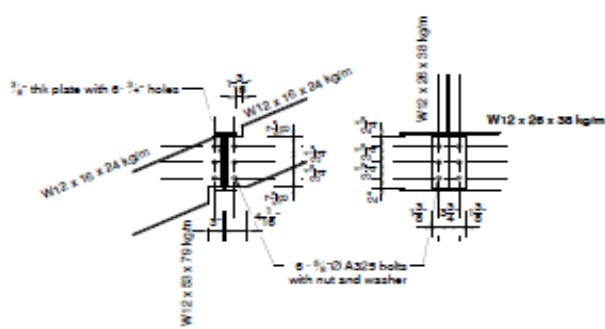

Detail 10

C1 - W12 x 53 x 79 kg/m
 C2 - W12 x 53 x 79 kg/m
 C3 - W12 x 53 x 79 kg/m

W12 x 53 x 79 kg/m

W12 x 26 x 38 kg/m

W12 x 16 x 24 kg/m

W10 x 26 x 38 kg/m

B1 - W12 x 26 x 38 kg/m

B2 - W12 x 26 x 38 kg/m

B3 - W12 x 26 x 38 kg/m

B10 - W12 x 26 x 38 kg/m

B6 - W12 x 16 x 24 kg/m

B7 - W12 x 16 x 24 kg/m


B8 - W12 x 16 x 24 kg/m

B9 - W12 x 16 x 24 kg/m


B4 - W10 x 26 x 38 kg/m

B5 - W10 x 26 x 38 kg/m

PROJECT: TRACTOR POOL	CLIENT:	COMPANY NAME: DIVISION OF FOOD SECURITY, NATURAL RESOURCES, THE ENVIRONMENT & SUSTAINABLE DEVELOPMENT. Contact: 639-1966	LOCATION: OLD GOVERNMENT FARM ROAD, SHAW PARK, TOBAGO.
TYPE: CROSS SECTIONS	DRAWN BY: SS-TT	DATE STARTED: 01. 02. 2024	DATE FINISHED: 07. 02. 2024
		SCALE: N.T.S.	SHEET NO.: D/002/2024
			SHEET NO.: ST 05

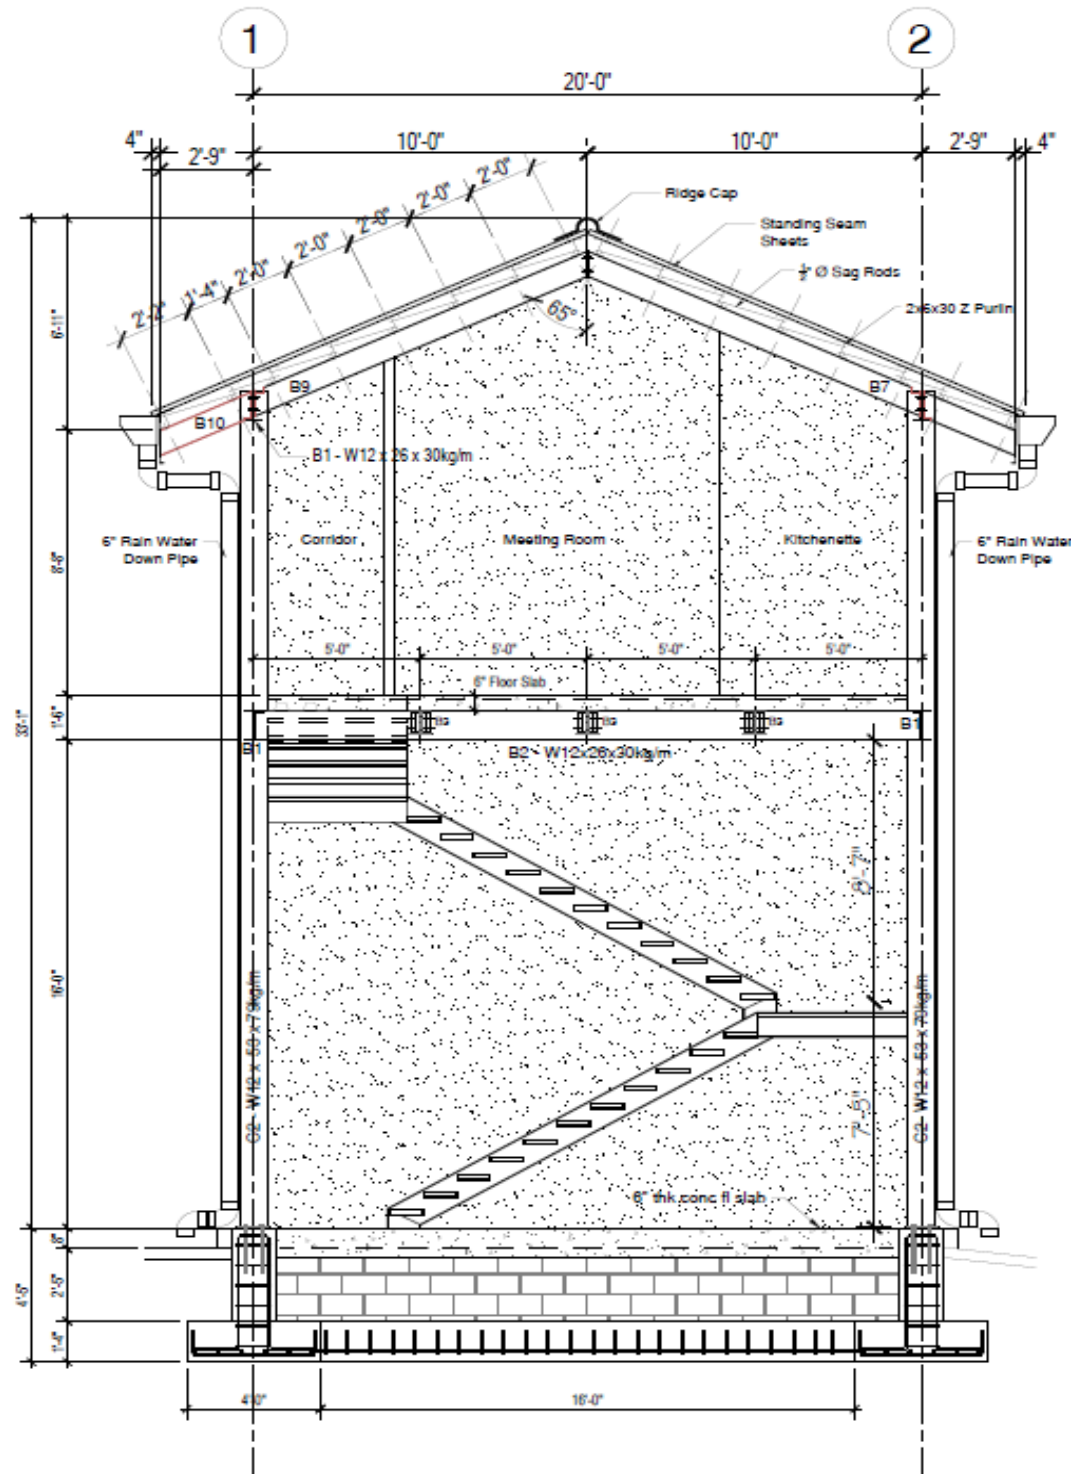


Section B-B



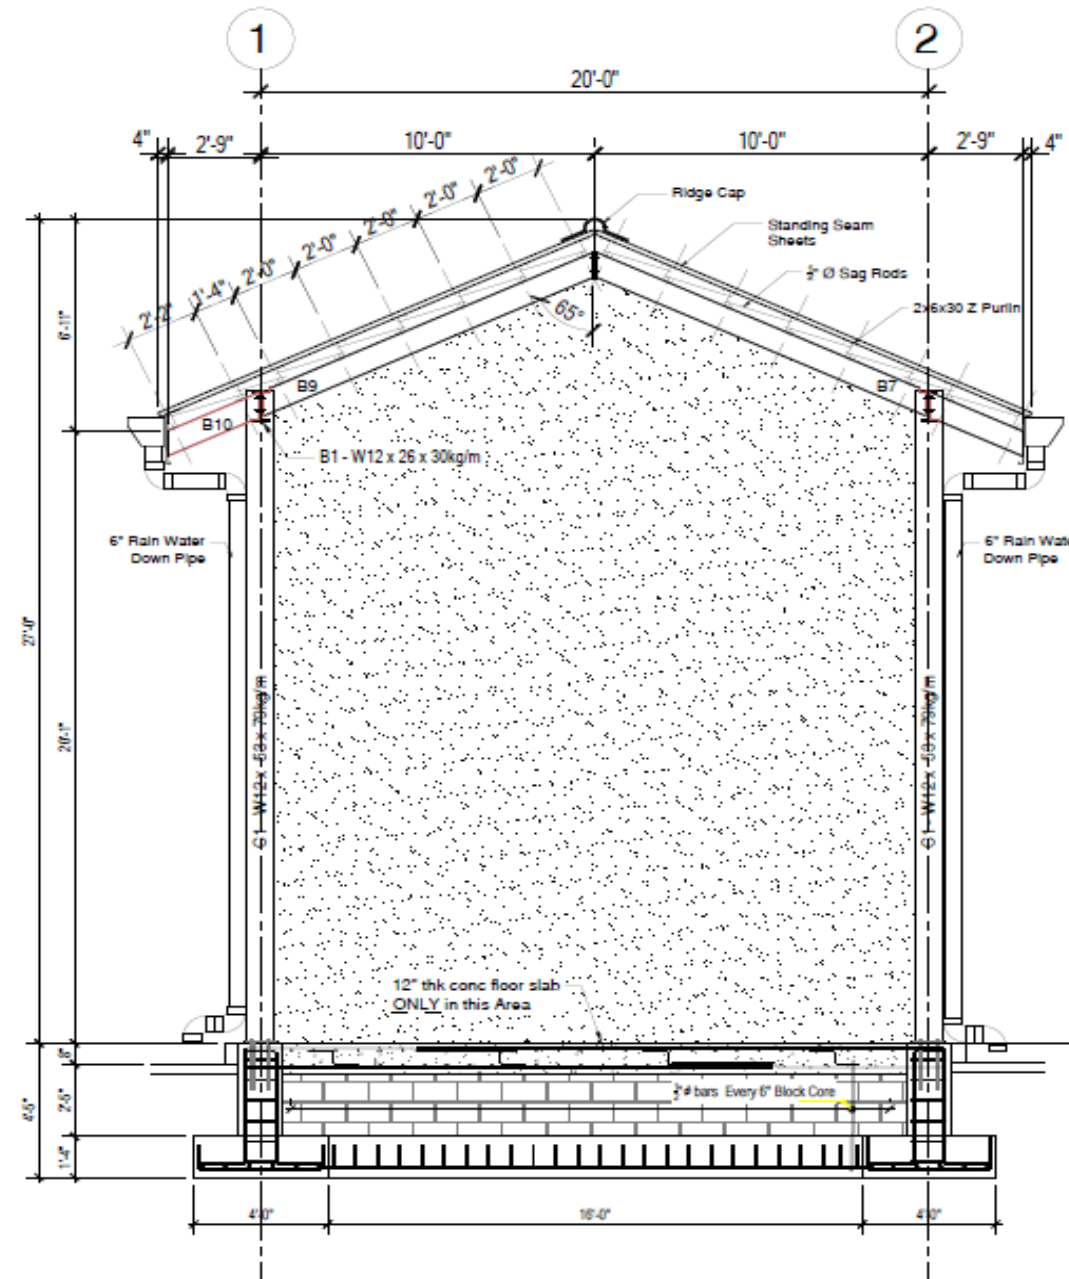


Section B-B




PROJECT: TRACTOR POOL	CLIENT: DIVISION OF FOOD SECURITY, NATURAL RESOURCES, THE ENVIRONMENT & SUSTAINABLE DEVELOPMENT.	LOCATION: OLD GOVERNMENT FARM ROAD, SHAW PARK, TOBAGO.
TITLE: CROSS SECTION	DRAWN BY: SS-TT	DATE STARTED: 01-02-2024
	CONTACT: 639-1966	DATE FINISHED: 07-02-2024
		SCALE: N.T.S.
		DWG NO: D/002/2024
		SHEET NO: ST 06

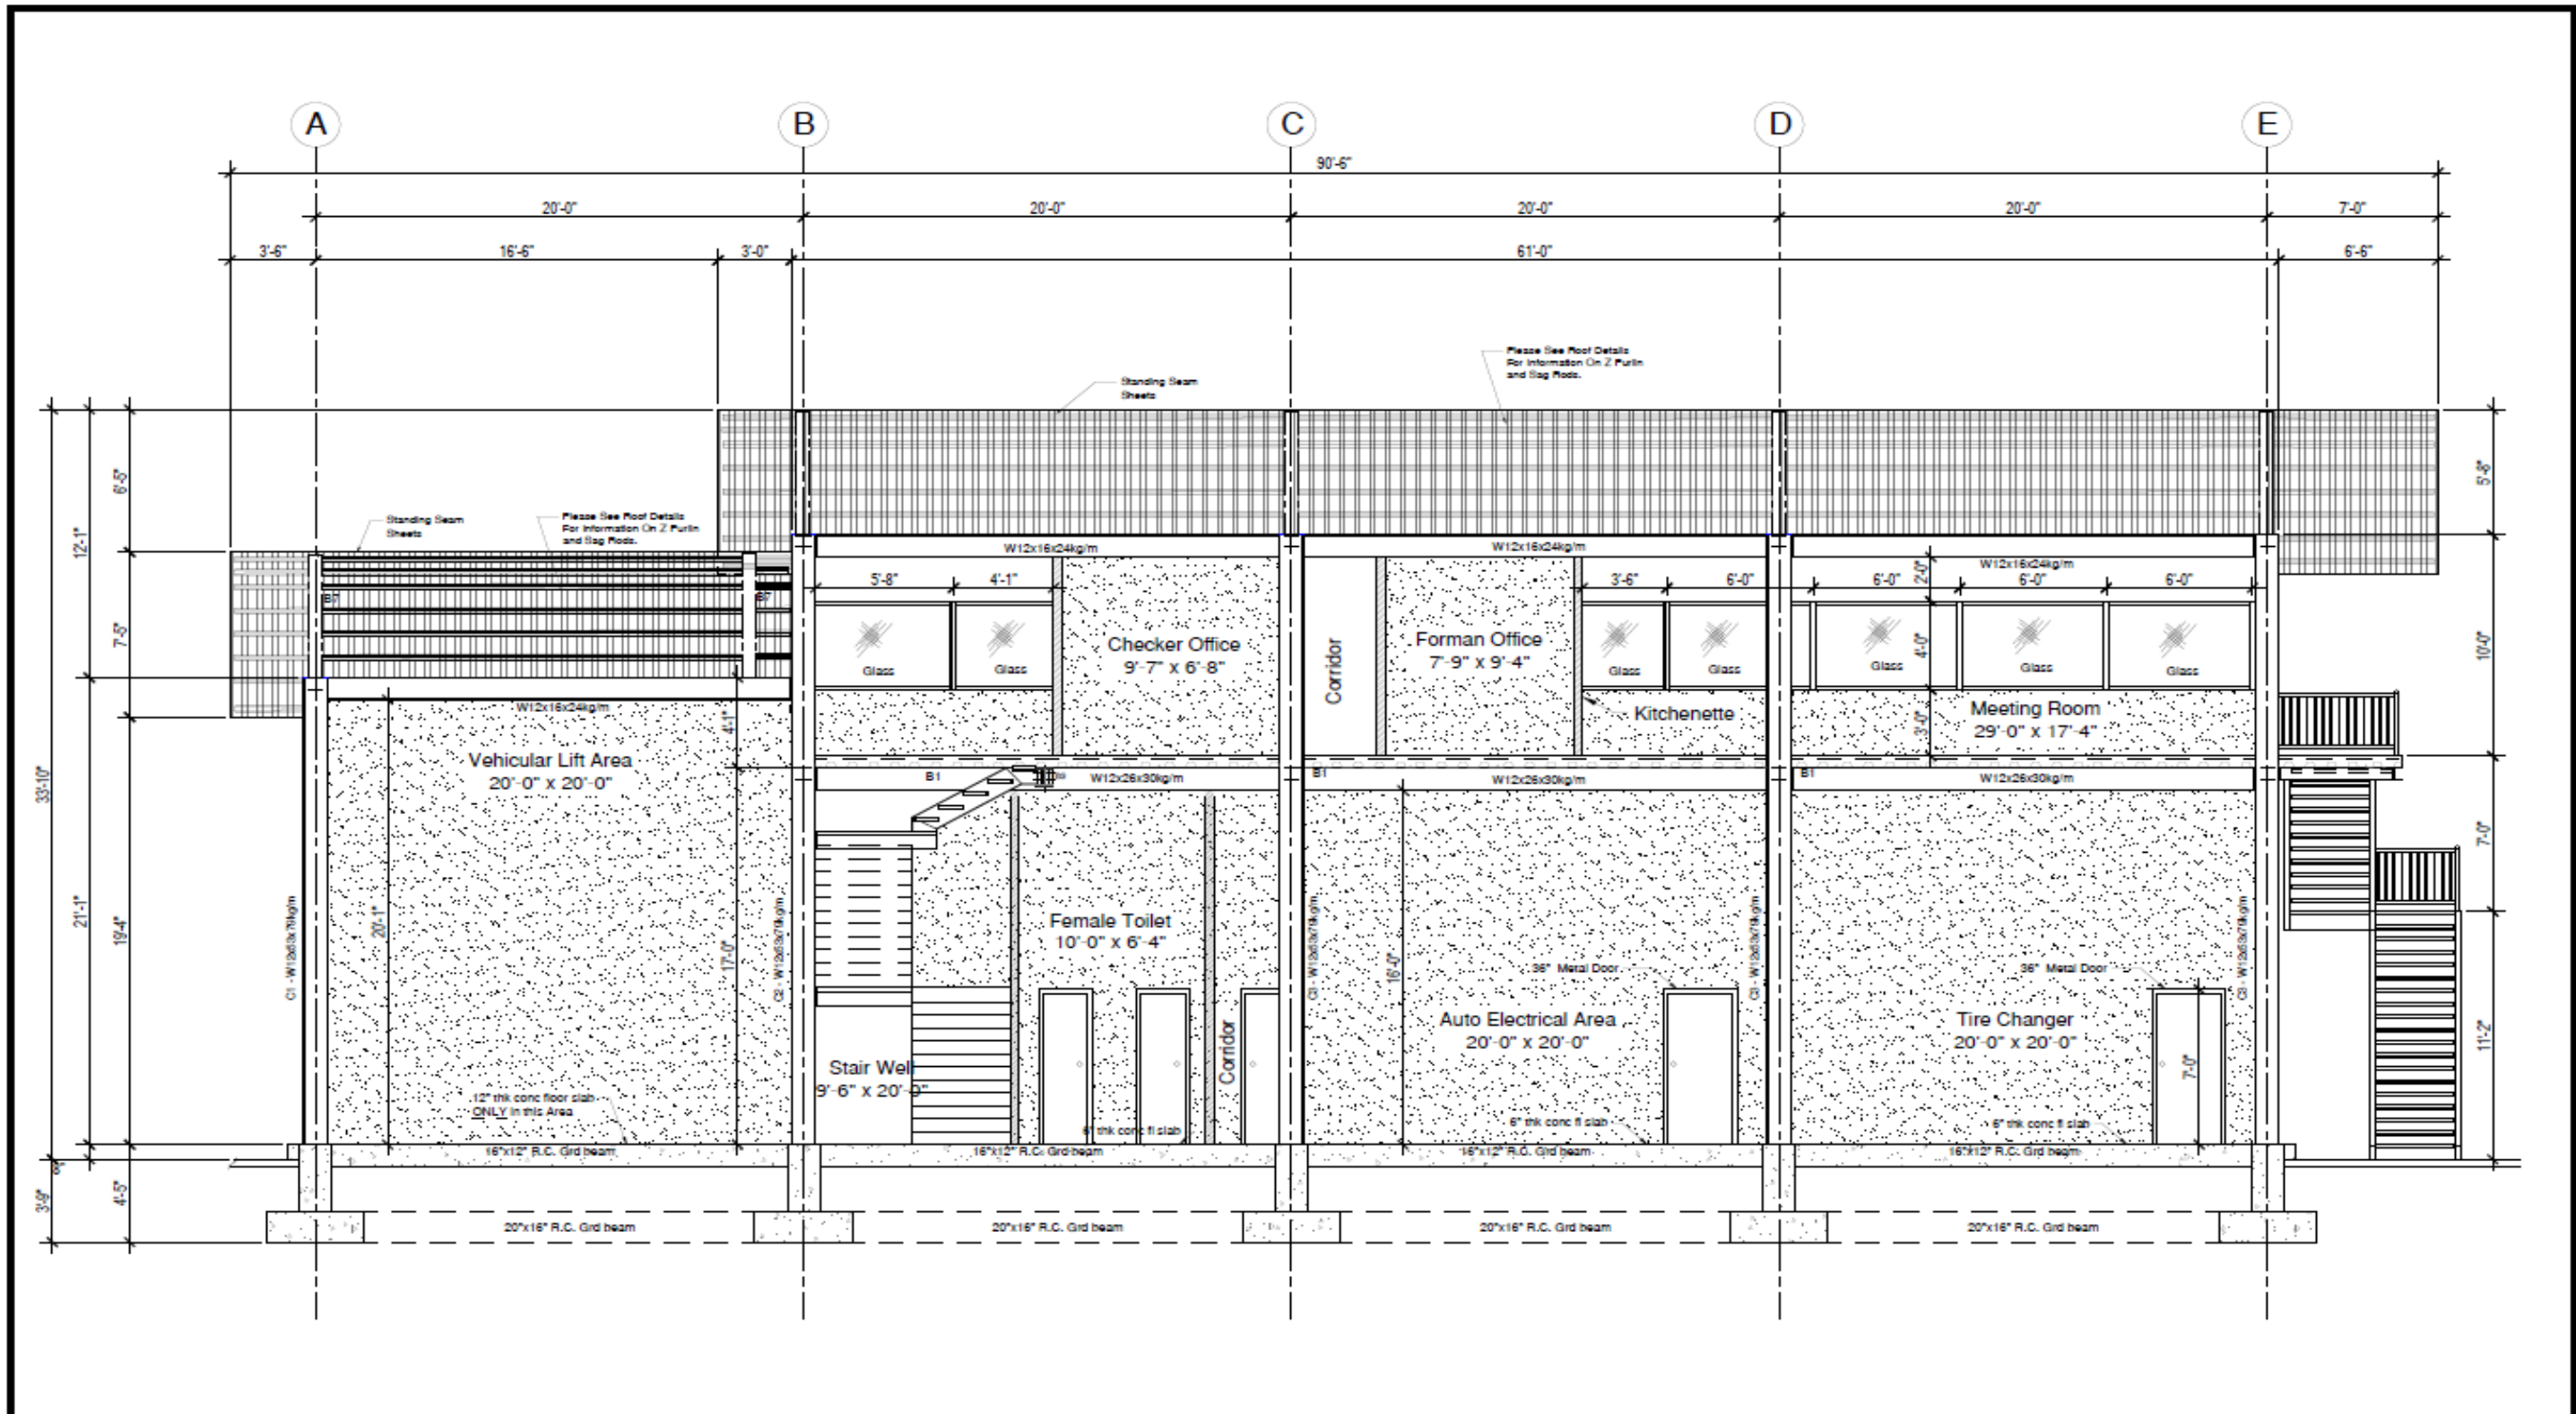

PROJECT: TRACTOR POOL	CLIENT: DIVISION OF FOOD SECURITY, NATURAL RESOURCES, THE ENVIRONMENT & SUSTAINABLE DEVELOPMENT.	LOCATION: OLD GOVERNMENT FARM ROAD, SHAW PARK, TOBAGO.
TITLE: LONGITUDINAL SECTION	DATE: SS-TT	DATE STARTED: 01.02.2024
	CONTACT: 639-1966	DATE FINISHED: 07.02.2024
		SCALE: N.T.S.
		JOB NO.: D/002/2024
		SHEET NO.: ST 07

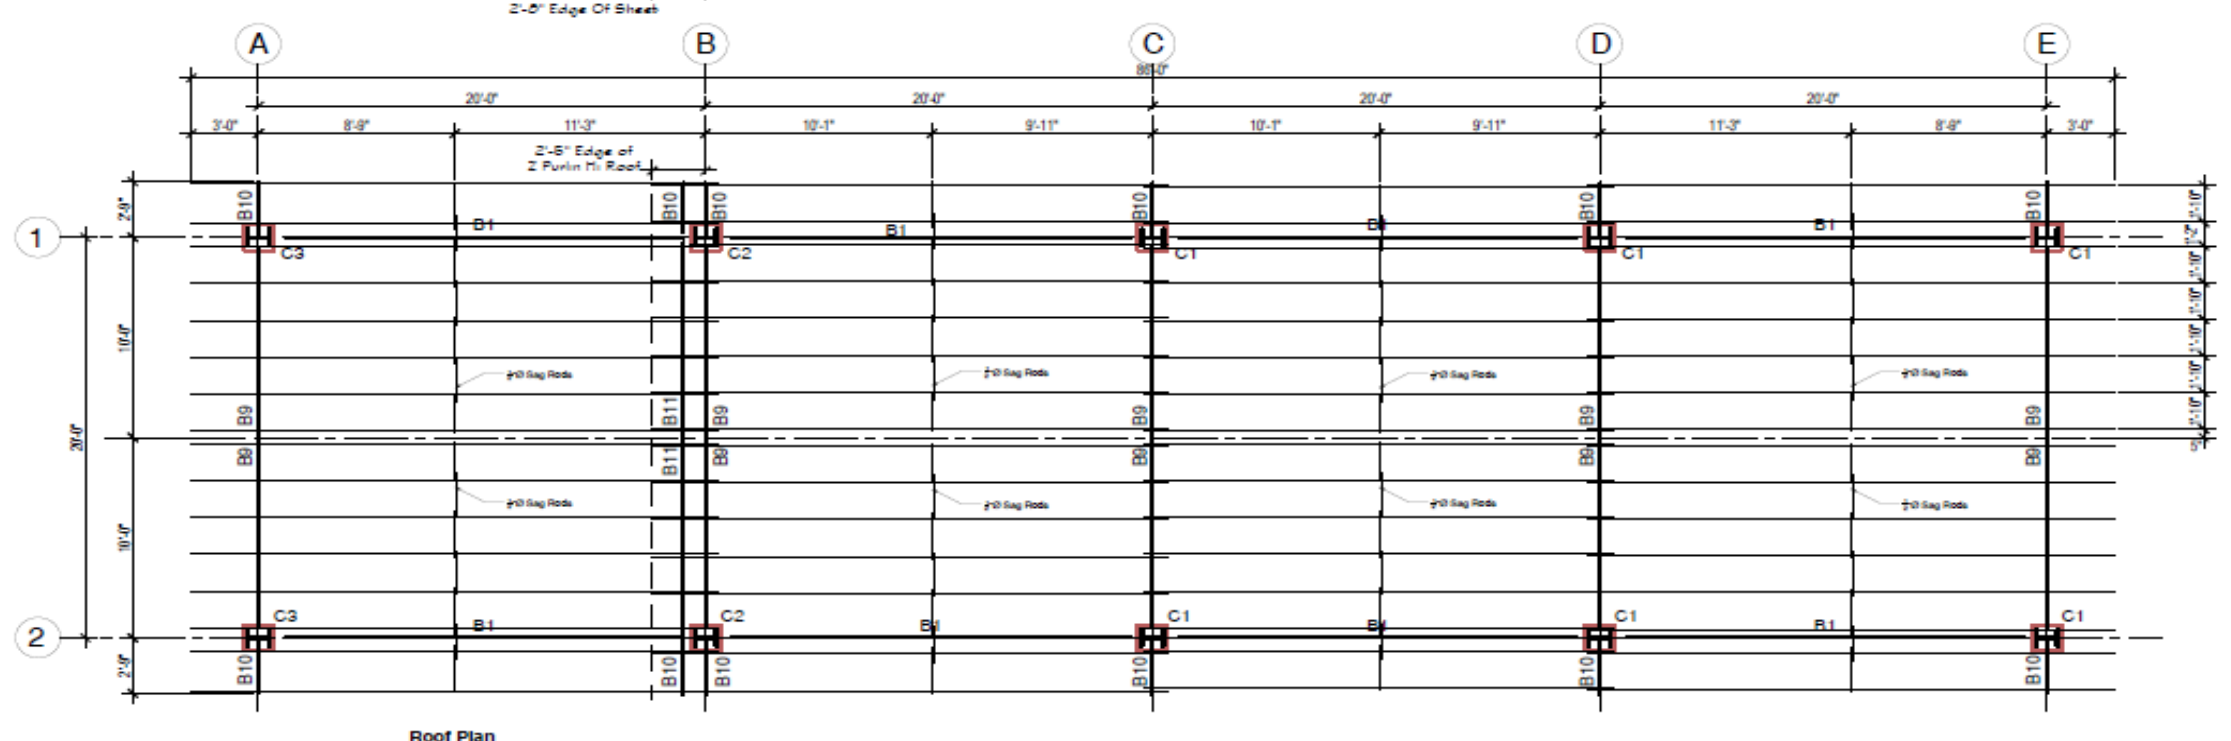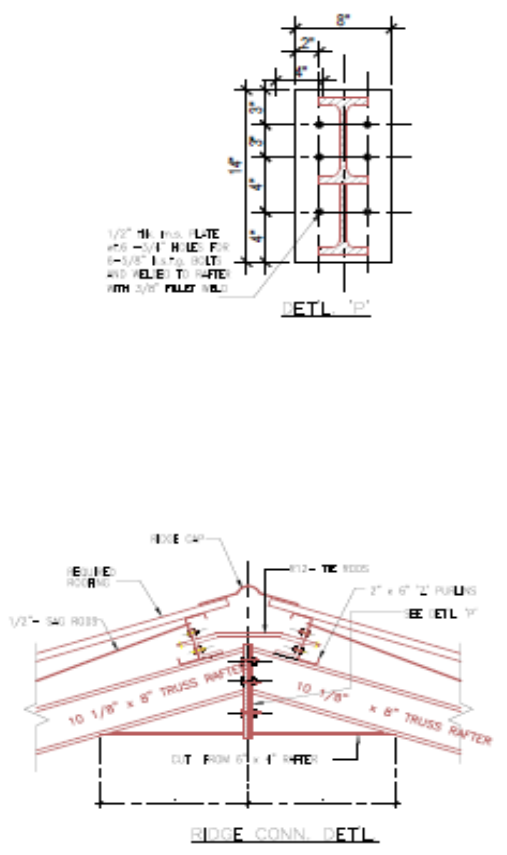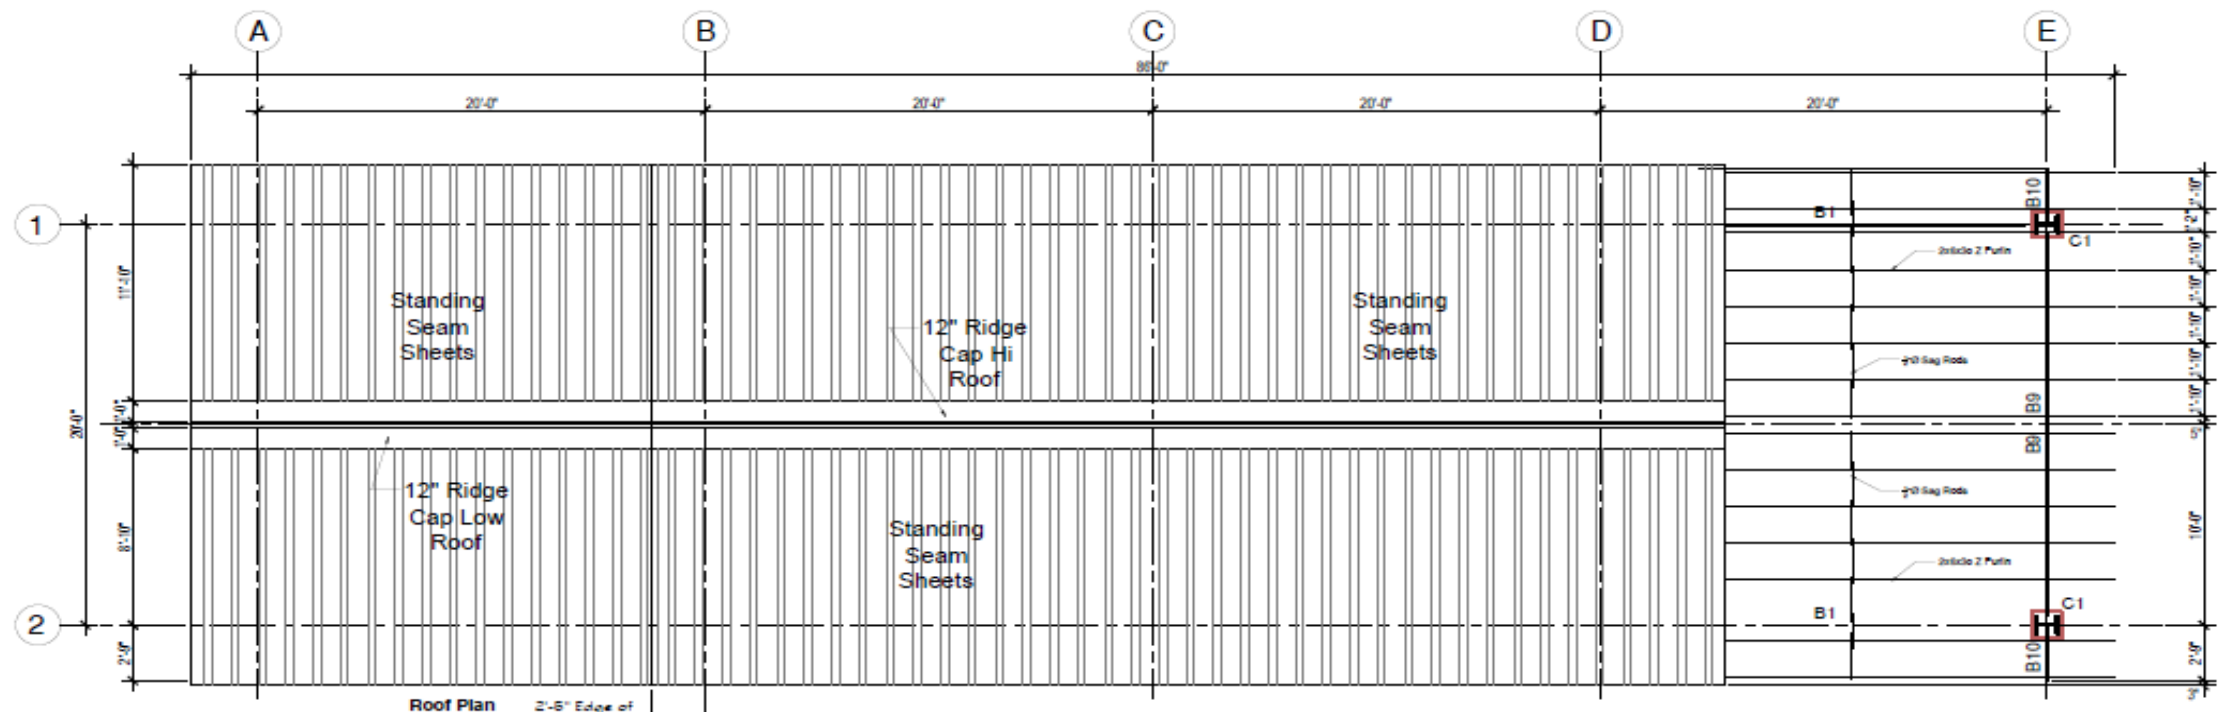

SUBJECT: TRACTOR POOL		CLIENT:	DIVISION OF FOOD SECURITY, NATURAL RESOURCES, THE ENVIRONMENT & SUSTAINABLE DEVELOPMENT. Contact: 639-1966		LOCATION:	OLD GOVERNMENT FARM ROAD, SHAW PARK, TOBAGO.			
TITLE: ROOF PLAN & DETAIL		DRAWN BY:	SS-TT		DATE STARTED:	DATE FINISHED:	SCALE:	DWG. NO.:	SHEET NO.:
				01-02-2024		07-02-2024	N.T.S.	D/002/2024	ST 08

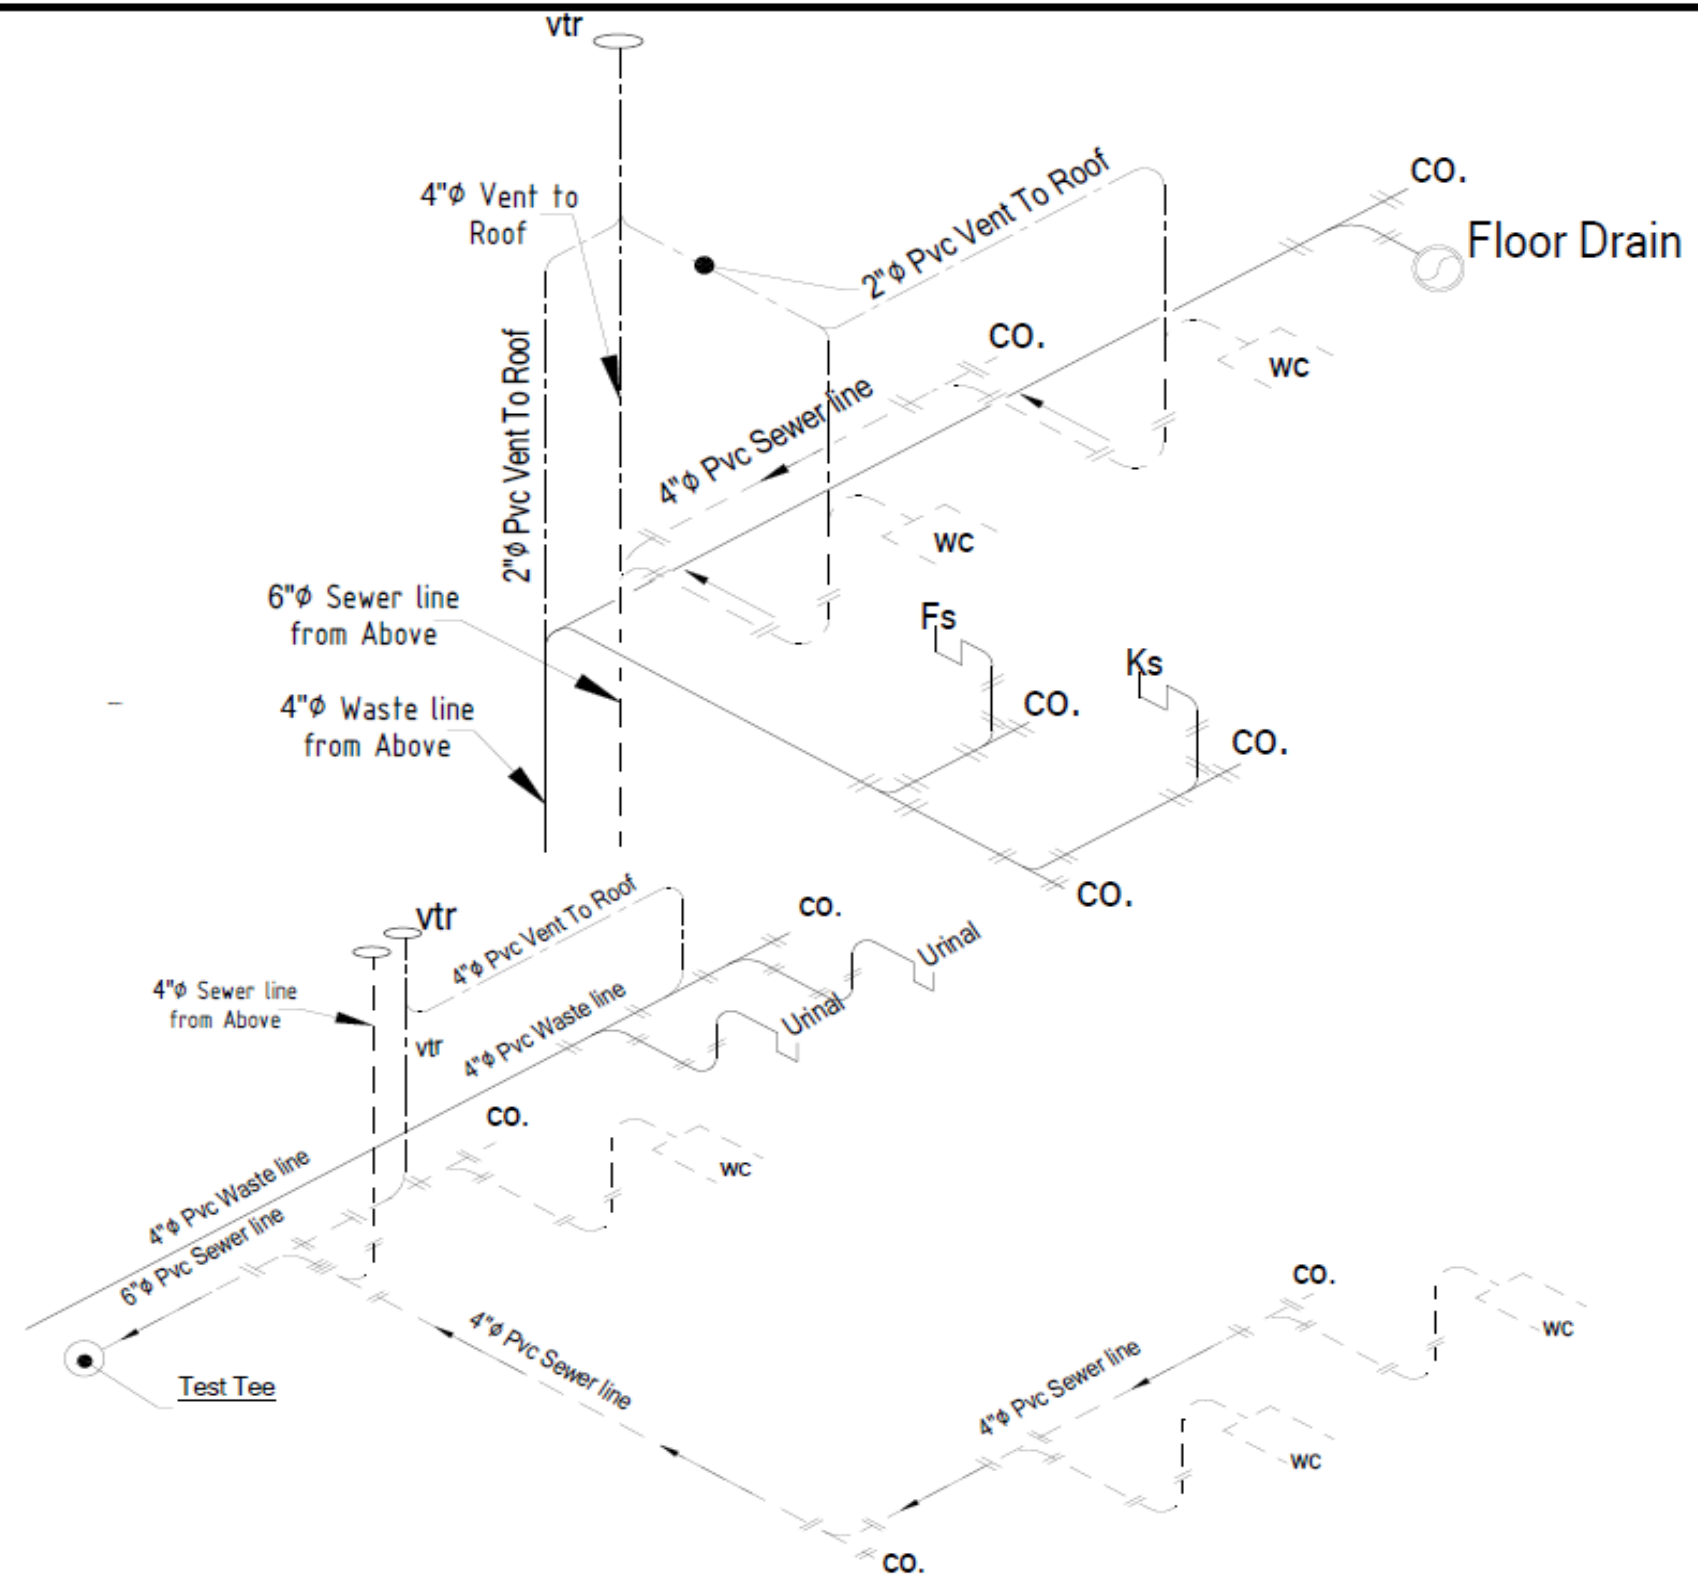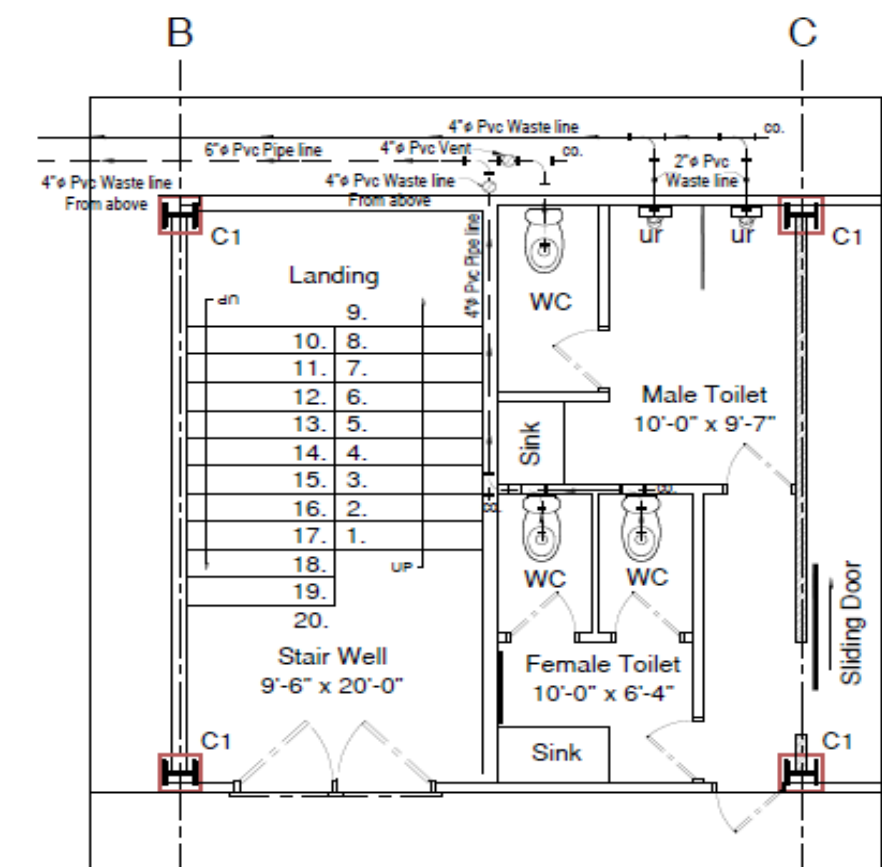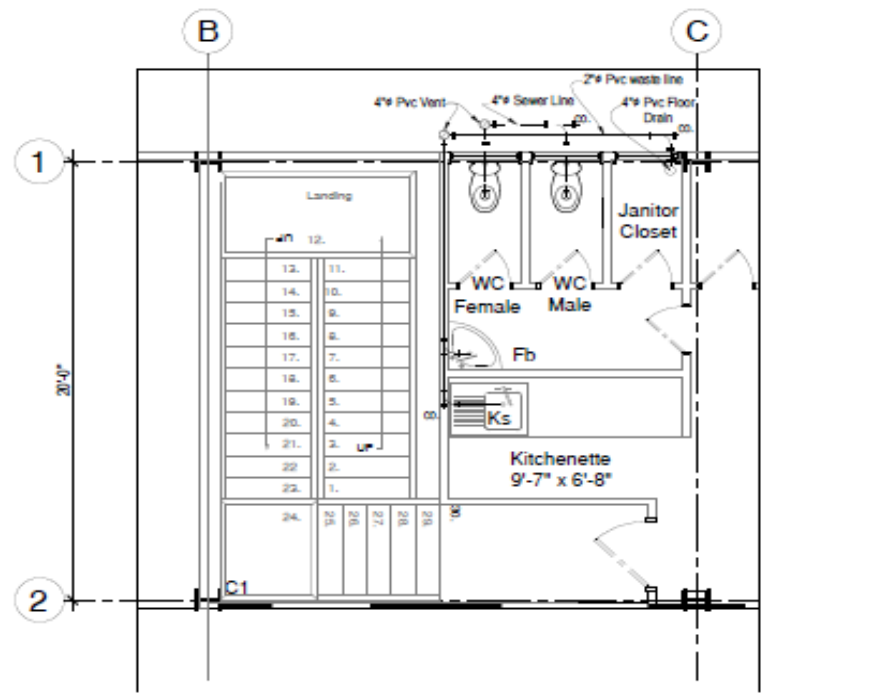

PROJECT: TRACTOR POOL	CLIENT: DIVISION OF FOOD SECURITY, NATURAL RESOURCES, THE ENVIRONMENT & SUSTAINABLE DEVELOPMENT.	LOCATION: OLD GOVERNMENT FARM ROAD, SHAW PARK, TOBAGO.
TITLE: PLUMBING PLAN & ISO DETAIL	CONTACT: 639-1966	DATE STARTED: 01.02.2024
DRAWN BY: SS-TT		DATE FINISHED: 07.02.2024
		SCALE: N.T.S.
		DWG NO: D/002/2024
		SHEET NO: ST 10



Division of Food Production, Forestry and Fisheries

Shirvan Administrative Complex (Milshirv)
 Corner Milford and Shirvan Road
 Tobago.
 Tel: 639-2234; 639-1966; 660-7152 Fax:639-1746

**Proposed Building for
 TRACTOR POOL
 Maintenance Division**

No.	Description	Date

Perspective 1

Project number C/008/2024
 Date 24/07/2024
 Drawn by Sherwyn Sergeant
 Checked by James Trotman

A100

Scale 12" = 1'-0"



Division of Food Production, Forestry and Fisheries

Shirvan Administrative Complex (Milshirv)
 Corner Milford and Shirvan Road
 Tobago.
 Tel: 639-2234; 639-1966; 660-7152 Fax:639-1746

**Proposed Building for
 TRACTOR POOL
 Maintenance Division**

No.	Description	Date

Perspective 2

Project number C/008/2024
 Date 24/07/2024
 Drawn by Sherwyn Sergeant
 Checked by James Trotman

A101

Scale 12" = 1'-0"